

85% REVIEW SET

CRESCENT 7TH STREET
MIXED-USE

CRESCENT COMMUNITIES


LOCATION / CHARLOTTE, NC
PROJECT # / 19CRC150
DATE / 01.21.2020
DRAWN / Author

COPYRIGHT 2019 BB+M ARCHITECTURE PLLC.

Revisions		
No.	Description	Date
3	Revision 3	02/07/2020

**PARKING LEVEL 3 -
ELECTRICAL**

EG1.03

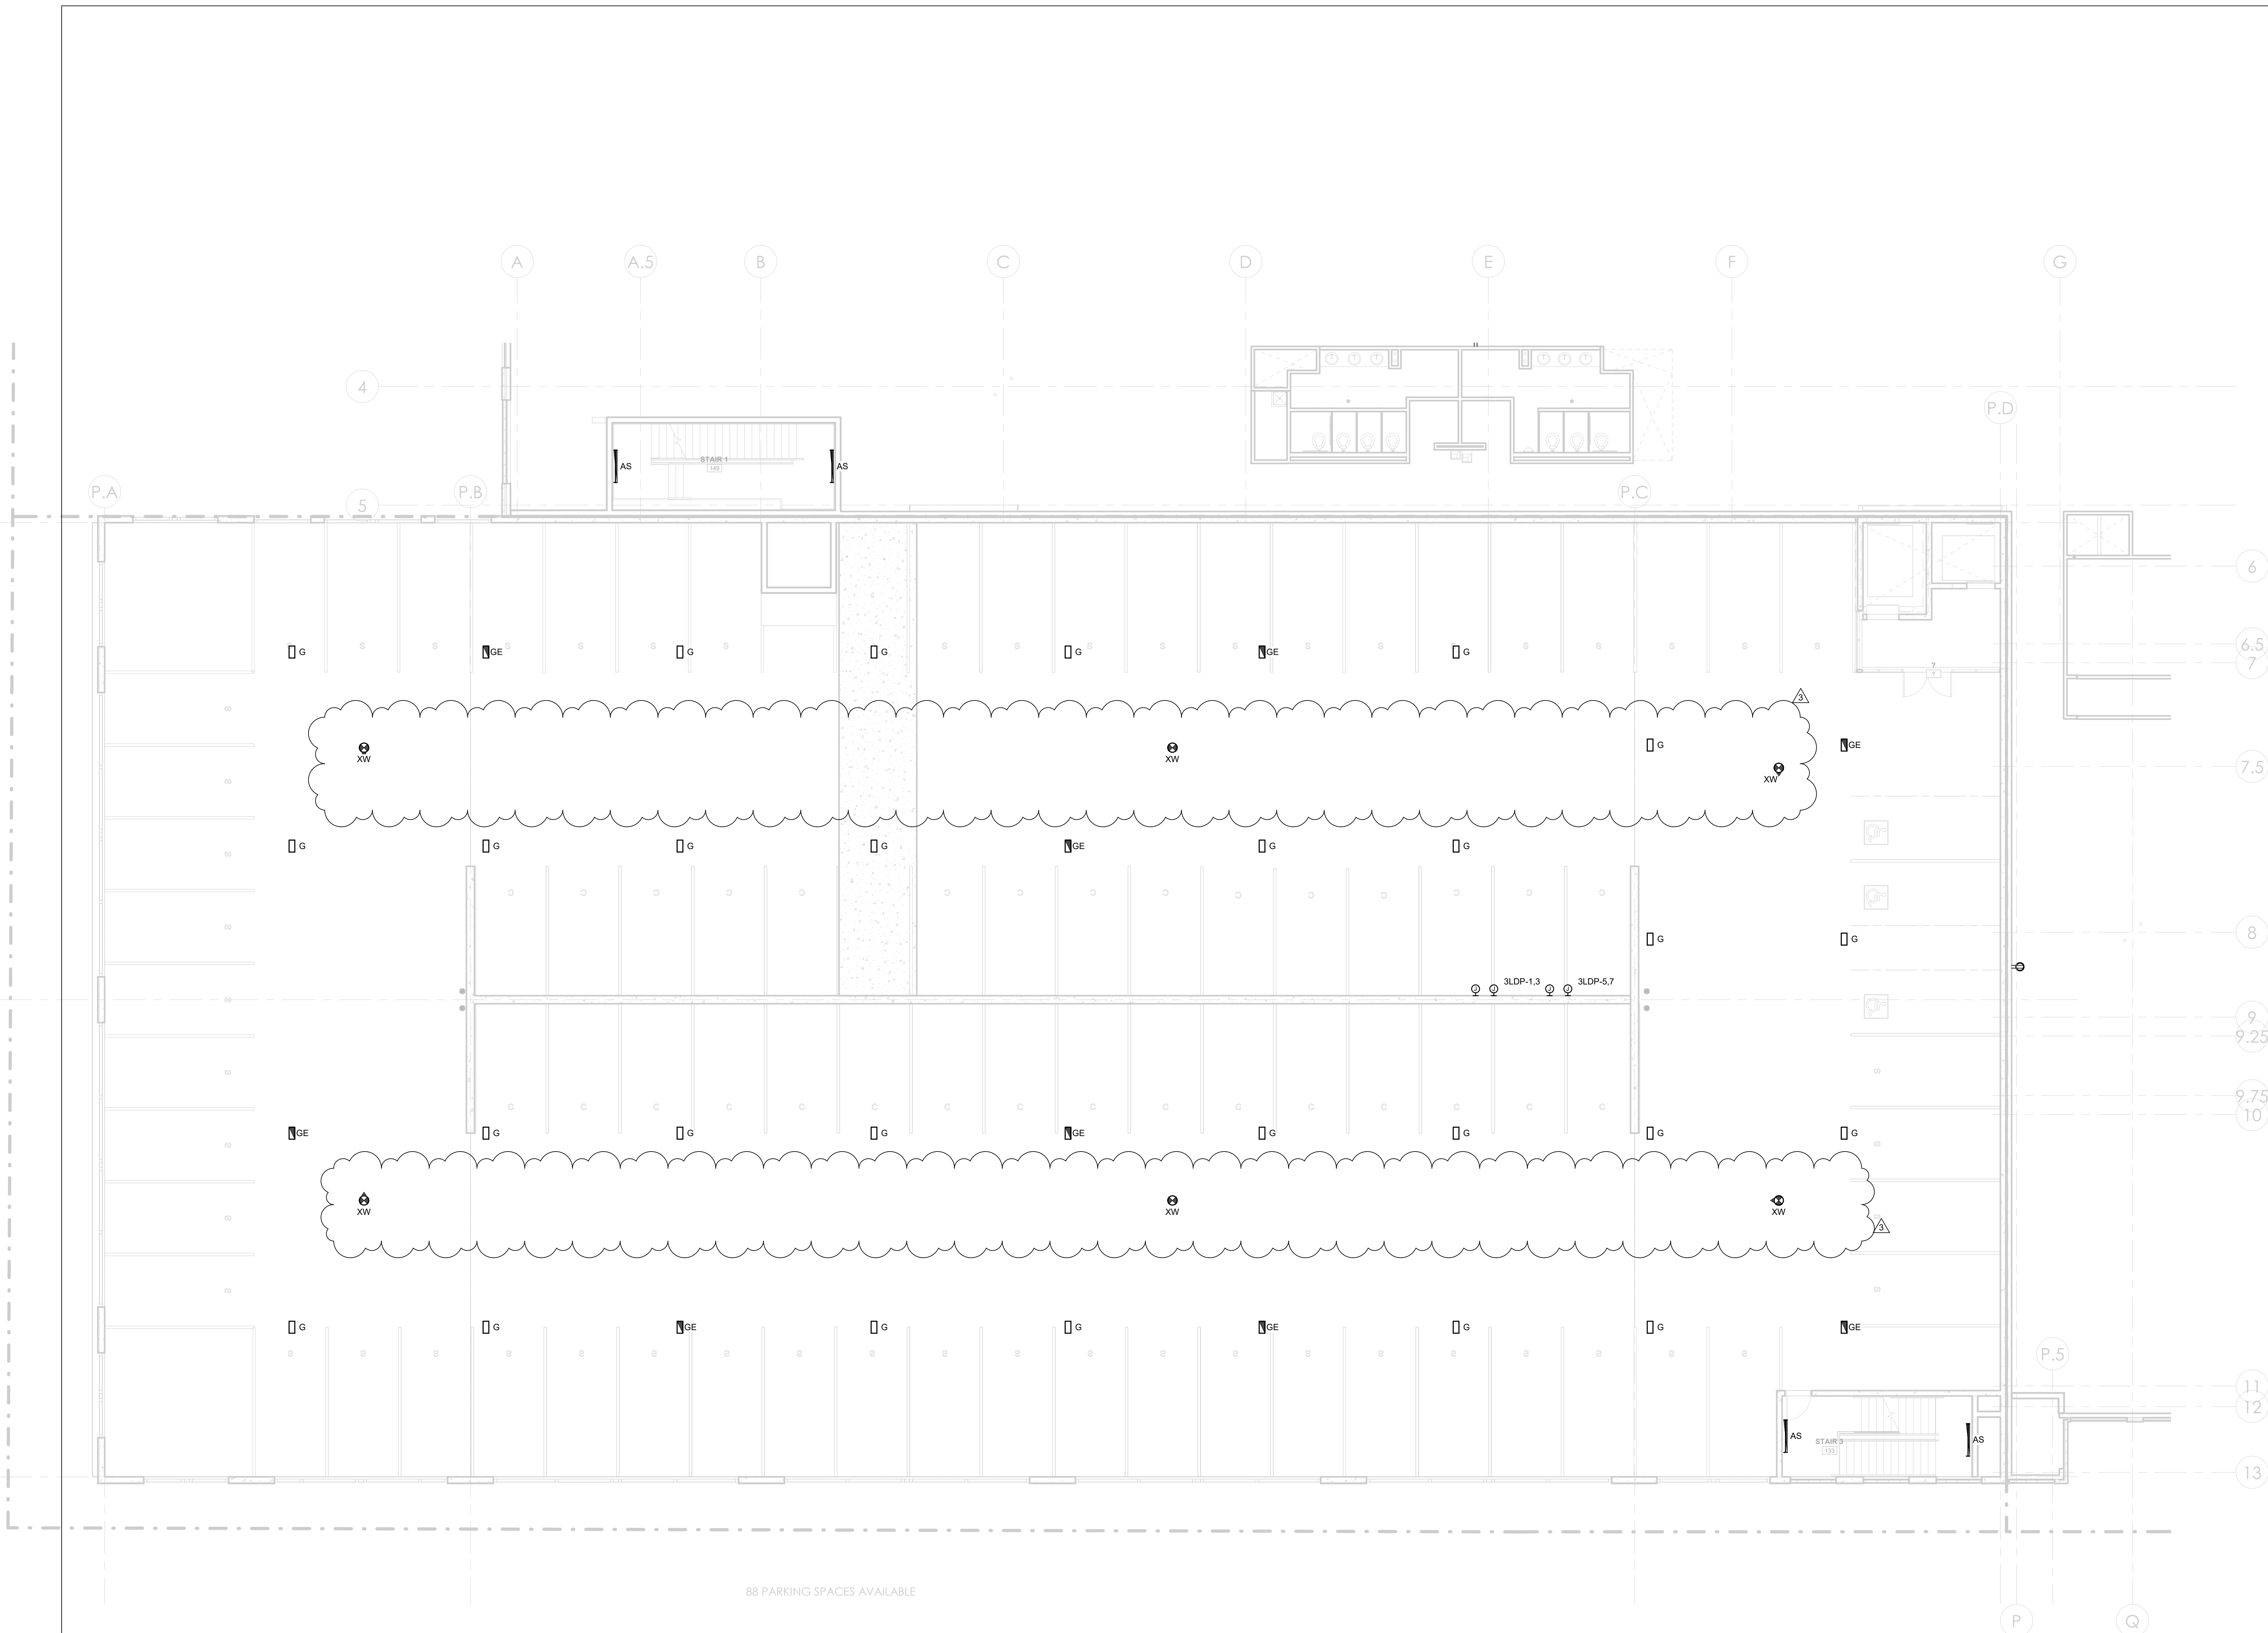

1 PARK LEVEL 3 - ELECTRICAL PLAN
EG1.03 SCALE: 1/8" = 1'-0"