

85% REVIEW SET

CRESCENT 7TH STREET
MIXED-USE

CRESCENT COMMUNITIES

LOCATION / CHARLOTTE, NC
PROJECT # / 19CRC150
DATE / 01.21.2020
DRAWN / Author

COPYRIGHT 2019 BB+M ARCHITECTURE PLLC.


Revisions		
No.	Description	Date
3	Revision 3	02/07/2020

PARKING LEVEL 4 -
ELECTRICAL

EG1.04

GENERAL NOTES:

- A. POLE-MOUNT FIXTURES, FIXTURE TYPE GP, LOCATED WHERE THE PARKING GROUND ELEVATES, SHALL BE MOUNTED SO THE TOPS OF ALL FIXTURES ALONG THE RAMP ARE LEVEL. THE FIXTURE AT THE LOWEST ELEVATION OF THE RAMP SHALL BE 12'-0" AFG.

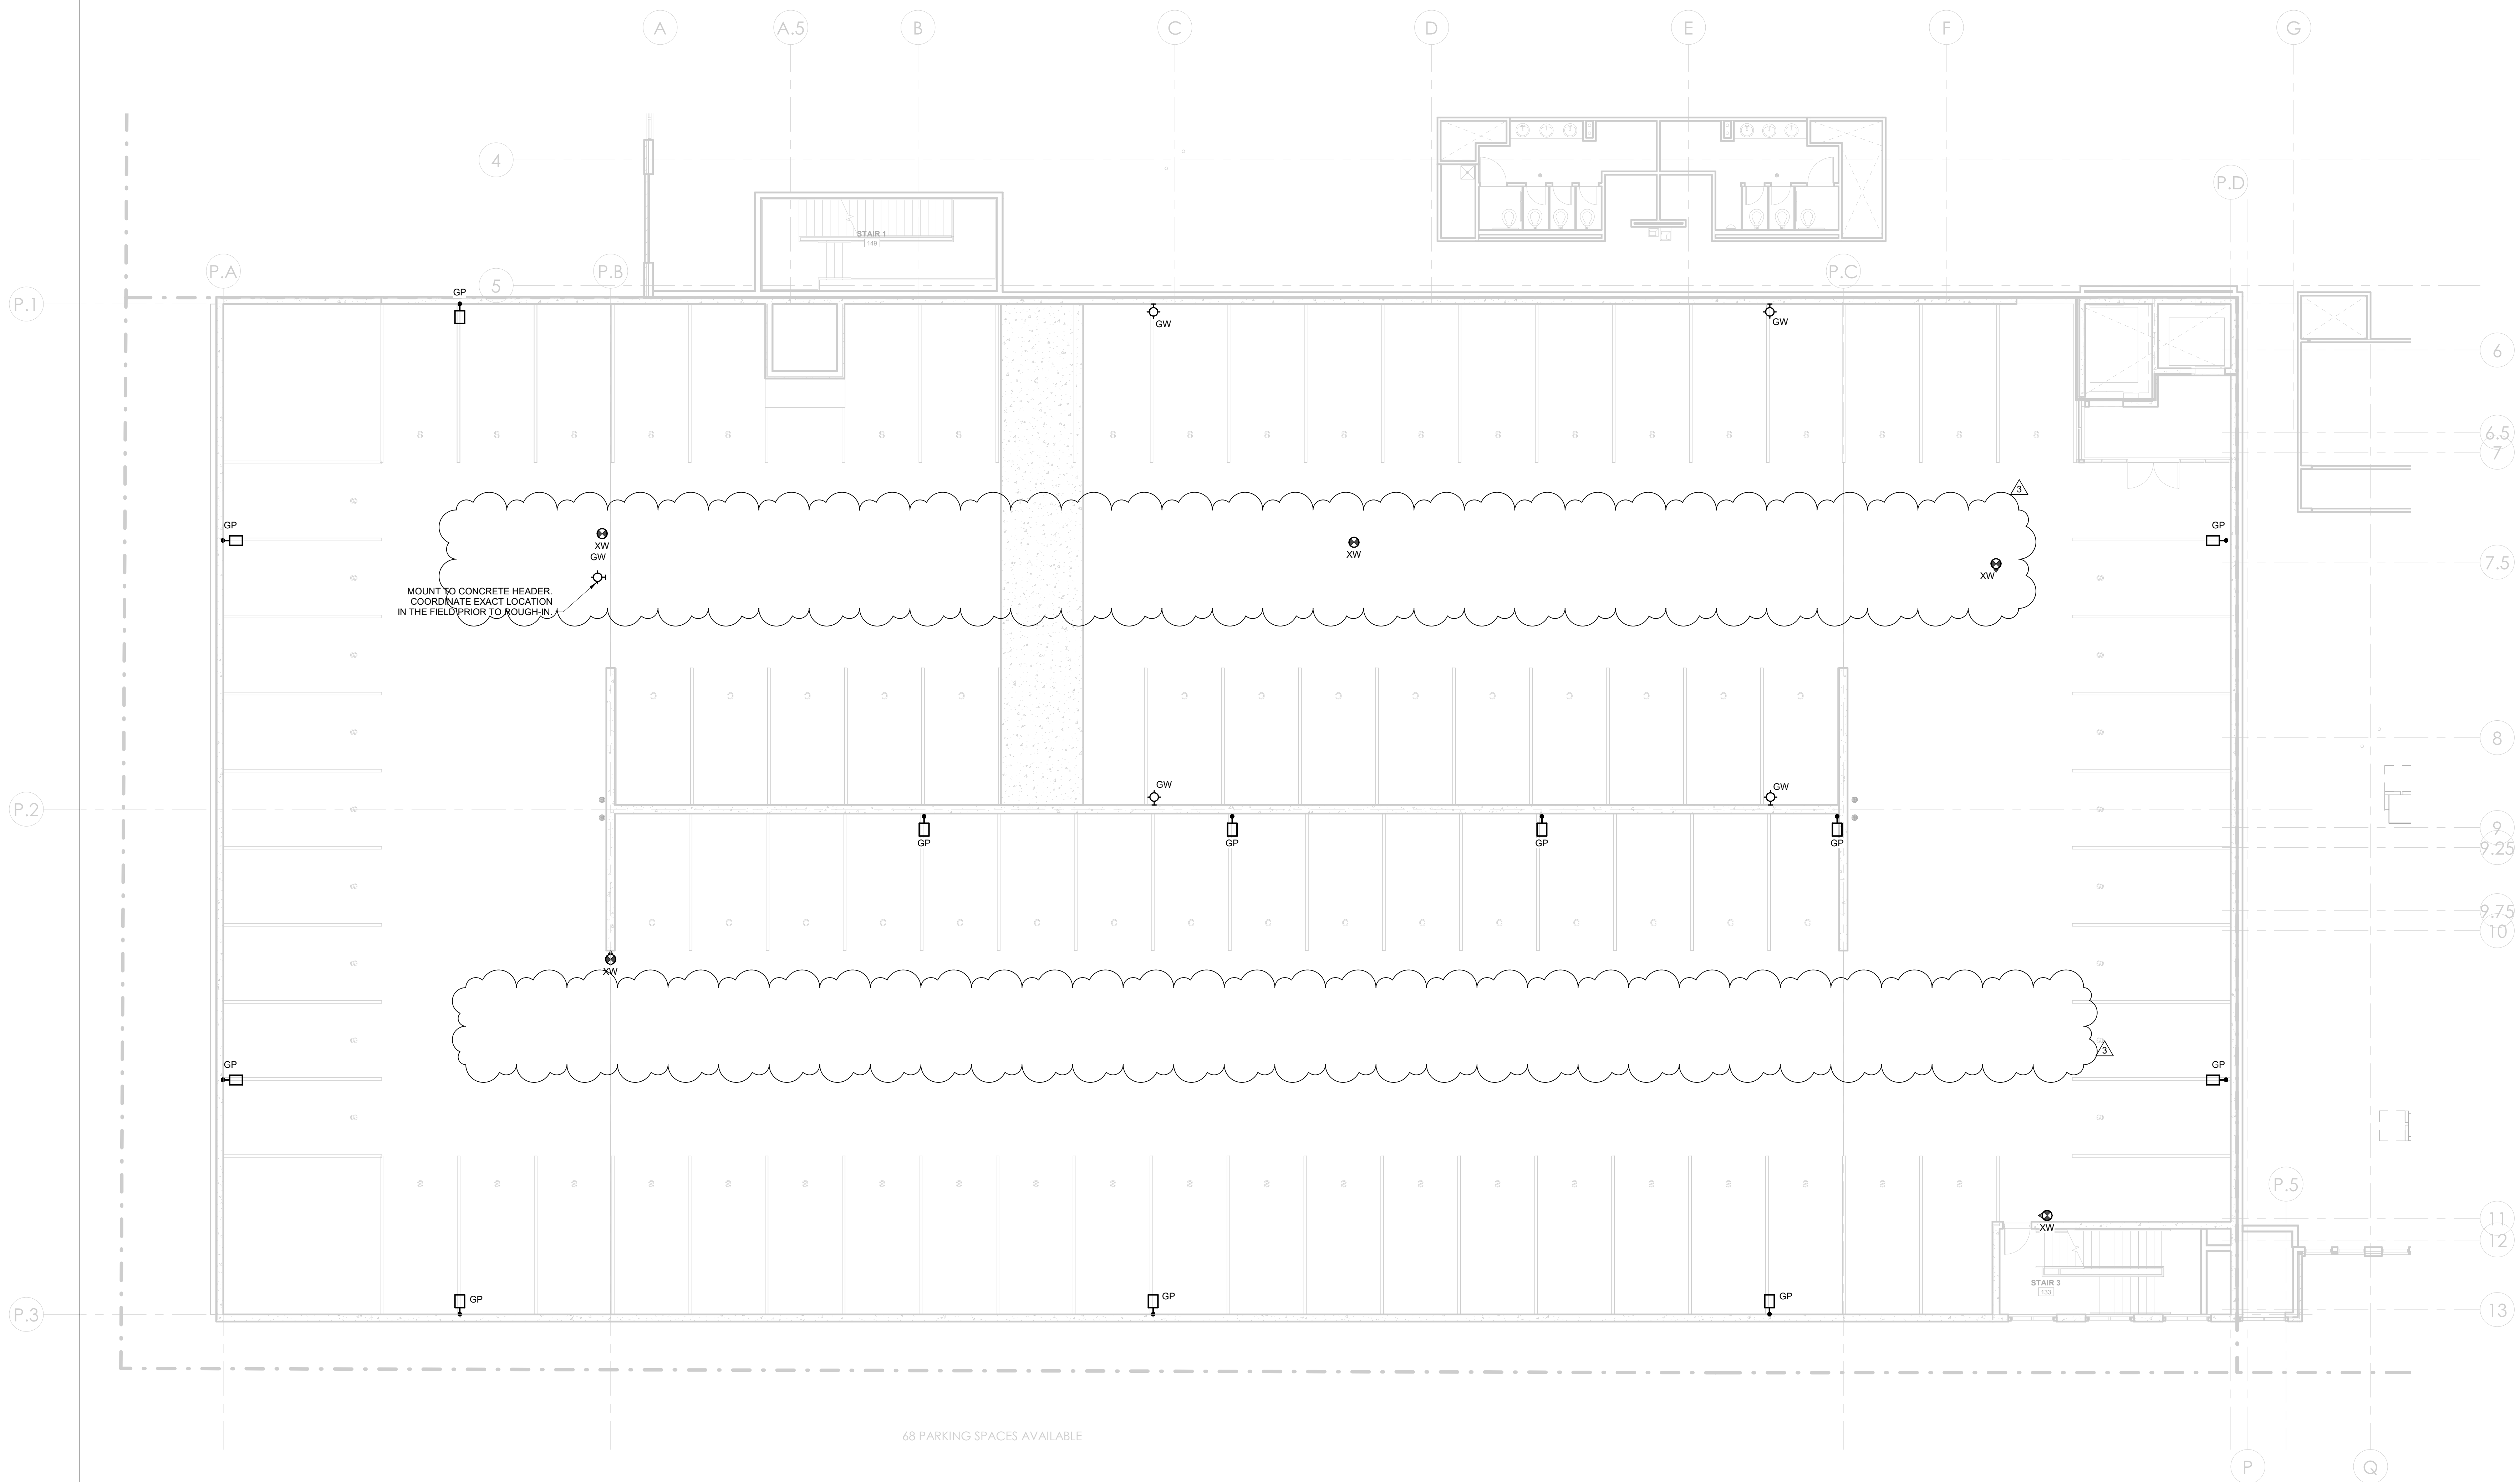

1
EG1.04
PARK LEVEL 4 - ELECTRICAL PLAN
SCALE: 1/8" = 1'-0"