



85% REVIEW SET

CRESCENT 7TH STREET
MIXED-USE

CRESCENT COMMUNITIES


LOCATION / CHARLOTTE, NC
PROJECT # / 19CRC150
DATE / 01.21.2020
DRAWN / Author

COPYRIGHT 2019 BB+M ARCHITECTURE PLLC.

Revisions		
No.	Description	Date

**LEVEL 3 FLOOR PLAN -
FIRE PROTECTION**

FP1.03

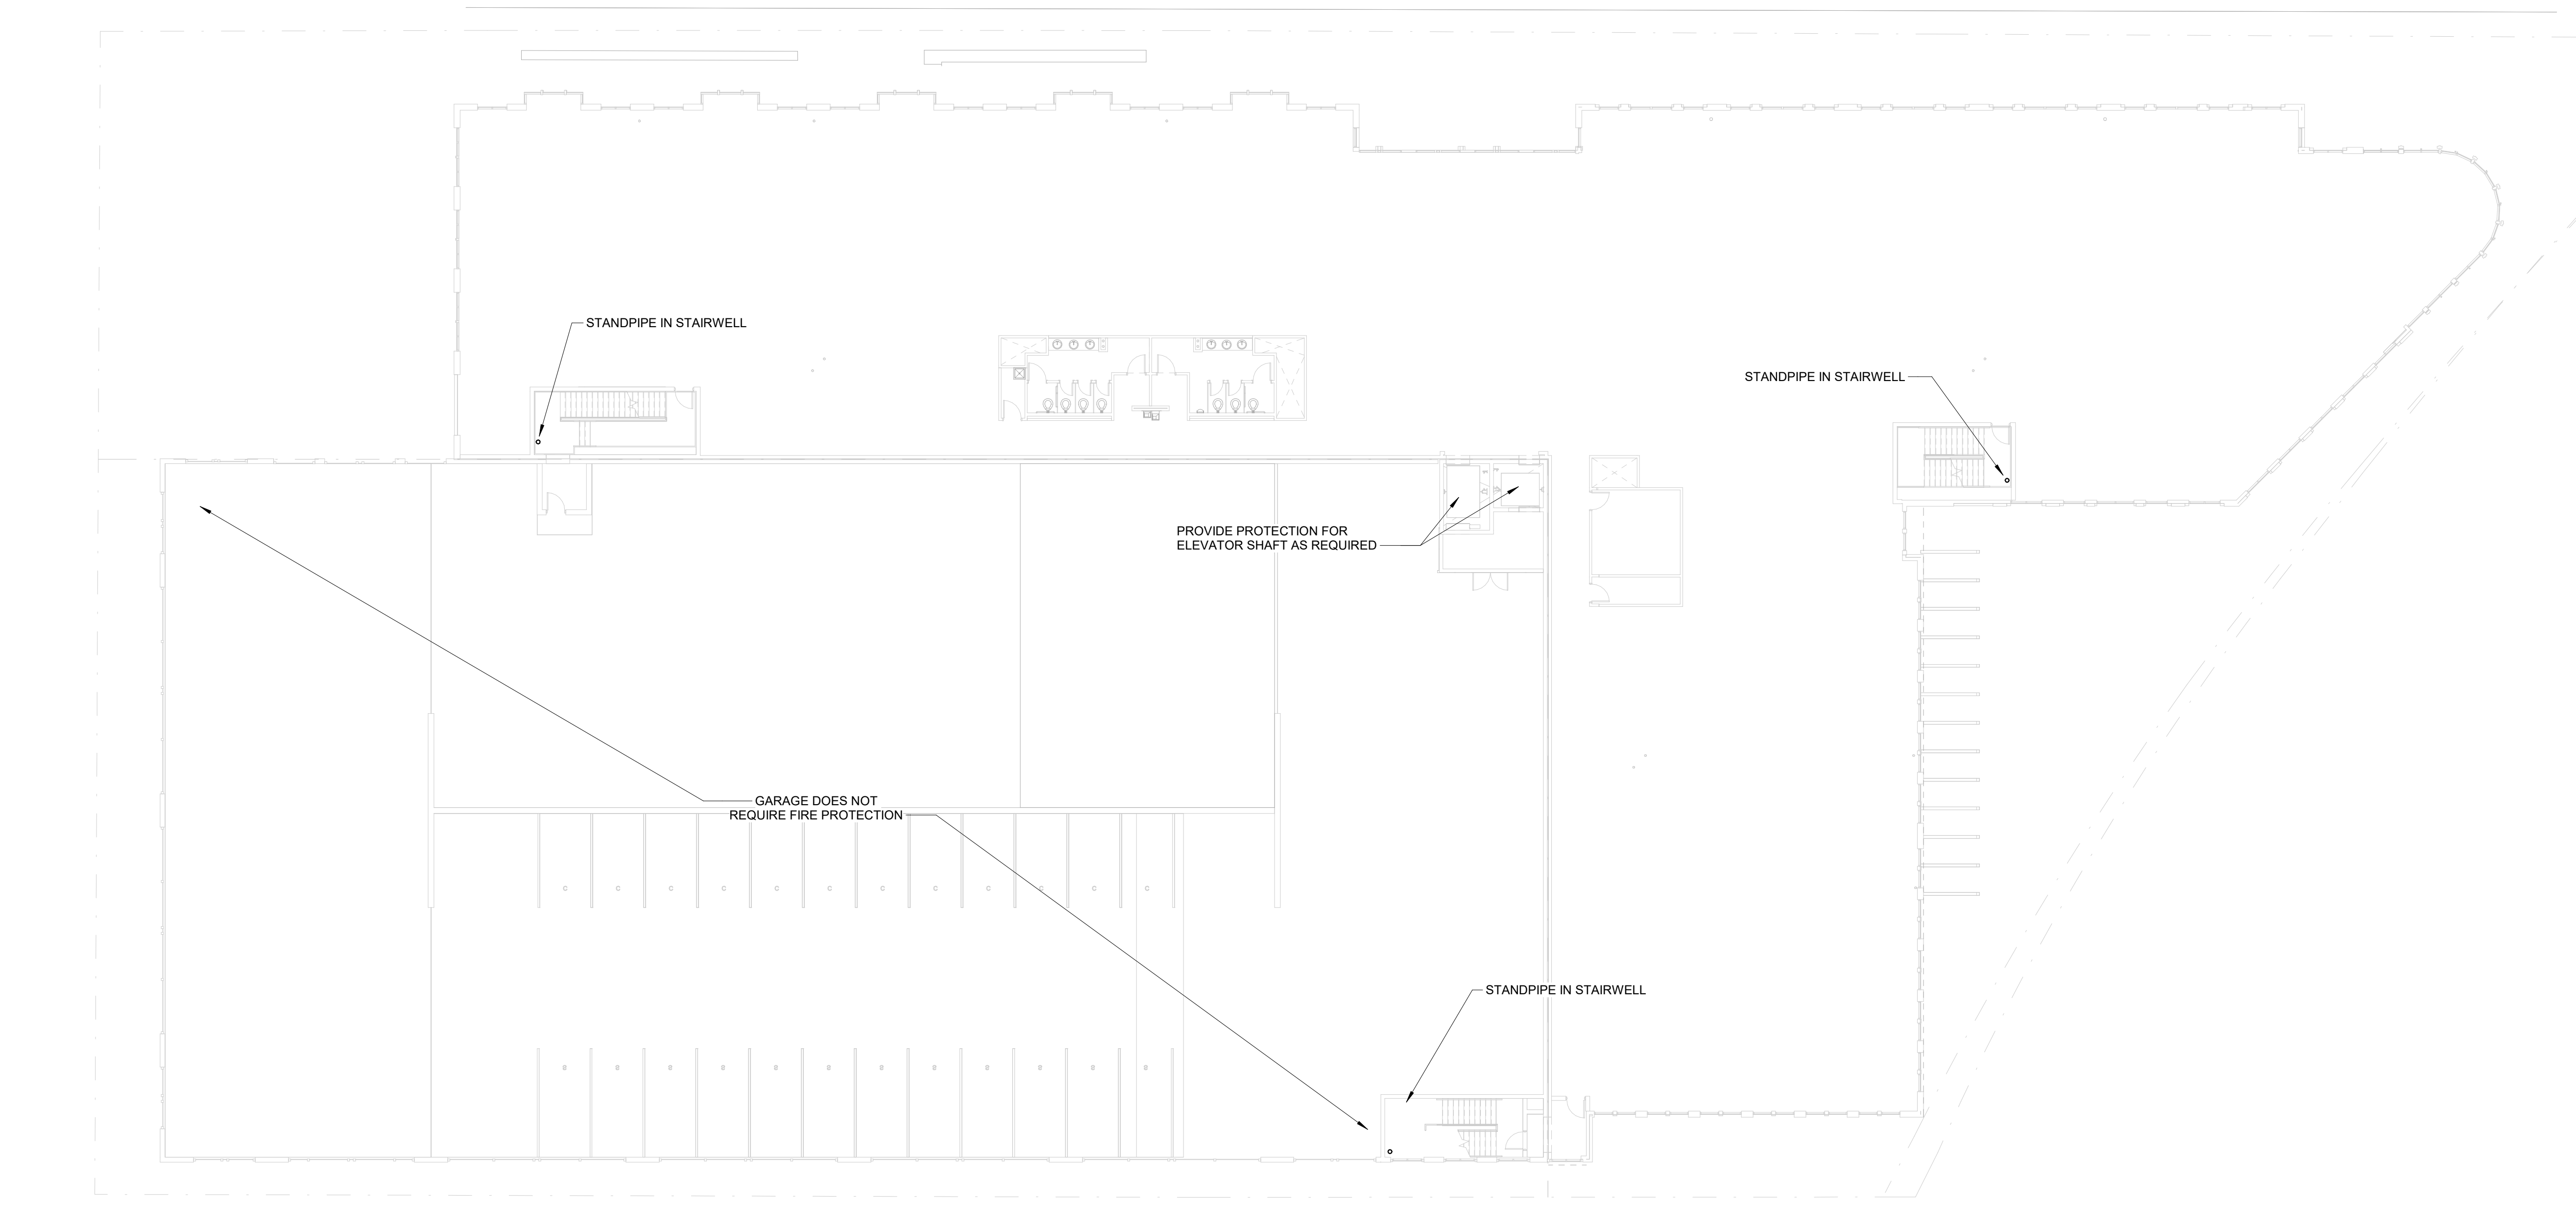

LEVEL 3 - FIRE PROTECTION PLAN
SCALE: 1/16" = 1'-0"