


#	KEY NOTES
1	ROUTE GAS PIPING ON THIS FLOOR AS HIGH AS POSSIBLE
2	PROVIDE 3" DRAIN CONNECTING THE TWO PITS TO GRAVITY FLOW TO SUMP PUMP
3	ROUTE SUMP PUMP DRAIN TO DAYLIGHT AT SPLASHBLOCK FOR INDIRECT DRAINAGE TO STORM.

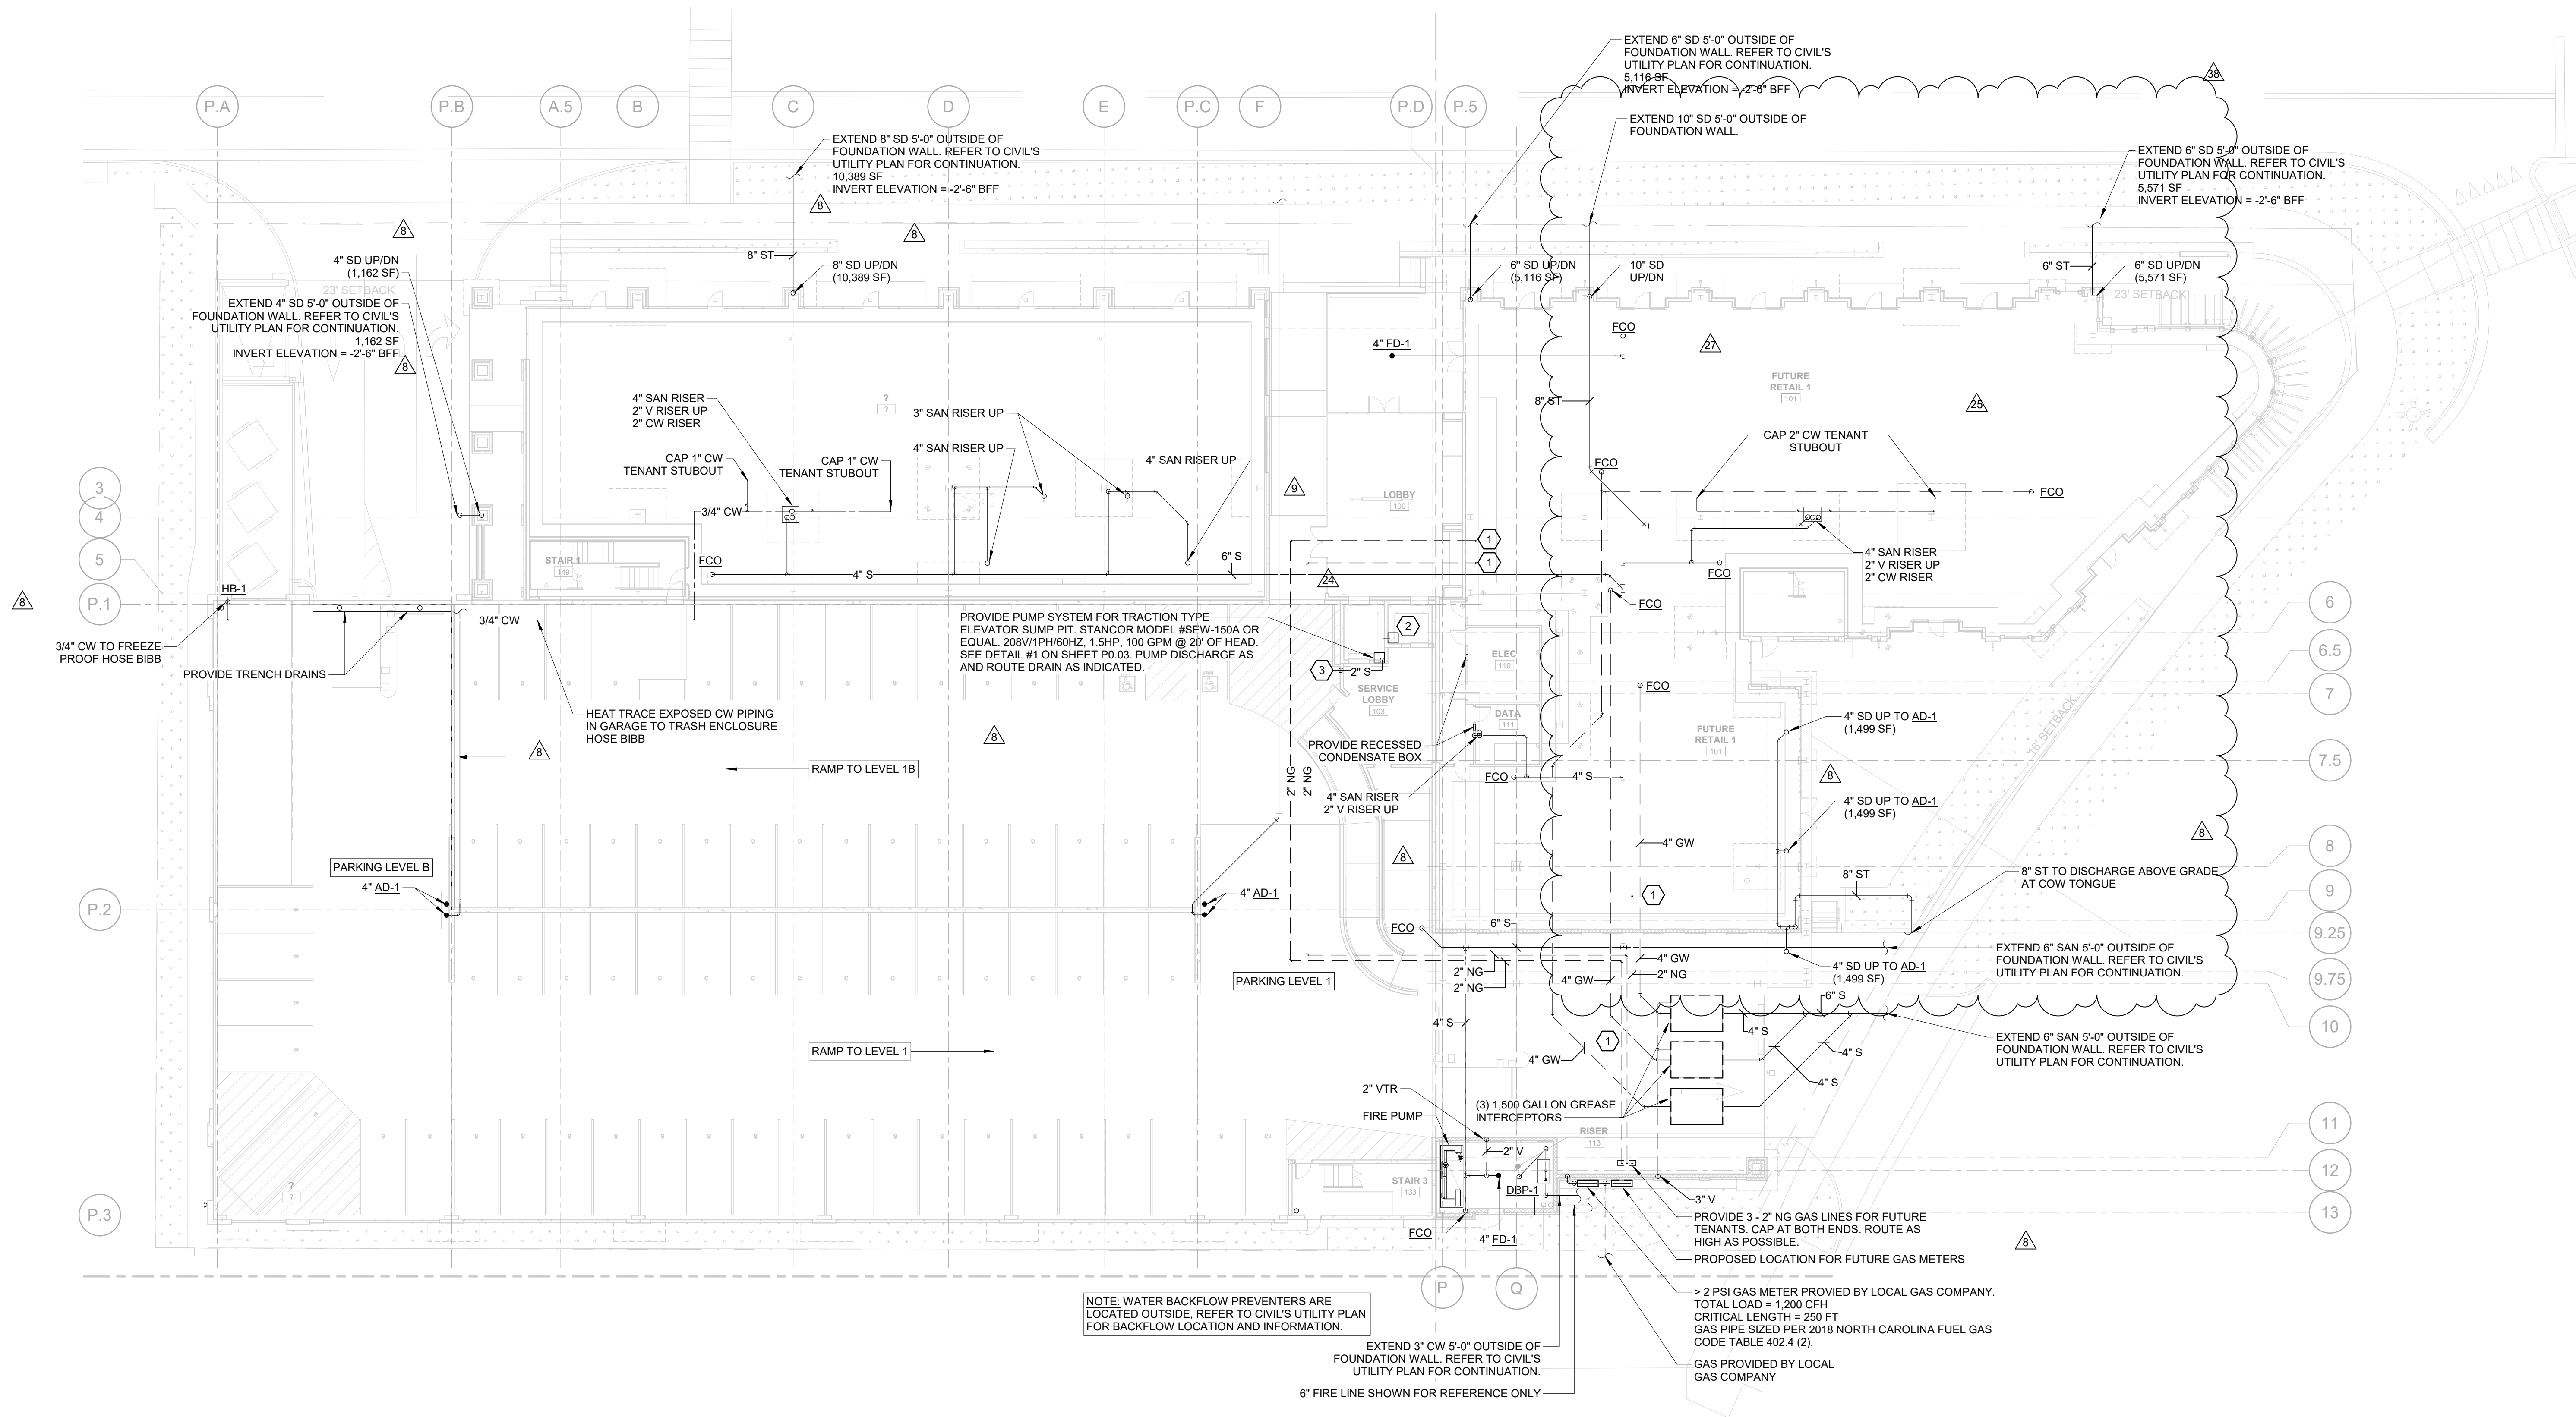

FOR CONSTRUCTION



CRESCENT COMMUNITIES

LOCATION / CHARLOTTE, NC  
PROJECT # / 19CRC150  
DATE / 04.22.2020  
DRAWN / DSW

COPYRIGHT 2019 BB+M ARCHITECTURE PLLC.

Revisions		
No.	Description	Date
8	FULL BLDG CYCLE 2 - OWNER COMMENTS	05/21/2020
9	FULL BLDG CYCLE 3	06/26/2020
24	ASI 10	10/12/2020
25	ASI 11	11/24/2020
27	ASI 13	12/16/2020
38	ASI 23	05/24/2021

LEVEL 1 FLOOR PLAN - PLUMBING

**LEVEL 1 - DOMESTIC WATER PLAN**  
SCALE: 1/16" = 1'-0"