

**FOR CONSTRUCTION**




CRESCENT COMMUNITIES

LOCATION / CHARLOTTE, NC  
PROJECT # / 19CRC150  
DATE / 04.22.2020  
DRAWN / DSW


COPYRIGHT 2019 BB+M ARCHITECTURE PLLC.

Revisions		
No.	Description	Date
8	FULL BLDG CYCLE 2 - OWNER COMMENTS	05/21/2020

**PARKING LEVEL 4 - PLUMBING**

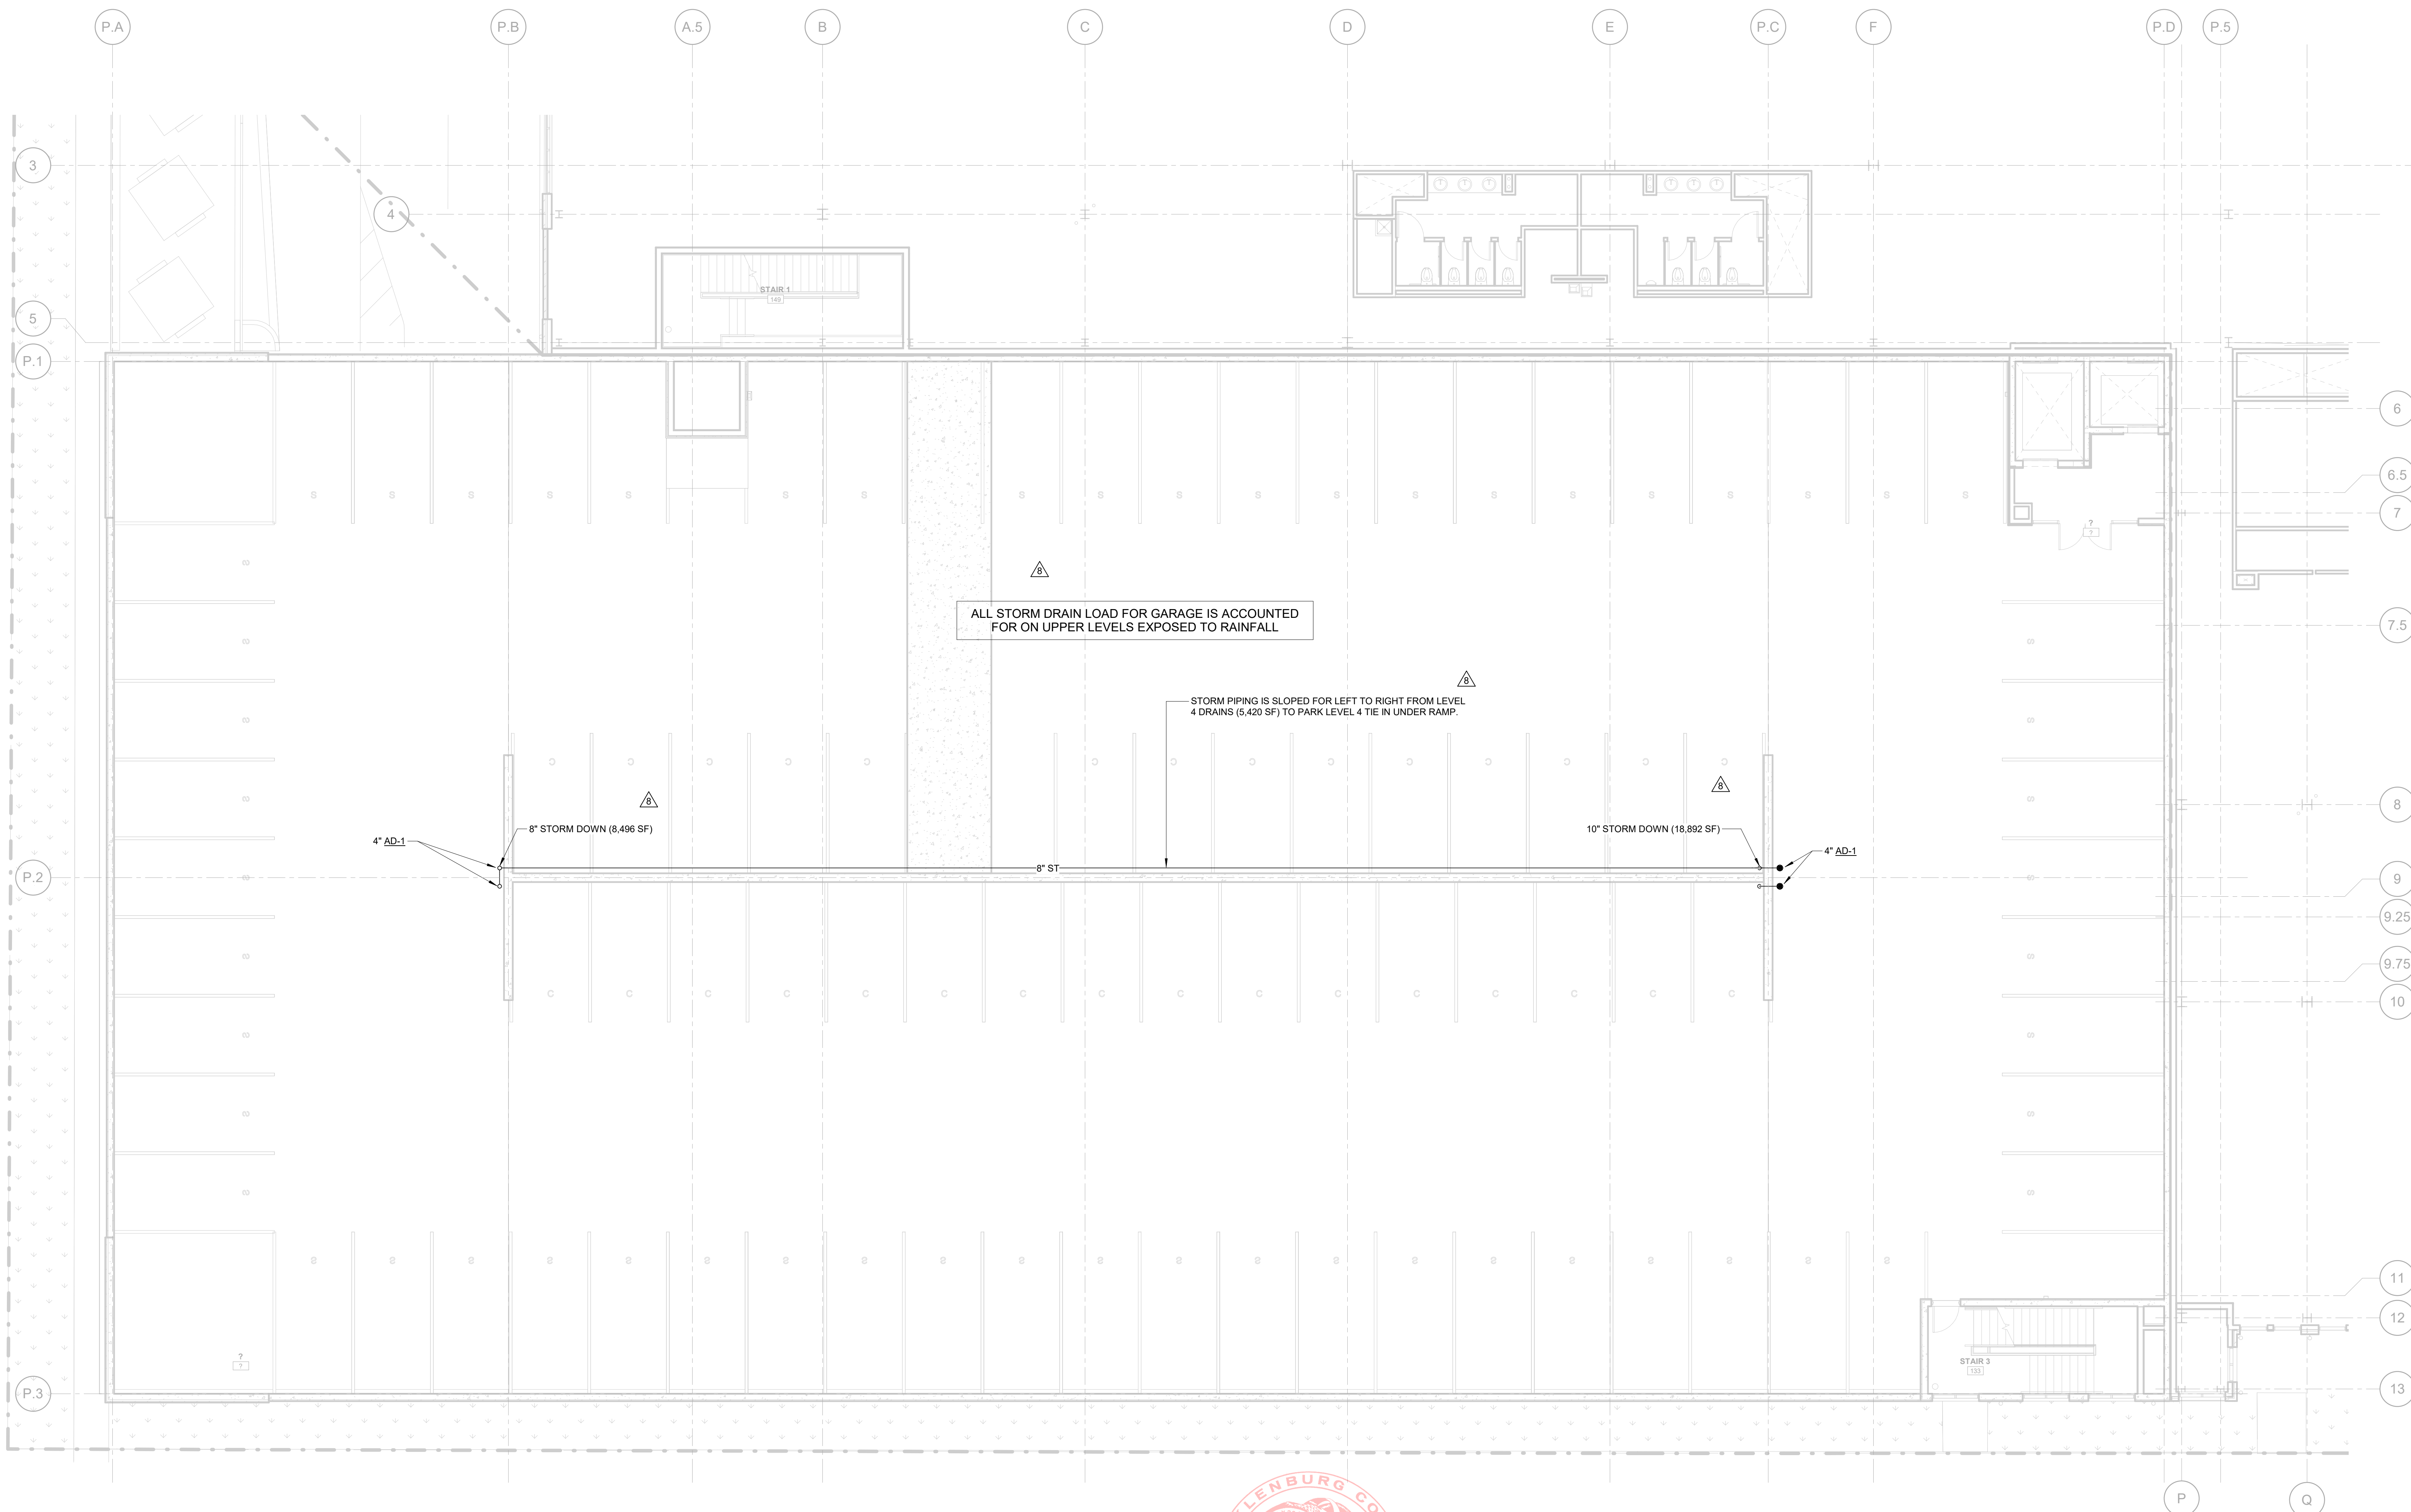

**1** PARK LEVEL 4 - PLUMBING PLAN  
PG1.04 SCALE: 1/8" = 1'-0"

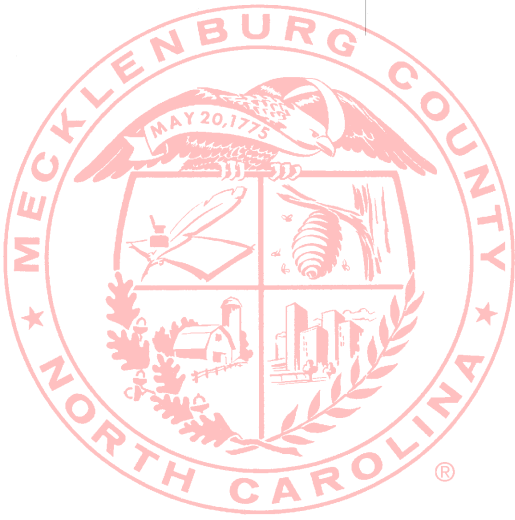

MECKLENBURG COUNTY  
CODE ENFORCEMENT  
The Design In These Construction Documents Have Been Reviewed For Compliance With The State Building Code. It Is The Responsibility Of The Contractor To Construct This Project With Good Engineering Practice And In Compliance With The North Carolina State Building Code.