

ARCHITECT:




505Design Inc.  
508 West 5th Street  
Suite 250  
Charlotte, NC 28202  
t +1 704 348 7000

CONSULTANT:




McVEIGH & MANGUM  
ENGINEERING, INC.  
Charlotte - Jacksonville - Raleigh  
www.McVeighMangum.com  
914 W 5th Street, Charlotte  
North Carolina 28202  
Ph: (704) 547-9002  
email: mail@McVeighMangum.com  
63389

Eng. of Record:  
License No.:

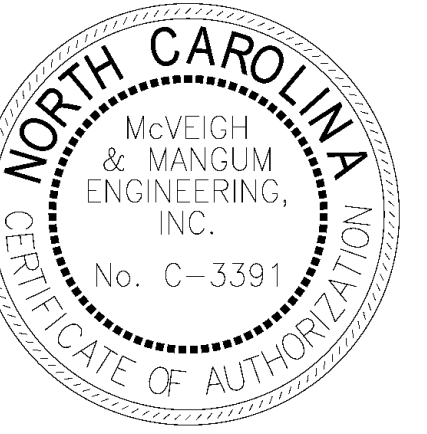

Professional Seals

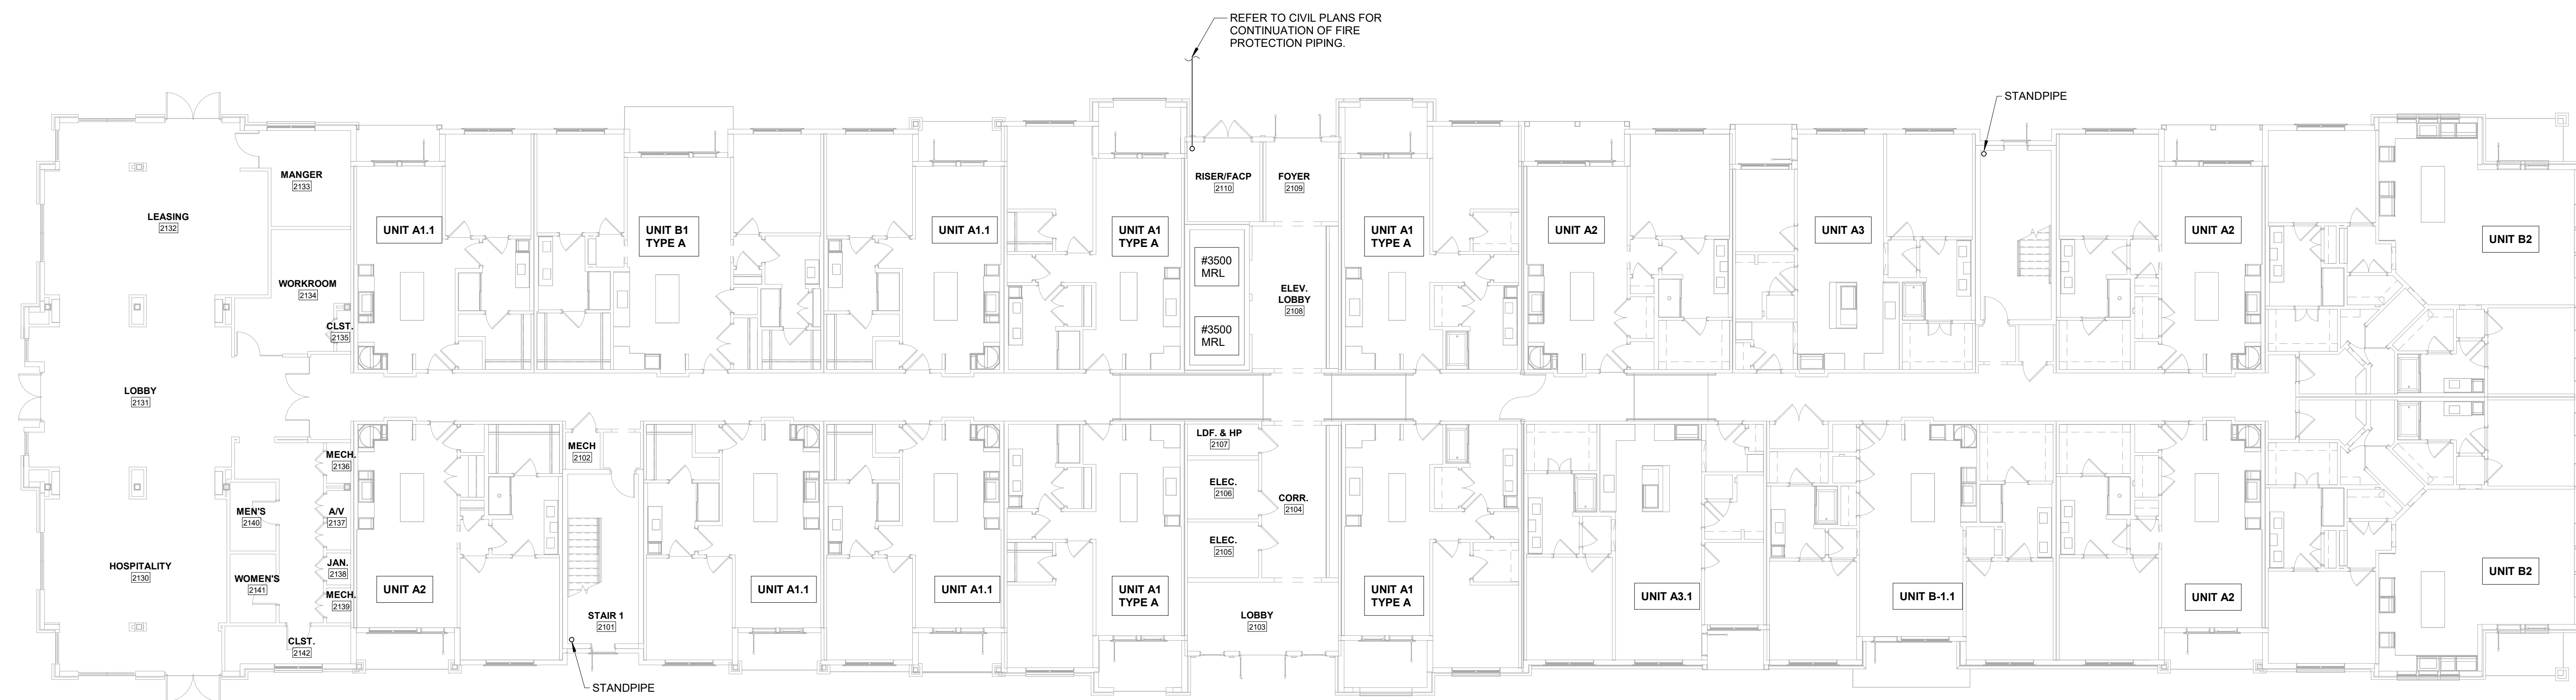

**FLOOR PLAN - BLDG 2 LEVEL 1 - FIRE PROTECTION**

SCALE: 3/32" = 1'-0"

© 505DESIGN 2016

No.	Description	Date

Drawn by: AB      Reviewed by: KR  
Project No: 1263

Issue Date  
DD 04.21.21

Sheet Title  
BUILDING 2 - LEVEL 1  
FLOOR PLAN

Original drawing is 30 x 42. Do not scale contents of this drawing.  
Sheet Number

**FP121**

D -

C -

B -

A -