


ARCHITECT:

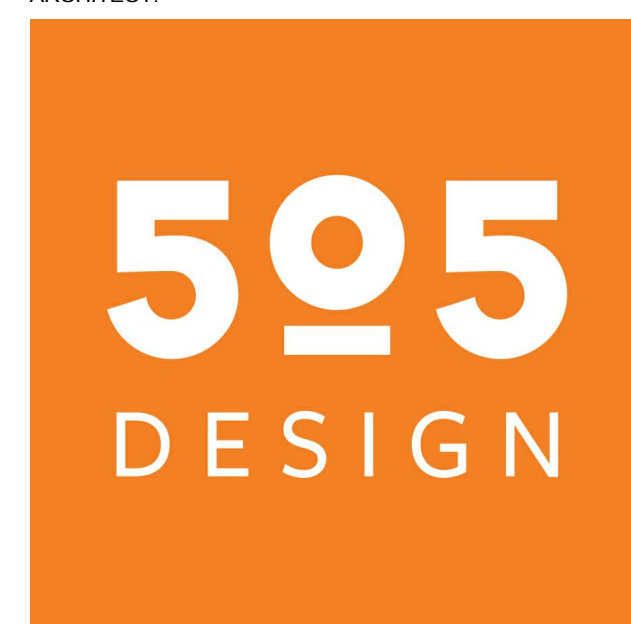


505Design Inc.
508 West 5th Street
Suite 250
Charlotte, NC 28202
t +1 704 348 7000


CONSULTANT:

McVEIGH & MANGUM
ENGINEERING, INC.
Atlanta - Charlotte - Jacksonville - Raleigh
www.McVeighMangum.com
914 W 5th Street, Charlotte,
North Carolina 28202
Ph: (704) 547-9652
email: malig@McVeighMangum.com
©2016

Eng. of Record:
License No.:

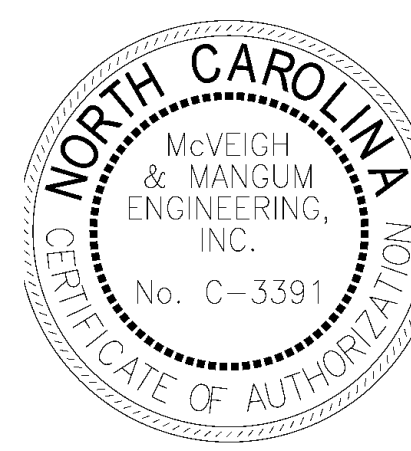

Professional Seals

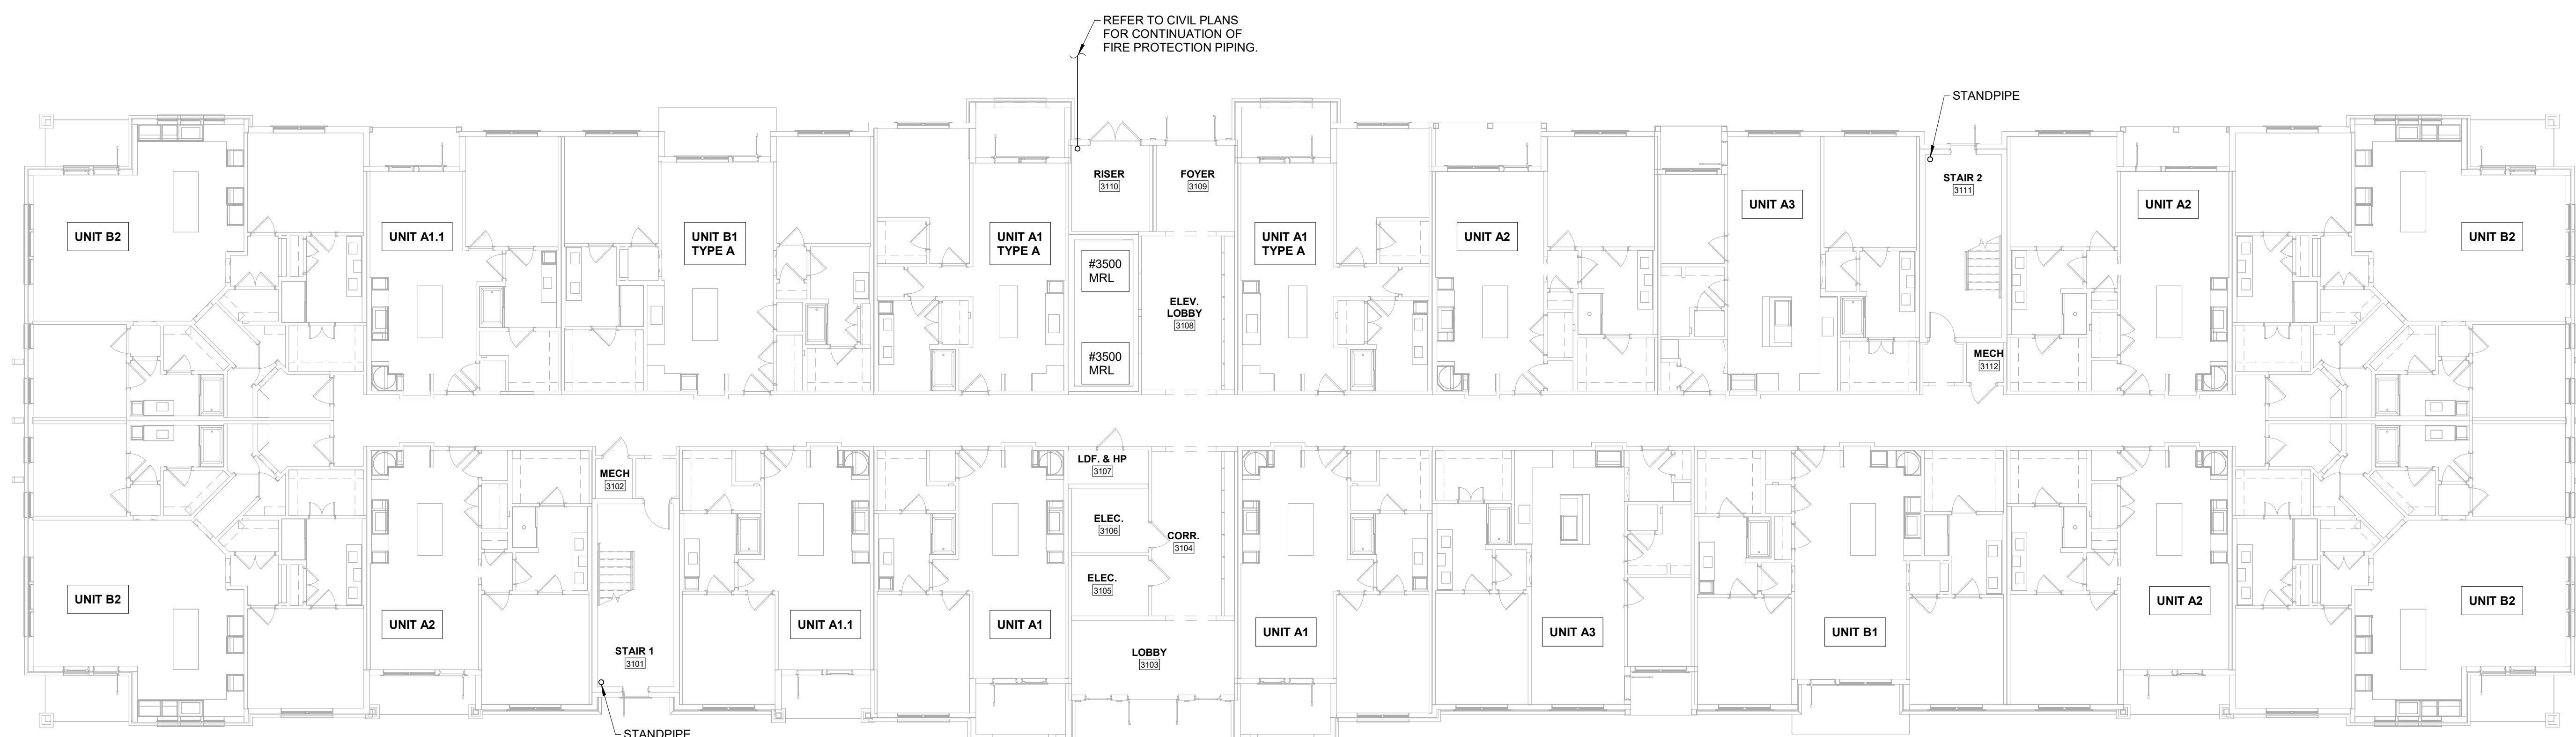

1 FLOOR PLAN - BLDG 3 LEVEL 1 - FIRE PROTECTION
SCALE: 3/32" = 1'-0"

© 505DESIGN 2016

No.	Description	Date

Drawn by: AB Reviewed by: KR

Project No: 1263

Issue Date
DD 04.21.21

Sheet Title
**BUILDING 3 - LEVEL 1
FLOOR PLAN**

Original drawing is 30 x 42. Do not scale contents of this drawing.
Sheet Number

FP131

All reproduction & intellectual property rights reserved © 2021