

# ABBREVIATIONS


AND	EA.	EACH	IBC.	INTERNATIONAL BUILDING CODE	R.	RISER	W/.	WITH
AT	E.A.D.	EMERGENCY AREA DRAIN	I.D.	INSIDE DIAMETER, INTERIOR DESIGN	R&S.	ROD & SHELF	W/O.	WITHOUT
AIR CONDITIONING	EIPS.	EXTERIOR INSULATION & FINISH SYSTEM	IMP.	IMPACT INSULATION CLASS	RAO.	RADIUS	WO.	WOOD
ABOVE FINISH FLOOR	E.J.	EXPANSION JOINT	IN.	INCH	RECIP.	RECEPTIONIST	W.H.	WATER HEATER
AREA DRAIN	ELEC.	ELECTRIC, ELECTRICAL	INSUL.	INSULATION	REF.	REFERENCE, REFRIGERATOR	W.I.C.	WALK-IN CLOSET
AMERICANS WITH DISABILITIES ACT	EL.	ELEVATION (HEIGHT)	INT.	INTERIOR	REINF.	REINFORCEMENT	WIN.	WINDOW
ACOUSTICAL CEILING TILE	ELEV.	ELEVATION (VIEW), ELEVATOR	JAN.	JANITOR	REQD.	REQUIRED	W.W.F.	WELDED WIRE FABRIC
ACOUST.	EMER.	EMERGENCY	J.BOX	JUNCTION BOX	REV.	REVISION/REVISED	XPS	EXTRUDED POLYSTYRENE
AHJ	ENGR.	ENGINEER	JNT.	JUNCTION	RFD.	RADIO-FREQUENCY IDENTIFICATION	YD.	YARD
AHJ	E.P.	EPOXY PAINT	L.V.	LAVATORY	RH	RIGHT HAND		
ALTERNATE	E.P.S.	EXPANDED POLYSTYRENE	L.B.	POUND	RHR.	RIGHT HAND REVERSE		
ALUM.	EQUIP.	EQUIPMENT	LBS.	POUNDS	RM.	ROOM		
ANOD.	E.R.D.	EMERGENCY ROOF DRAIN	EQ.	EQUAL	R.O.	ROUGH OPENING		
APPROX.	E.O.	EQUAL	E.W.C.	ELECTRIC WATER COOLER	R.O.W.	RIGHT OF WAY		
APT.	E.KST.	EXISTING	LH.	LEFT HAND	R.T.G.	RATING		
ARCH.	EXP.	EXPANSION, EXPOSED	LIGHTWT.	LIGHTWEIGHT	SC.	SOLID CORE		
ASSIST.	EXT.	EXTERIOR	LVT.	LUXURY VINYL TILE	SCHED.	SCHEDULE		
ASTM	FACP	FIRE ALARM CONTROL PANEL	MATL.	MATERIAL	SF.	SQUARE FOOT/FEET		
AUTOMATIC	FAC.	FLORIDA BUILDING CODE	MAX.	MAXIMUM	SHT.	SHEET		
AVG.	F.D.	FLOOR DRAIN	MDF.	MEDIUM-DENSITY FIBERBOARD	SHTS.	SHEETS		
BD.	F.D.C.	FIRE DEPARTMENT CONNECTION	MECH.	MECHANICAL	SIM.	SIMILAR		
BLDG.	FDN.	FOUNDATION	MEZZ.	MEZZANINE	S.P.C.S.	SPECIFICATIONS		
BLKS.	F.E.	FIRE EXTINGUISHER	MFG.	MANUFACTURING	SQ.	SQUARE		
BM.	F.E.C.	FIRE EXTINGUISHER CABINET	MFR.	MANUFACTURER	S.S.	STAINLESS STEEL		
BOT./	FFPC	FLORIDA FIRE PREVENTION CODE	MICRO.	MICROWAVE OVEN	STC.	SOUND TRANSMISSION CLASS		
CAB.	FHA	FAIR HOUSING ACT	MIN.	MINIMUM	STOR.	STORAGE		
CABINET	FIN.	FISH	MINS.	MINUTES	STRUCT.	STRUCTURAL		
CALCS.	FLR.	FLOOR	MISC.	MISCELLANEOUS	SUB	SUBCONTRACTOR		
C.I.P.	FNCT.	FUNCTION	MNGR.	MANAGER	T.	TREAD		
C.J.	F.O.F.	FACE OF FINISH	MTND.	MOUNTED	T.	TOP		
C.L.	F.O.P.	FACE OF PRECAST	M.O.	MASONRY OPENING	T&G.	TONGUE & GROOVE		
CLG.	F.O.S.	FACE OF STUD	MTL.	METAL	T.B.D.	TO BE DETERMINED		
CLOS.	F.P.	FIRE PROTECTION	NEC.	NATIONAL ELECTRICAL CODE	TEL.	TELEPHONE		
CLR.	FRT	FIRE-RETARDANT-TREATED	N.I.C.	NOT IN CONTRACT	TEMP.	TEMPORARY, TEMPERED, TEMPERATURE		
CMU	FT.	FEET	NO. (R)	NUMBER	THRU	THROUGH		
COL.	FTG.	FOOTING	NOM.	NOMINAL	T.O.C.	TOP OF CONCRETE OR CURB ASSOCIATION		
COMM.	FURN.	FURNITURE	N.F.P.A.	NATIONAL FIRE PROTECTION	T.O.F.	TOP OF FOUNDATION		
CONC.	GA.	GAGE OR GAUGE	N.T.S.	NOT TO SCALE	T.O.S.	TOP OF STEEL		
CONF.	GALV.	GALVANIZED	O.C.	ON CENTER	T.P.O.	THERMOPLASTIC POLYOLEFIN		
CONSTR.	G.C.	GENERAL CONTRACTOR	O.D.	OUTSIDE DIAMETER	TYP.	TYPICAL		
CONT.	GFCI	GROUND FAULT CIRCUIT INTERRUPT	OFF.	OFFICE	U.C.	UNDER-COUNTER		
COORD.	GFR	GLASS FIBER REINFORCED	OPNS.	OPENINGS	UL.	UNDERWRITERS LABORATORIES		
CORR.	GFR	GLASS FIBER REINFORCED	OPP.	OPPOSITE	UNFIN.	UNFINISHED		
CPT.	GFRG	GLASS FIBER REINFORCED	OSB	ORIENTED STRAND BOARD	UN.F.	UNLESS NOTED OTHERWISE		
CT	GL.	GLASS	PLAM.	PLASTIC LAMINATE	U.N.O.	UNLESS NOTED OTHERWISE		
CU.	GYP.	GYPSPUM	PLYWD.	PLYWOOD	VBC.	VINYL BASE (COVERED)		
DEPT.	H.B.	HOSE BIBB	POLYISO.	POLYISOCYANURATE	VBS.	VINYL BASE (STRAIGHT)		
DET.	HDW.	HARDWARE	PREFAB.	PREFABRICATED	VCT.	VINYL COMPOSITION TILE		
D.F.	HM.	HOLLOW METAL (IN SCHEDULES)	PREP.	PREPARATION	VERT.	VERTICAL		
DIA.	H.M.	HOLLOW METAL	P.S.F.	POUND/SQ. FOOT	VEST.	VESTIBULE		
DIM.	DN.	DOWN	P.S.I.	POUND/SQ. INCH	V.I.F.	VERIFY IN FIELD		
DIMS.	HR.	HOUR	P.T.	PRESSURE-TREATED	VVC.	VINYL WALL COVERING		
DISP.	HT.	HEIGHT	PTD.	PAINTED				
DN.	H.V.A.C.	HEATING VENTILATION & AIR CONDITIONING						
D.S.								
DWG.								
DWG.								

# DRAWING INDEX

SHEET #	SHEET NAME	Sheet Issue Date	Current Revision
<b>0. GENERAL</b>			
G0.00	COVER PAGE	2021-07-30	
G0.01	DRAWING INDEX, ABBREVIATIONS, DRAWING SYMBOLS, AND DEFERRED SUBMITTALS	2021-07-30	
G0.04	CODE REQUIREMENTS, OPENNESS CALCULATIONS, AND BUILDING/PARKING STATS	2021-07-30	
G1.01	ARCHITECTURAL SITE PLAN	2021-07-30	
G2.01	LIFE SAFETY PLANS	2021-07-30	
G2.02	LIFE SAFETY PLANS	2021-07-30	
G2.03	LIFE SAFETY PLANS	2021-07-30	
G2.04	LIFE SAFETY PLANS	2021-07-30	
8			
<b>1. CIVIL - FOR REFERENCE ONLY</b>			
C000	COVER SHEET	2021-07-30	
C001	GENERAL NOTES	2021-07-30	
C200	DEMOLITION PLAN	2021-07-30	
C300	SITE PLAN	2021-07-30	
C400	GRADING DRAINAGE PLAN	2021-07-30	
C401	ENLARGED GRADING PLAN	2021-07-30	
C402	CROSS SECTIONS	2021-07-30	
C500	UTILITY PLAN	2021-07-30	
C600	WATER AND WASTEWATER DETAILS	2021-07-30	
C601	WATER AND WASTEWATER DETAILS	2021-07-30	
C700	ON-SITE PAVING DETAILS	2021-07-30	
C701	ON-SITE PAVING DETAILS	2021-07-30	
C702	ON-SITE PAVING DETAILS	2021-07-30	
S100	BOUNDARY TOPOGRAPHIC AND TREE SURVEY	2021-07-30	
14			
<b>2. STRUCTURAL</b>			
S0.01	GENERAL NOTES AND DESIGN CRITERIA	2021-07-30	
S0.03	DESIGN LOADS SUMMARY	2021-02-12	
S1.01	FOUNDATION SCHEDULE AND DETAILS	2021-02-12	
S1.02	PILE LOCATION PLAN	2021-02-12	
S2.01	PILE DETAILS	2021-02-12	
S3.01	FOUNDATION PLAN	2021-02-12	
S3.02	ENLARGED FOUNDATION PLANS	2021-02-12	
S4.01	FOUNDATION DETAILS	2021-02-12	
S5.01	PRECAST TO FOUNDATION DETAILS	2021-02-12	
S10.01	LEVEL 1 FRAMING PLAN	2021-07-30	
S10.02	LEVEL 2 FRAMING PLAN	2021-07-30	
S10.03	LEVEL 3 FRAMING PLAN	2021-07-30	
S10.04	LEVEL 4 FRAMING PLAN	2021-07-30	
S10.05	LEVEL 5 FRAMING PLAN	2021-07-30	
S10.06	LEVEL 6 FRAMING PLAN	2021-07-30	
S10.07	LEVEL 7 FRAMING PLAN	2021-07-30	
S10.08	LEVEL 8 FRAMING PLAN	2021-07-30	
S21.01	CAST IN PLACE CONCRETE DETAILS	2021-02-12	
S22.01	CAST IN PLACE CONCRETE TOPPING PLANS	2021-02-12	
S23.01	CAST IN PLACE CONCRETE TOPPING DETAILS	2021-02-12	
S30.01	CMU PLANS	2021-02-12	
S31.01	CMU ELEVATIONS	2021-02-12	
S32.01	CMU DETAILS	2021-02-12	
S40.01	PRECAST DETAILS	2021-02-12	
S50.01	MISCELLANEOUS METAL PLANS	2021-02-12	
S51.01	MISCELLANEOUS METAL DETAILS	2021-02-12	
25			
<b>3. ARCHITECTURAL</b>			
A10.01	LEVEL 1 FLOOR PLAN	2021-07-30	
A10.02	LEVEL 2 FLOOR PLAN	2021-07-30	
A10.03	LEVEL 3 FLOOR PLAN	2021-07-30	
A10.04	LEVEL 4 FLOOR PLAN	2021-07-30	
A10.05	LEVEL 5 FLOOR PLAN	2021-07-30	
A10.06	LEVEL 6 FLOOR PLAN	2021-07-30	
A10.07	LEVEL 7 FLOOR PLAN	2021-07-30	
A10.08	LEVEL 8 FLOOR PLAN	2021-07-30	
A32.01	ENLARGED FLOOR PLANS	2021-07-30	
A32.02	ENLARGED FLOOR PLANS	2021-07-30	
A32.03	TRASH COMPACTOR PLAN AND ELEVATIONS	2021-07-30	
A39.01	FINISH SCHEDULE	2021-07-30	
A40.01	EXTERIOR BUILDING ELEVATIONS	2021-07-30	
A40.02	EXTERIOR BUILDING ELEVATIONS	2021-07-30	
A50.01	BUILDING SECTIONS	2021-07-30	
A60.50	CHAIN LINK FENCE DETAILS	2021-07-30	
A62.01	WATERPROOFING DETAILS	2021-07-30	
A62.25	CAULKING DETAILS	2021-07-30	
A67.01	MISCELLANEOUS DETAILS	2021-07-30	
A70.01	WALL PARTITION DETAILS	2021-07-30	
A80.01	DOOR SCHEDULE, ELEVATIONS, FRAMES, AND NOTES	2021-07-30	
AD10.01	EXISTING PARKING GARAGE DEMOLITION PLANS	2021-07-30	
AD10.02	EXISTING PARKING GARAGE DEMOLITION PLANS	2021-07-30	
AD10.03	EXISTING PARKING GARAGE DEMOLITION PLANS	2021-07-30	
AD10.04	EXISTING PARKING GARAGE DEMOLITION PLANS	2021-07-30	

SHEET #	SHEET NAME	Sheet Issue Date	Current Revision
25			
<b>5. ELECTRICAL</b>			
E00.01	ELECTRICAL LEGEND AND SYMBOLS	2021-07-30	1
E00.02	LIGHTING FIXTURE SCHEDULE	2021-07-30	1
E10.01	ELECTRICAL SITE PLAN	2021-07-30	1
E20.01L	LEVEL 1 - LIGHTING PLAN	2021-07-30	1
E20.01P	LEVEL 1 - POWER PLAN	2021-07-30	1
E20.01S	LEVEL 1 - SYSTEMS PLAN	2021-07-30	1
E20.02L	LEVEL 2 - LIGHTING PLAN	2021-07-30	1
E20.02P	LEVEL 2 - POWER PLAN	2021-07-30	1
E20.02S	LEVEL 2 - SYSTEMS PLAN	2021-07-30	1
E20.03L	LEVEL 3 - LIGHTING PLAN	2021-07-30	1
E20.03P	LEVEL 3 - POWER PLAN	2021-07-30	1
E20.03S	LEVEL 3 - SYSTEMS PLAN	2021-07-30	1
E20.04L	LEVEL 4 - LIGHTING PLAN	2021-07-30	1
E20.04P	LEVEL 4 - POWER PLAN	2021-07-30	1
E20.04S	LEVEL 4 - SYSTEMS PLAN	2021-07-30	1
E20.05L	LEVEL 5 - LIGHTING PLAN	2021-07-30	1
E20.05P	LEVEL 5 - POWER PLAN	2021-07-30	1
E20.05S	LEVEL 5 - SYSTEMS PLAN	2021-07-30	1
E20.06L	LEVEL 6 - LIGHTING PLAN	2021-07-30	1
E20.06P	LEVEL 6 - POWER PLAN	2021-07-30	1
E20.06S	LEVEL 6 - SYSTEMS PLAN	2021-07-30	1
E20.07L	LEVEL 7 - LIGHTING PLAN	2021-07-30	1
E20.07P	LEVEL 7 - POWER PLAN	2021-07-30	1
E20.07S	LEVEL 7 - SYSTEMS PLAN	2021-07-30	1
E20.08L	LEVEL 8 - LIGHTING PLAN	2021-07-30	1
E20.08P	LEVEL 8 - POWER PLAN	2021-07-30	1
E20.08S	LEVEL 8 - SYSTEMS PLAN	2021-07-30	1
E20.09L	T/ROOF - LIGHTING PLAN	2021-07-30	1
E20.09P	T/ROOF - POWER PLAN	2021-07-30	1
E20.09S	T/ROOF - SYSTEMS PLAN	2021-07-30	1
E50.00	ELECTRICAL RISER LEGENDS AND DETAILS		
E50.01	HOUSE RISER DIAGRAM		
E60.00	LOAD CALCULATIONS		
E60.01	HOUSE PANEL SCHEDULES		
14			
<b>6. PLUMBING</b>			
P00.00	PLUMBING CODES, NOTES AND ABBREVIATIONS	2021-07-30	
P10.01	PLUMBING LEVEL 1 FLOOR PLAN	2021-07-30	
P10.02	PLUMBING LEVEL 2 FLOOR PLAN	2021-07-30	
P10.03	PLUMBING LEVEL 3 FLOOR PLAN	2021-07-30	
P10.04	PLUMBING LEVEL 4 FLOOR PLAN	2021-07-30	
P10.05	PLUMBING LEVEL 5 FLOOR PLAN	2021-07-30	
P10.06	PLUMBING LEVEL 6 FLOOR PLAN	2021-07-30	
P10.07	PLUMBING LEVEL 7 FLOOR PLAN	2021-07-30	
P10.08	PLUMBING LEVEL 8 FLOOR PLAN	2021-07-30	
9			
<b>7. FIRE PROTECTION</b>			
FP00.01	FIRE PROTECTION REFERENCE SITE PLAN	2021-07-30	
FP00.02	FIRE PROTECTION DESIGN INTENT NOTES	2021-07-30	
FP10.01	LEVEL 1 FIRE PROTECTION PLAN	2021-07-30	
FP10.02	LEVEL 2 FIRE PROTECTION PLAN	2021-07-30	
FP10.03	LEVEL 3 FIRE PROTECTION PLAN	2021-07-30	
FP10.04	LEVEL 4 FIRE PROTECTION PLAN	2021-07-30	
FP10.05	LEVEL 5 FIRE PROTECTION PLAN	2021-07-30	
FP10.06	LEVEL 6 FIRE PROTECTION PLAN	2021-07-30	
FP10.07	LEVEL 7 FIRE PROTECTION PLAN	2021-07-30	
FP10.08	LEVEL 8 FIRE PROTECTION PLAN	2021-07-30	
10			
<small>REFER TO APARTMENT SET FOR LANDSCAPE / HARDSCAPE SHEETS</small>			

# DRAWING SYMBOLS

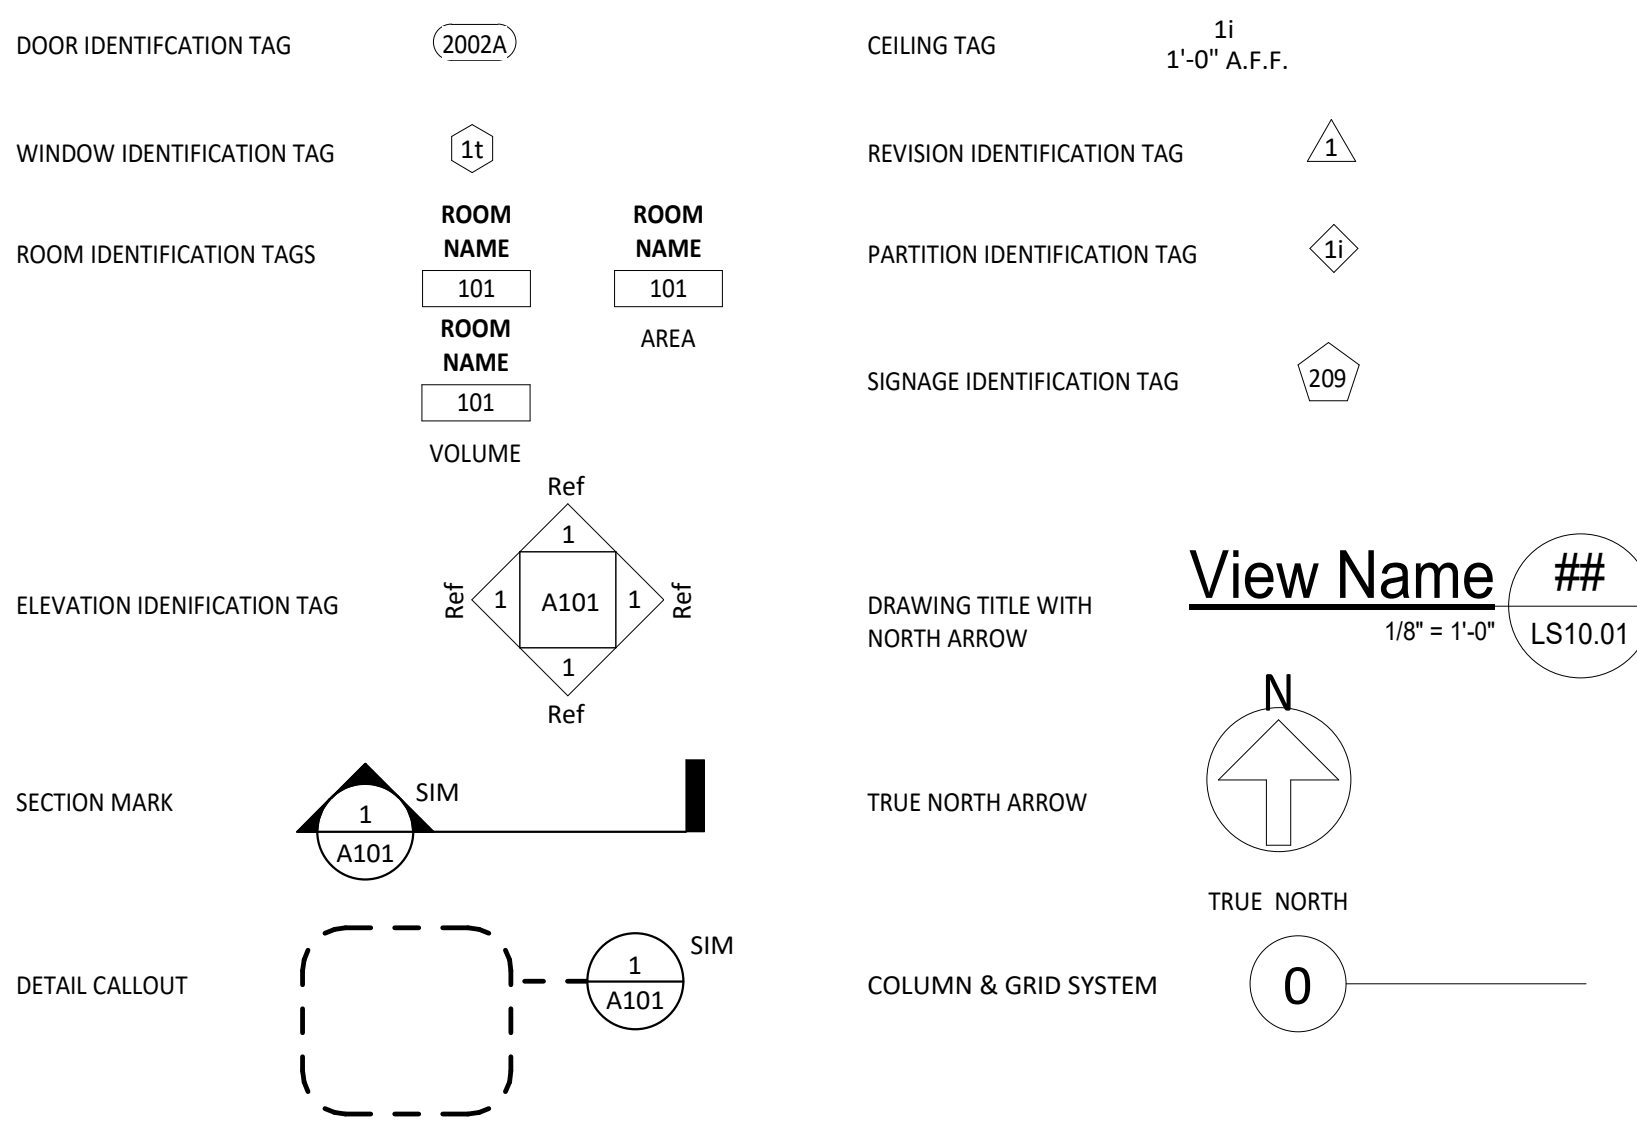

# DEFERRED SUBMITTALS

SIGNED & SEALED SHOP DRAWINGS (AOR / EOR REVIEWED), TO BE SUBMITTED AT LATER DATE FOR PERMIT REVIEW PRIOR TO INSPECTION:

- EXTERIOR DOORS (NOA OR FLORIDA PRODUCT APPROVAL)
- FIRE ALARM SYSTEM

REV.	DATE	DESCRIPTION
	2020-12-04	100% SCHEMATIC DESIGN
	2021-01-20	SPK. CONSET. DOCUMENTS

CAR 0117

PROJECT NUMBER: 20008  
 DRAWN BY: CHESTCAR  
 CHECKED BY: KEDINGER

G0.01