



mgc architecture

216.520.1551 216.520.1567  
7100 E. Pleasant Valley Rd., Suite 320, Cleveland, OH 44131

Seal:

A Project for:

# EARTH FARE

STORE #ORL 580  
CRESCENT LUCERNE  
725 MAIN LANE  
ORLANDO, FL

Client:

CRESCENT COMMUNITIES  
3340 PEACHTREE ROAD NE,  
SUITE 1560  
ATLANTA, GA 30326

Revisions:

BULLETIN 7	09-24-18
BULLETIN 4	03-29-18
ISSUED FOR CONSTRUCTION	04-04-17
BID / PERMIT	10-28-16
No. Description	Date
Project No.:	16.339.10
Drawn By:	JW
Reviewed By:	SEJ
Scale:	AS NOTED
Date:	10-28-16
Filename:	16339_A103
Sheet Title:	

## REFLECTED CEILING PLAN

Sheet #:

A103

© MCG ARCHITECTS 2016 ALL RIGHTS RESERVED

### REFLECTED CEILING PLAN LEGEND


- 8" x 4" LIGHT FIXTURES, SEE ELECTRICAL DWGS.
- 14" x 4" LIGHT FIXTURES, SEE ELECTRICAL DWGS.
- 2x4" RECESSED LIGHT FIXTURES, SEE ELECTRICAL DWGS.
- 6" RECESSED CAN LIGHTS, SEE ELECTRICAL DWGS.
- TRACK LIGHTING, SEE ELECTRICAL DRAWINGS
- 1" x 4" LIGHT FIXTURES, SEE ELECTRICAL DWGS.
- BULKHEAD, COORDINATE W/ SHEET A104
- CEILING GRID AND TILE, COORDINATE W/ SHEET A702
- EVAP
- EVAPORATOR COIL, COORD. LOCATION W/ REFRIGERATION CONTRACTOR & VERIFY LIGHTING LAYOUT
- HVAC EQUIPMENT, SEE MECHANICAL DRAWINGS

REFLECT. CEILING PLN. LEGEND SCALE NONE 02

### GENERAL NOTES

1. TRACK LIGHTING IS SHOWN STRICTLY FOR DIAGRAMMATICAL PURPOSES. SEE ELECTRICAL DRAWINGS FOR FURTHER INFORMATION.
2. SEE ELECTRICAL DRAWINGS FOR LIGHT FIXTURE SCHEDULES AND DIMENSIONS
3. PROVIDE SOUND BATT INSULATION ABOVE CEILING IN SPACES AS NOTED:  
WOMEN'S RESTROOM 120  
MEN'S RESTROOM 121

GENERAL NOTES SCALE NONE 03

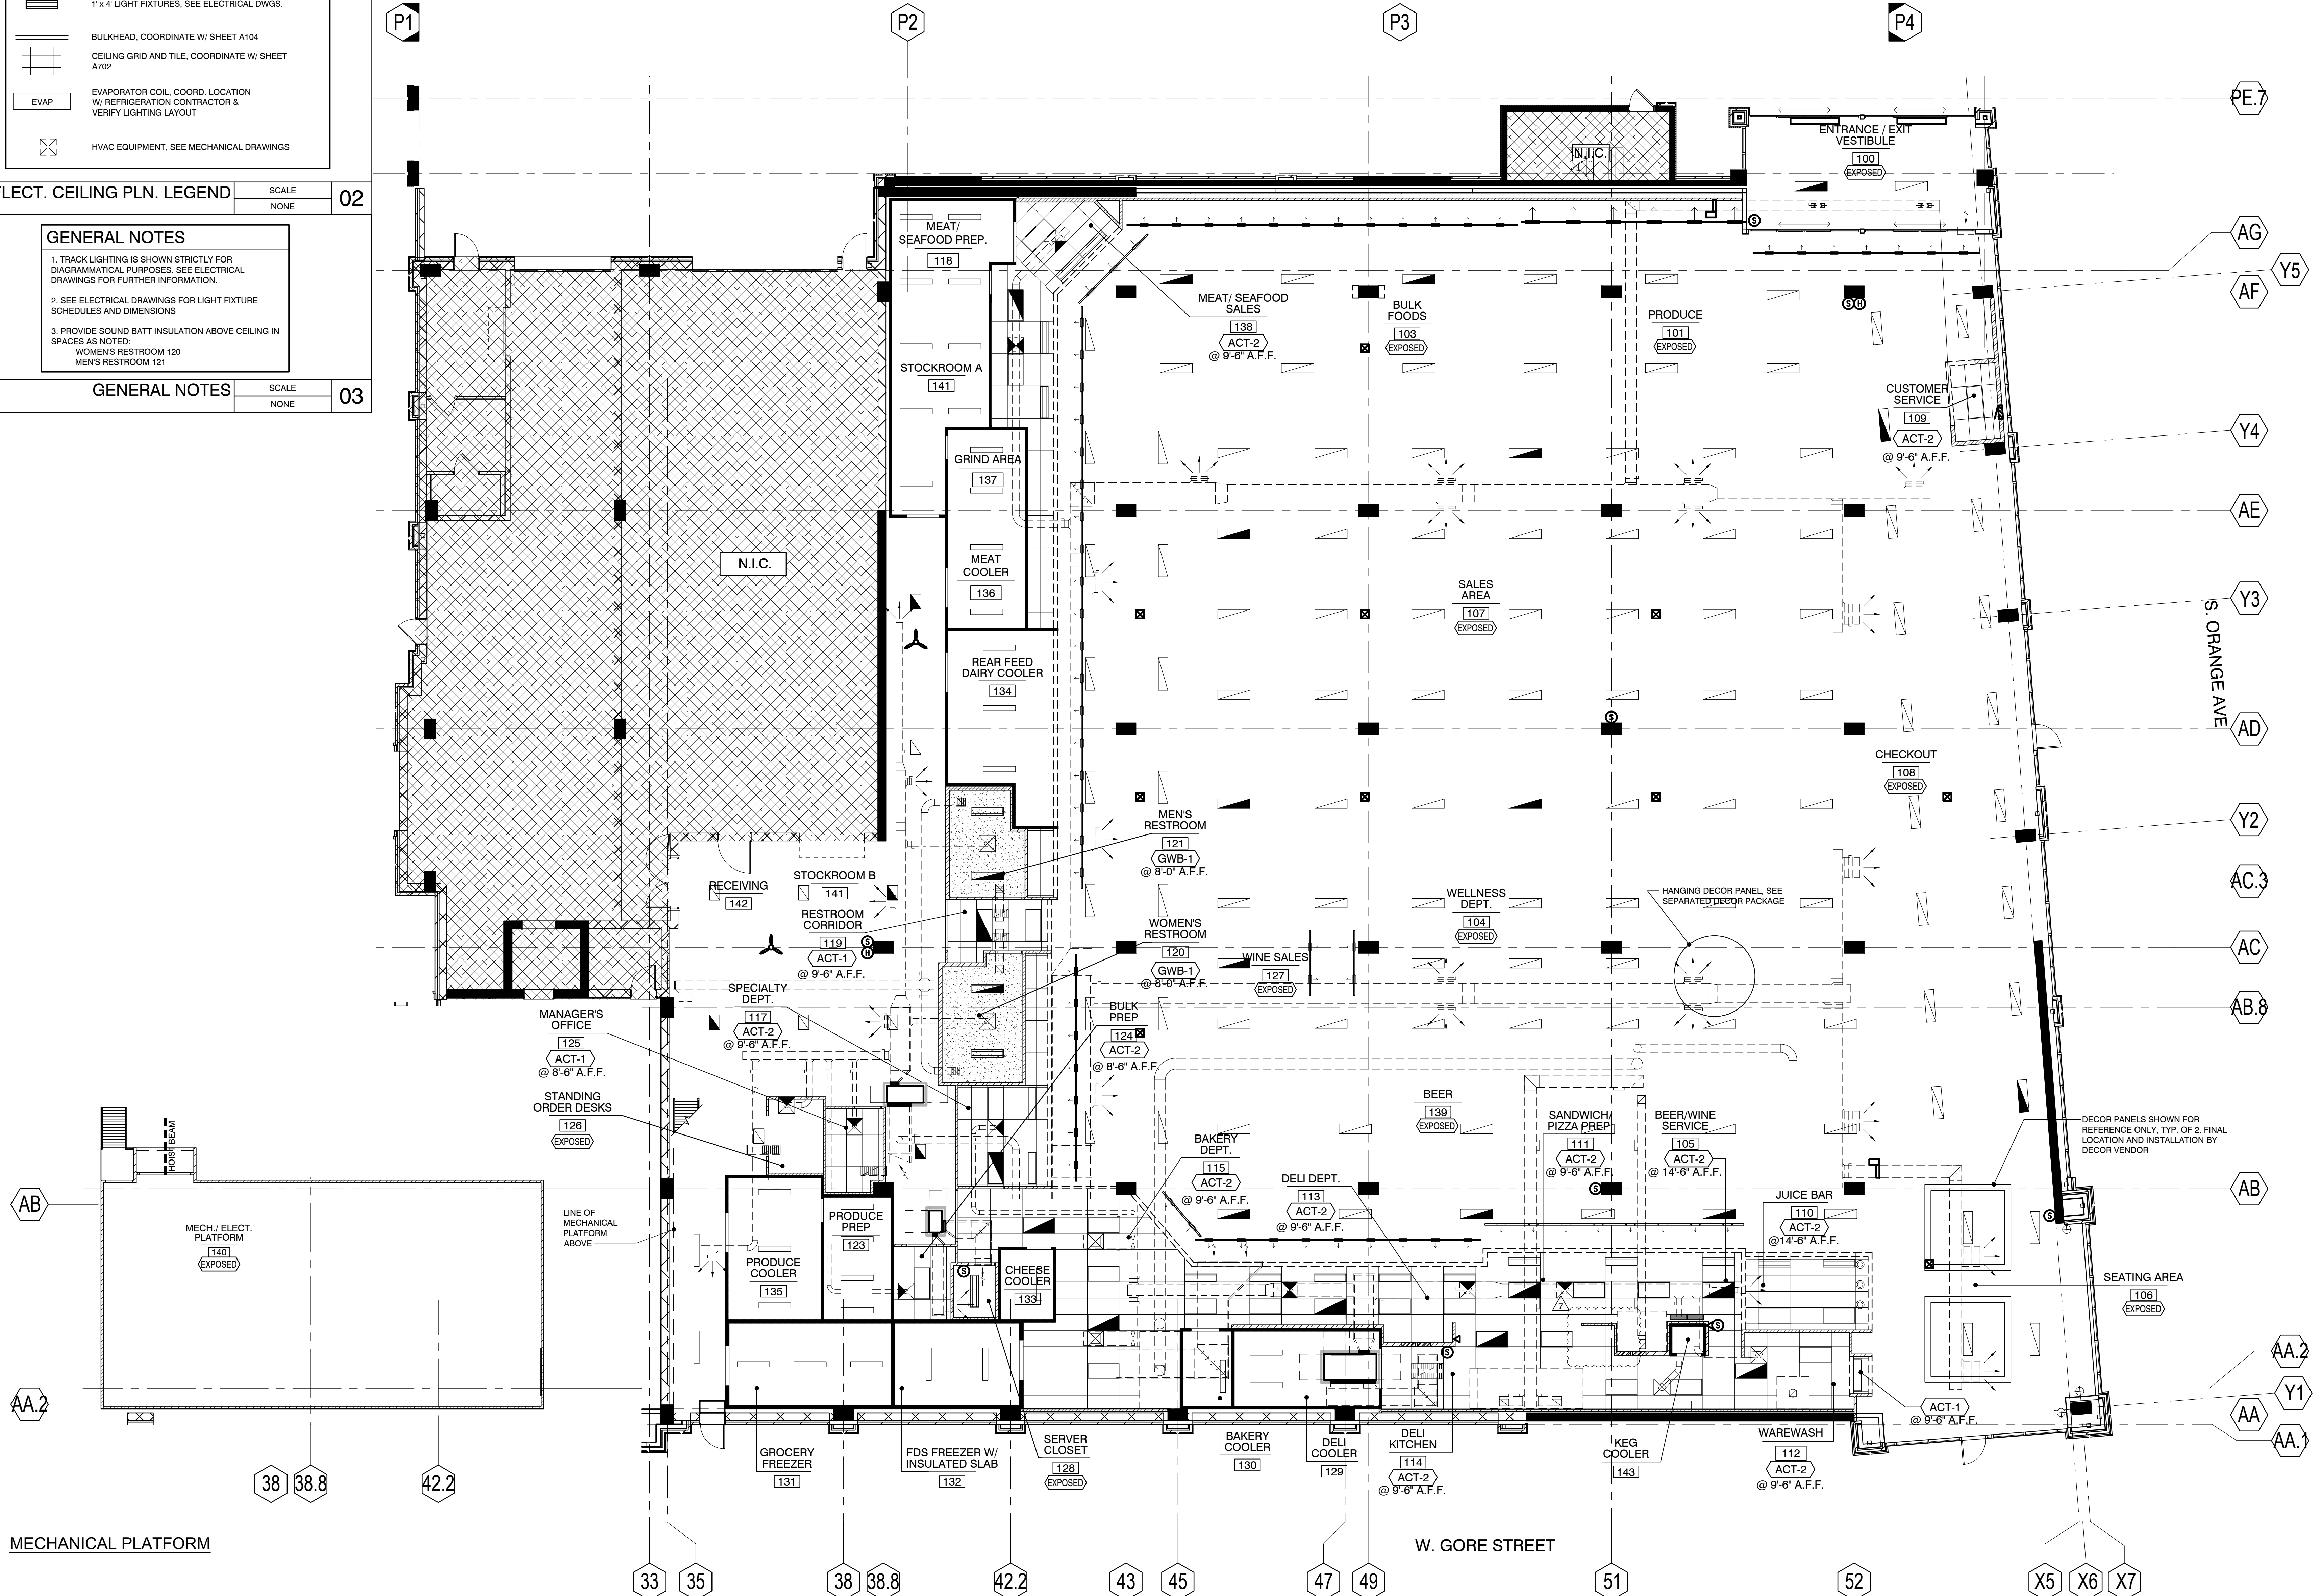

MECHANICAL PLATFORM

W. GORE STREET

FLOOR PLAN SCALE 1/8" = 1'-0" 01