



PROJECT:	217055
DATE:	10.27.2017
REVISIONS:	DATE

DRAWN BY:	Author
CHECKED BY:	Checker


**BLDG TYPE 1 - FLOOR PLANS**

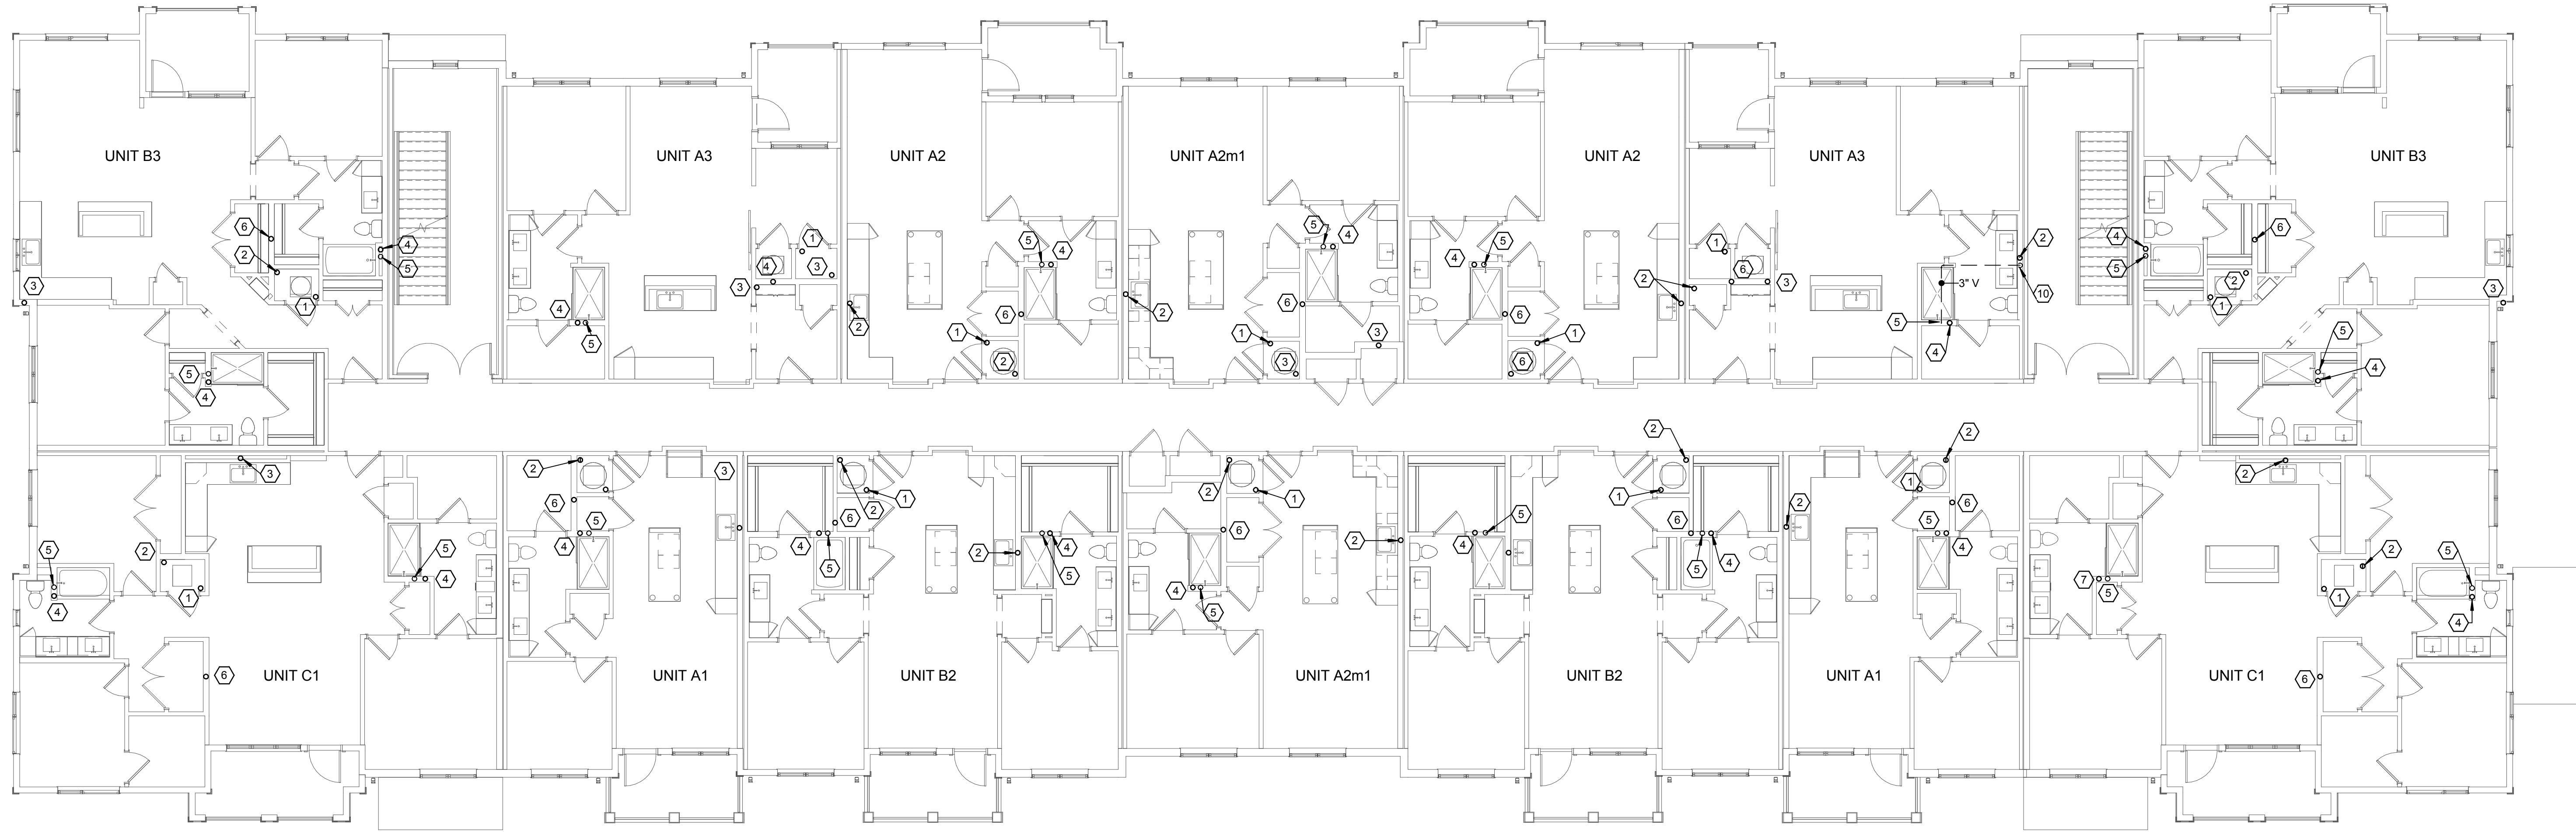

**2 BLDG TYPE 1 - SECOND/THIRD FLOOR PLANS - PLUMBING**  
PT.11 SCALE: 1/8" = 1'-0"

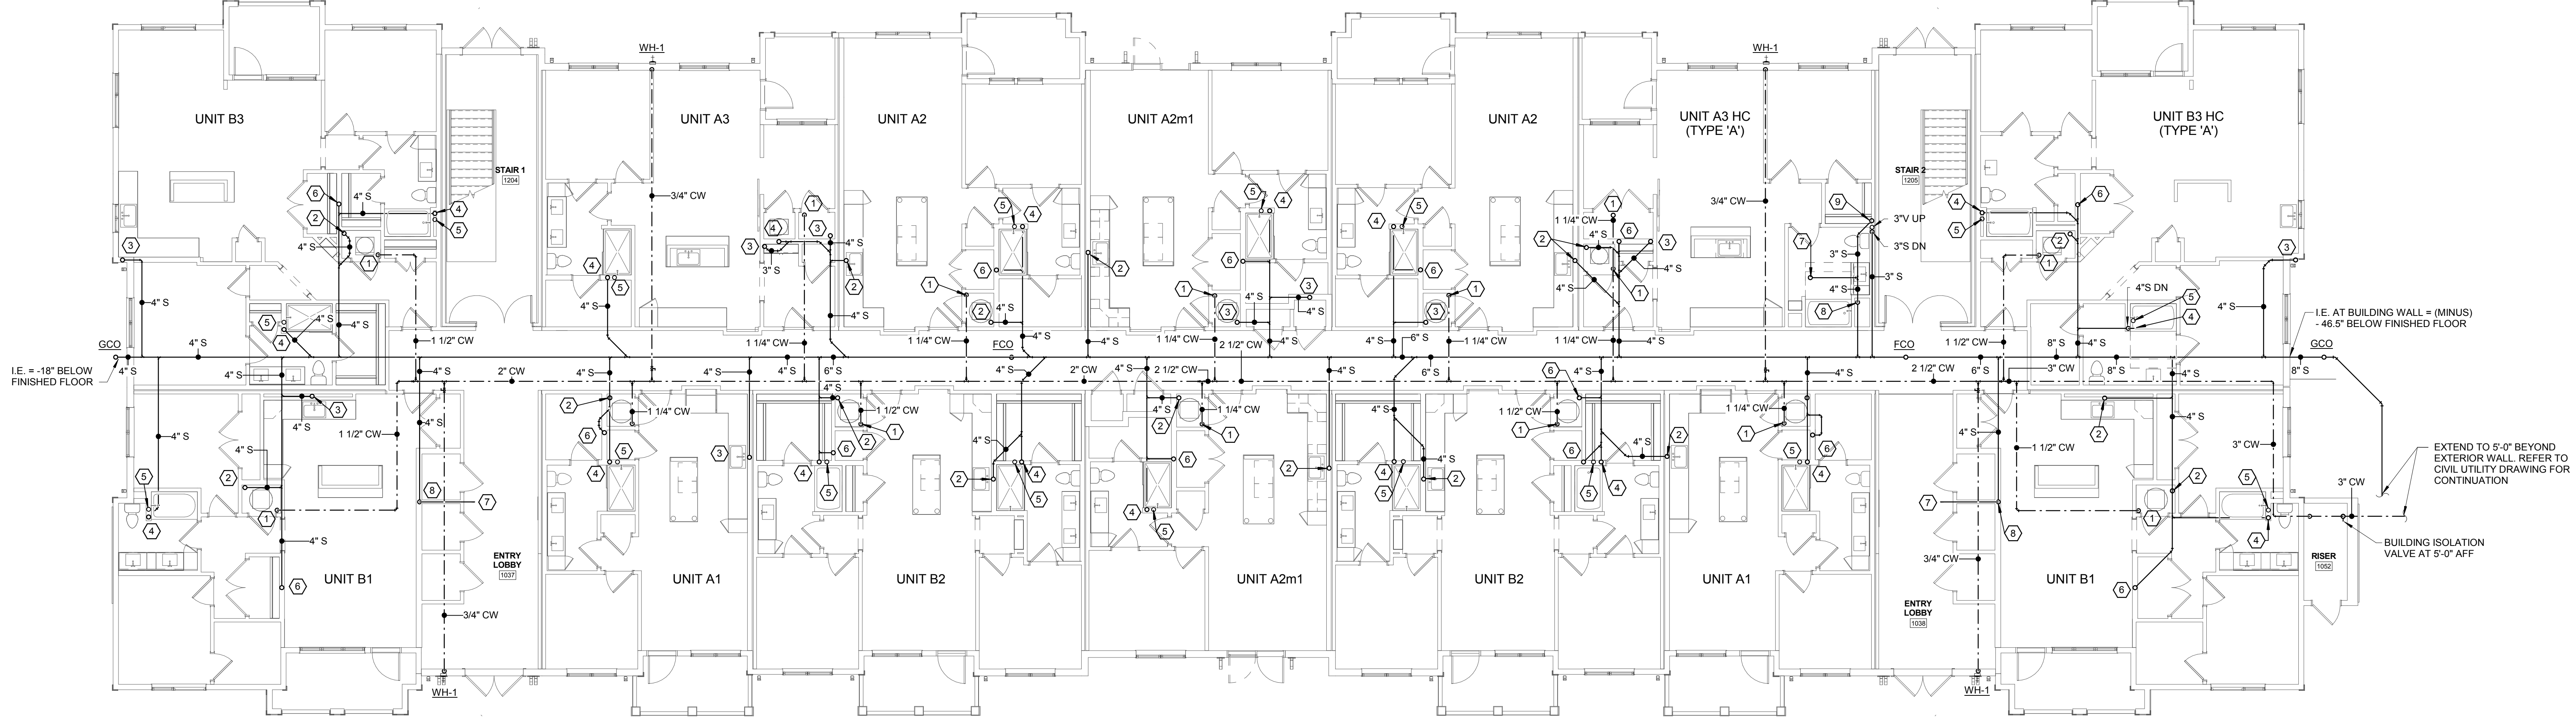


**1 BLDG TYPE 1 - FIRST FLOOR PLAN - PLUMBING**  
PT.11 SCALE: 1/8" = 1'-0"

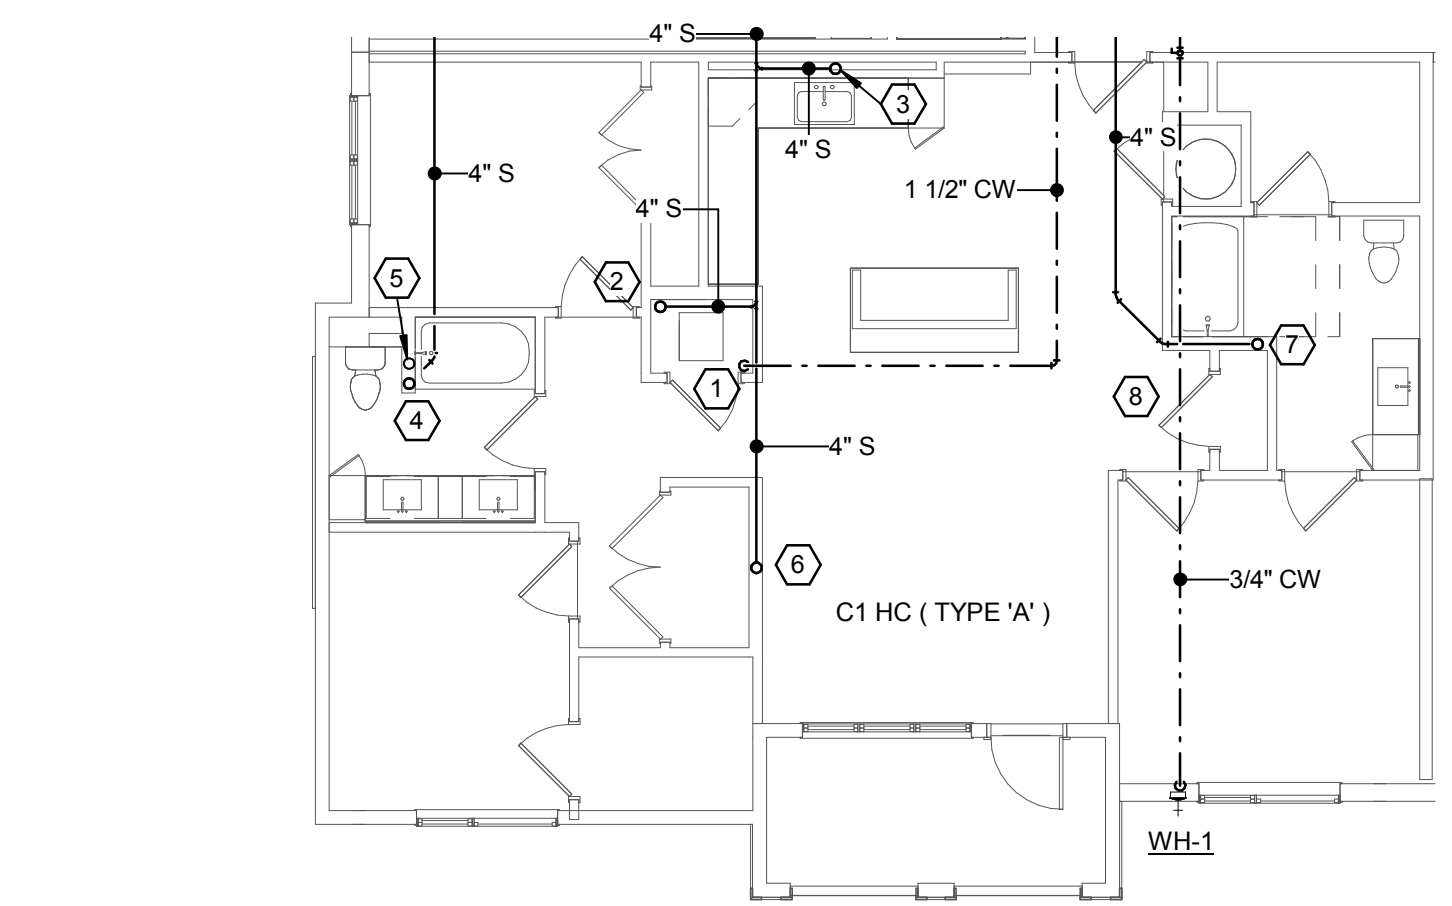

**1A BLDG TYPE 1(ALT) - FIRST FLOOR PLAN (PARTIAL) - PLUMBING**  
PT.11 SCALE: 1/8" = 1'-0"

- KEYNOTES TO PLAN:**
- 1 COLD WATER RISER. SEE WATER RISER DIAGRAM FOR PIPE SIZE.
  - 2 3" WASTE STACK VENT (WSV).
  - 3 3" WASTE STACK.
  - 4 4" SANITARY STACK.
  - 5 3" VENT STACK.
  - 6 4" WASTE STACK VENT (WSV).
  - 7 4" SANITARY PIPE DOWN FROM ABOVE.
  - 8 4" SANITARY PIPE DOWN.
  - 9 3" SANITARY PIPE DOWN FROM ABOVE.
  - 10 3" VENT UP FROM BELOW.

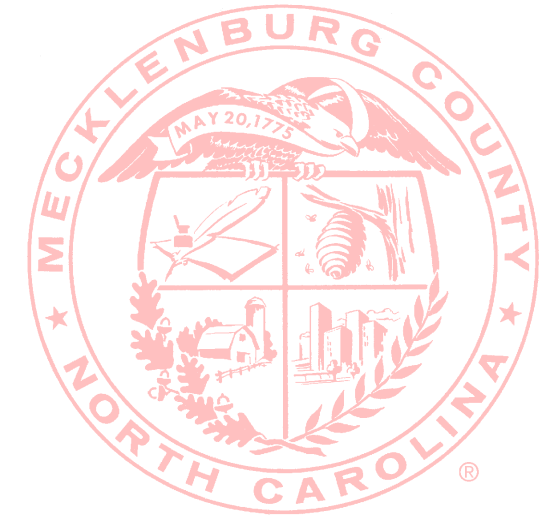

MECKLENBURG COUNTY  
CODE ENFORCEMENT  
The Design In These Construction Documents Have Been Reviewed For Compliance With The State Building Code. It Is The Responsibility Of The Contractor To Construct This Project With Good Engineering Practice And In Accordance With The State Building Code.



PROJECT: 217055 - VILLAGE AT RESEARCH PARK - 3RD FLOOR - 10/27/17

DATE PLOTTED: 10/27/17 10:27:17 AM. THIS DRAWING IS THE PROPERTY OF CLINE DESIGN ASSOCIATES, INC. ANY REUSE OR REPRODUCTION OF THIS DRAWING WITHOUT THE WRITTEN PERMISSION OF CLINE DESIGN ASSOCIATES, INC. IS PROHIBITED.