



2 BLDG TYPE 2 - SECOND FLOOR PLAN - PLUMBING
SCALE: 1/8" = 1'-0"

BLDG TYPE 2

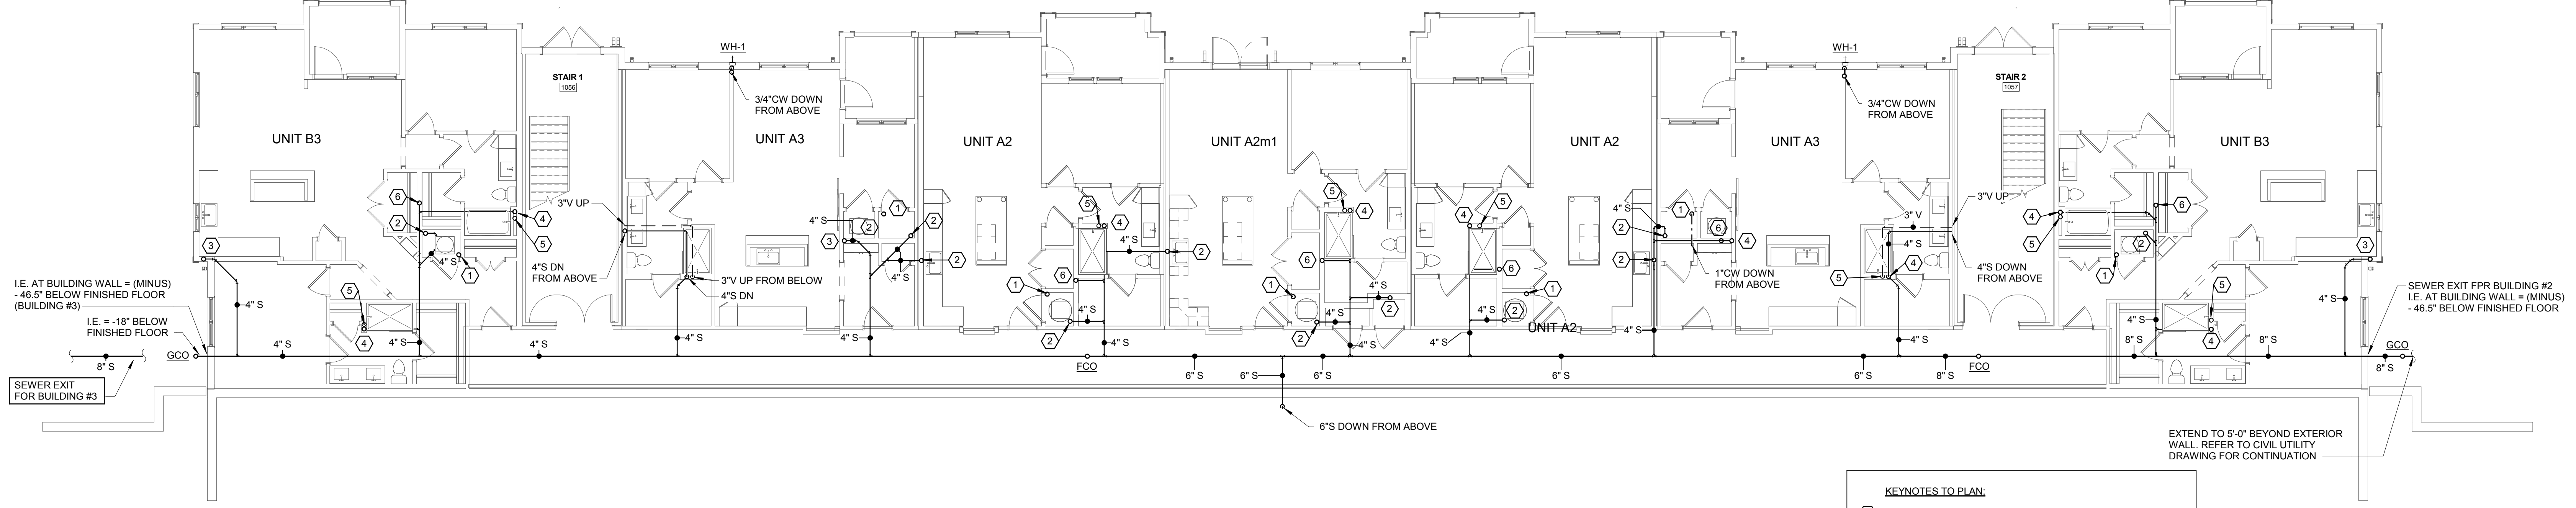



1 BLDG TYPE 2 - FIRST FLOOR PLAN - PLUMBING
SCALE: 1/8" = 1'-0"

- KEYNOTES TO PLAN:**
- ① COLD WATER RISER. SEE WATER RISER DIAGRAM FOR PIPE SIZE.
 - ② 3" WASTE STACK VENT (WSV).
 - ③ 3" WASTE STACK.
 - ④ 4" SANITARY STACK.
 - ⑤ 3" VENT STACK.
 - ⑥ 4" WASTE STACK VENT (WSV).
 - ⑦ 4" SANITARY PIPE DOWN FROM ABOVE.
 - ⑧ 4" SANITARY PIPE DOWN.

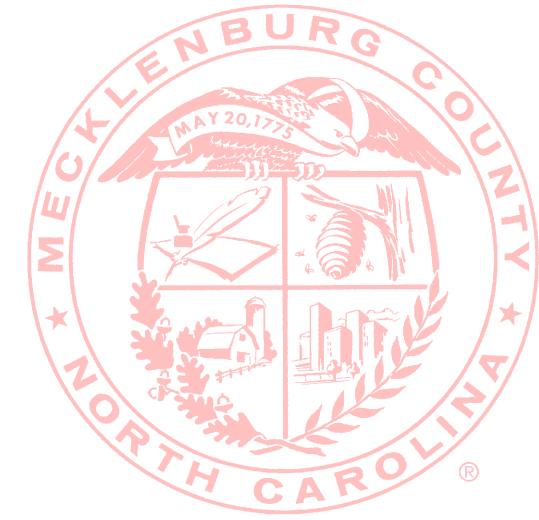

MECKLENBURG COUNTY
CODE ENFORCEMENT

The Design In These Construction Documents Have Been Reviewed For Compliance With The State Building Code. It Is The Responsibility Of The Contractor To Construct This Project With Good Engineering Practice And In Accordance With The North Carolina State Building Code.

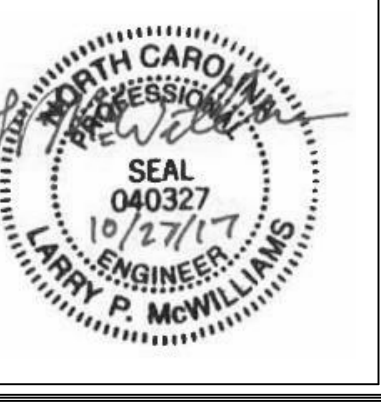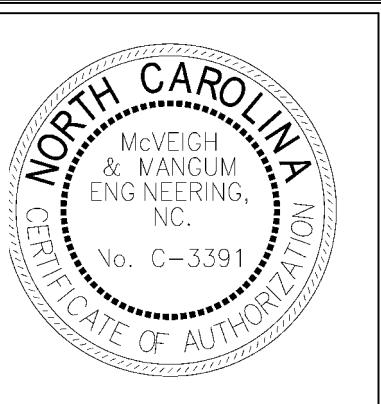

PROJECT: 217055
DATE: 10.27.2017
REVISIONS: DATE

DRAWN BY: Author
CHECKED BY: Checker
BLDG TYPE 2 - FLOOR PLANS