




- KEYNOTES TO PLAN - SEWER:**
- ① REFER TO OVERALL FLOOR PLANS FOR CONTINUATION.
  - ② 3" WASTE STACK VENT (WSV)
  - ③ 4" SANITARY STACK
  - ④ 3" VENT STACK RISER
  - ⑤ 3" SANITARY STACK

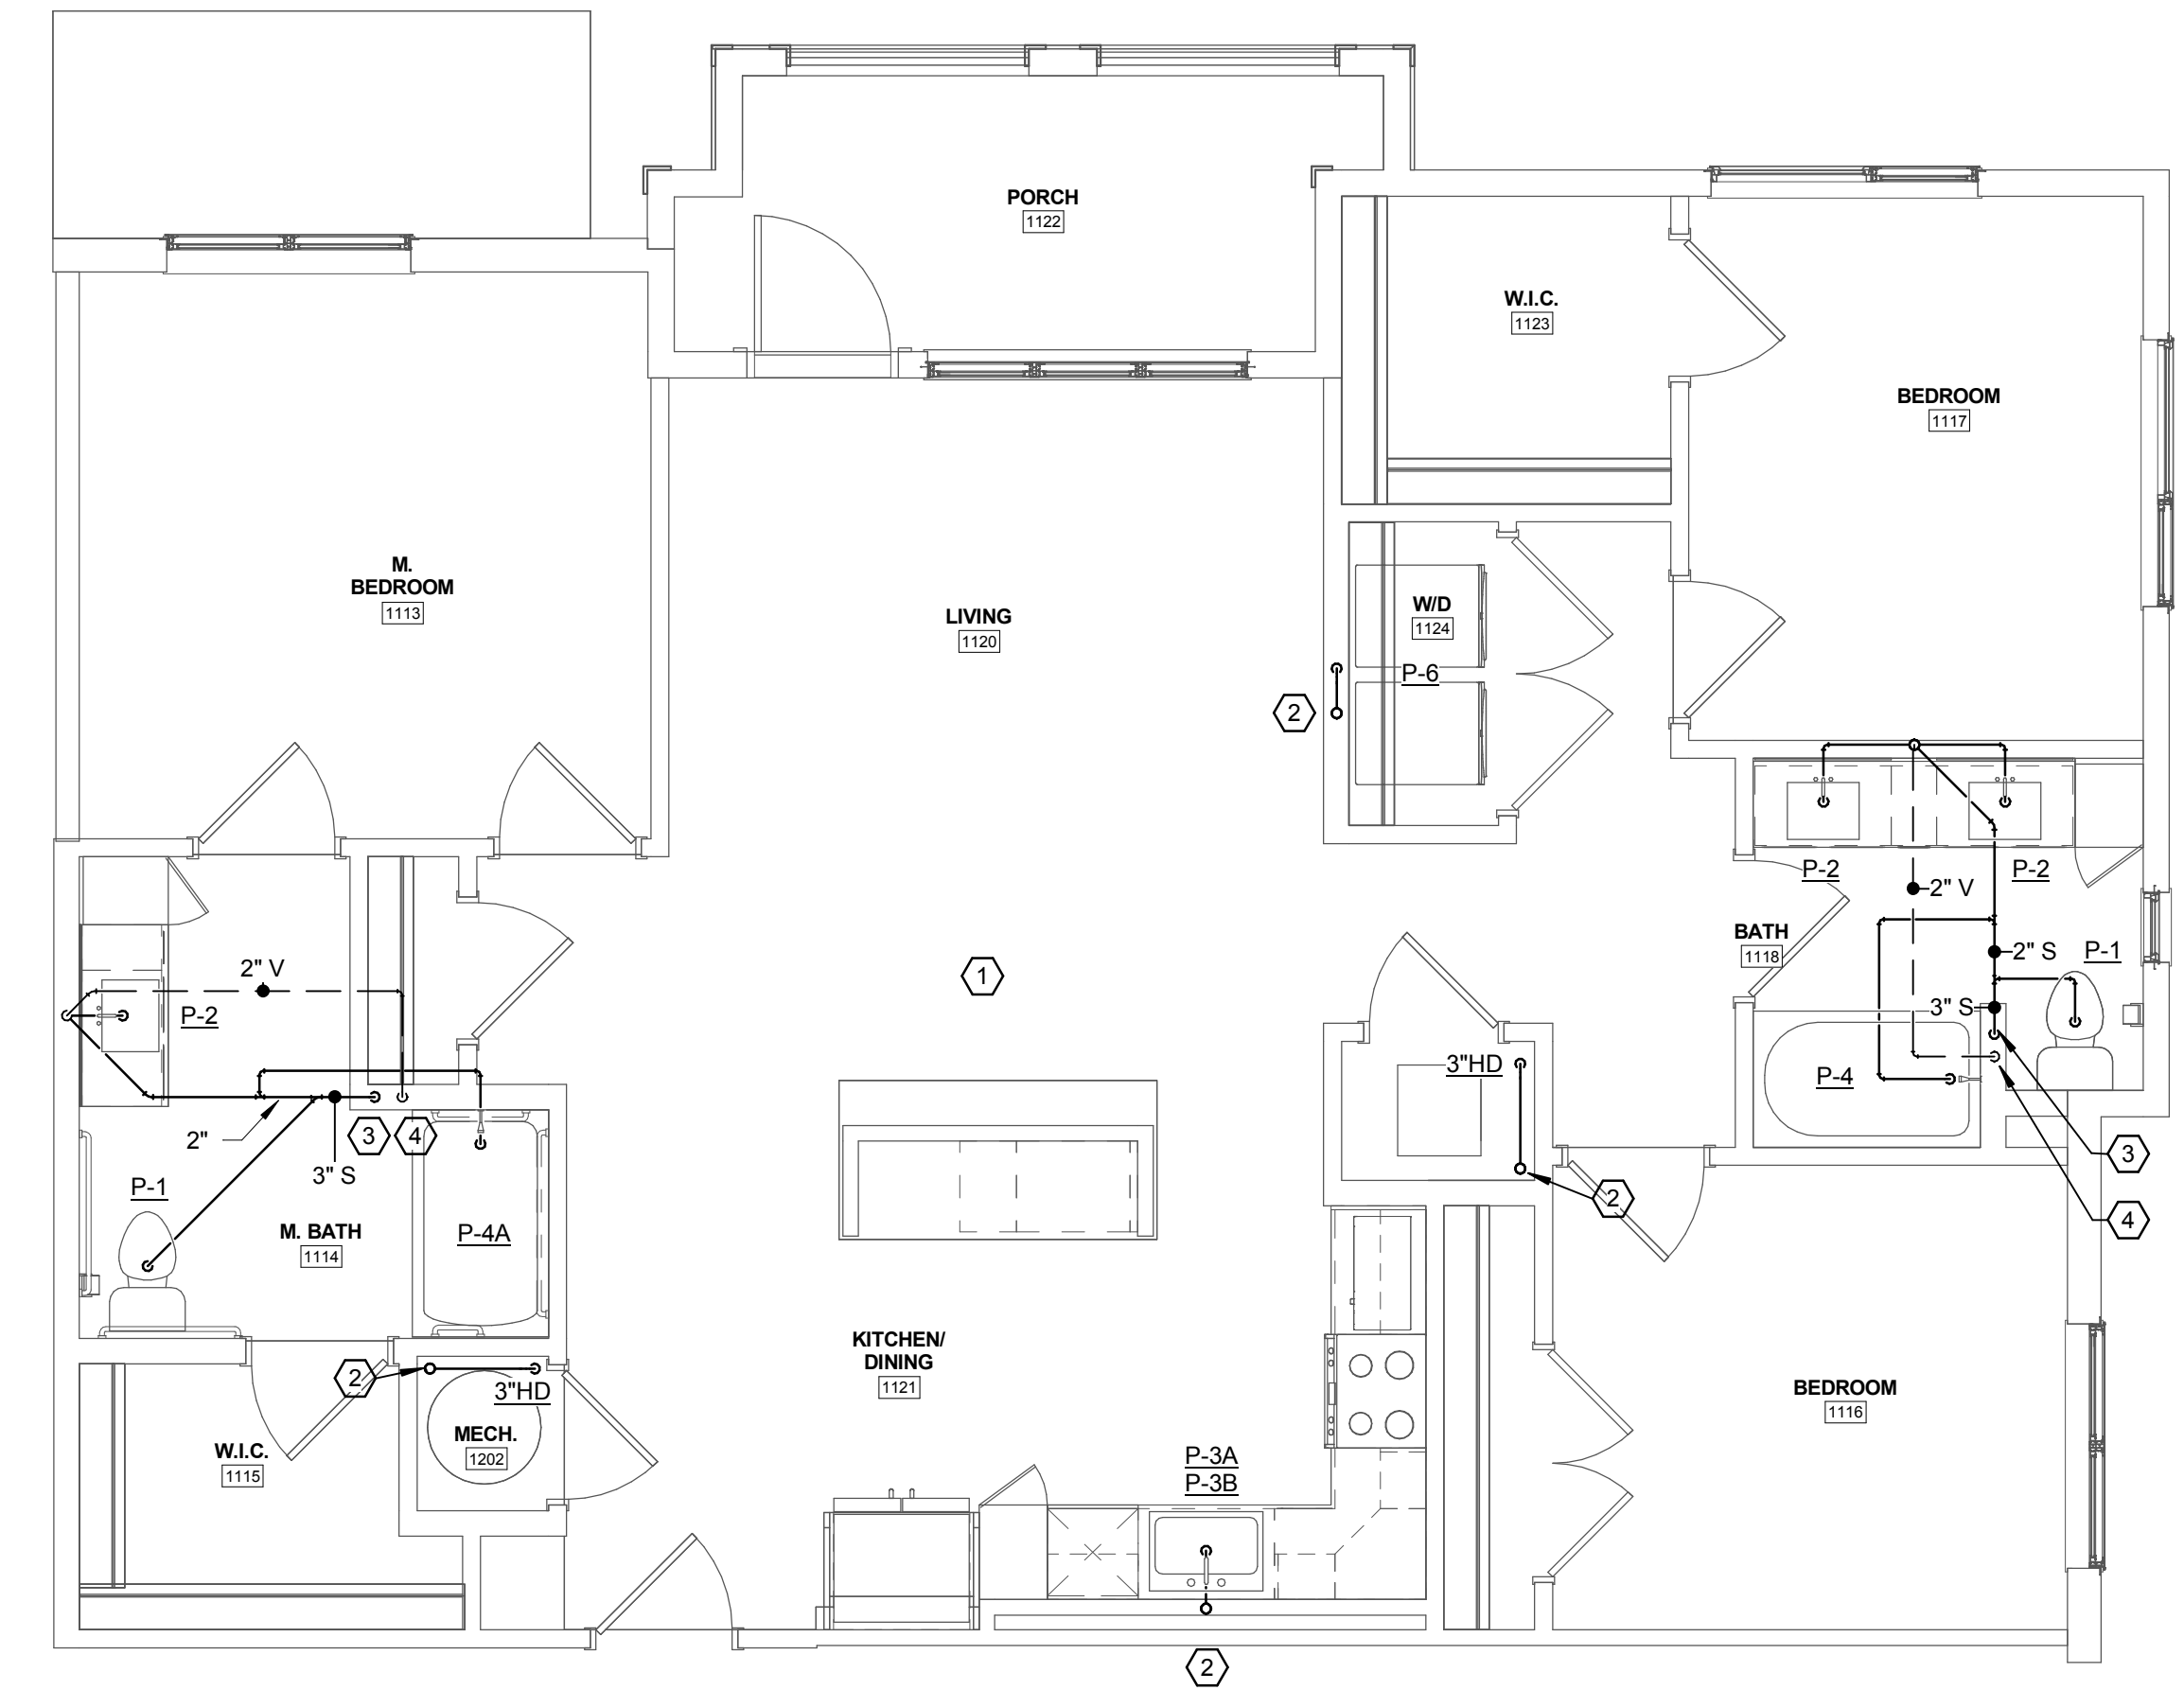


**3 UNIT C1-HC (TYPE 'A') - SANT/VENT**  
P4.05 SCALE: 1/4" = 1'-0"

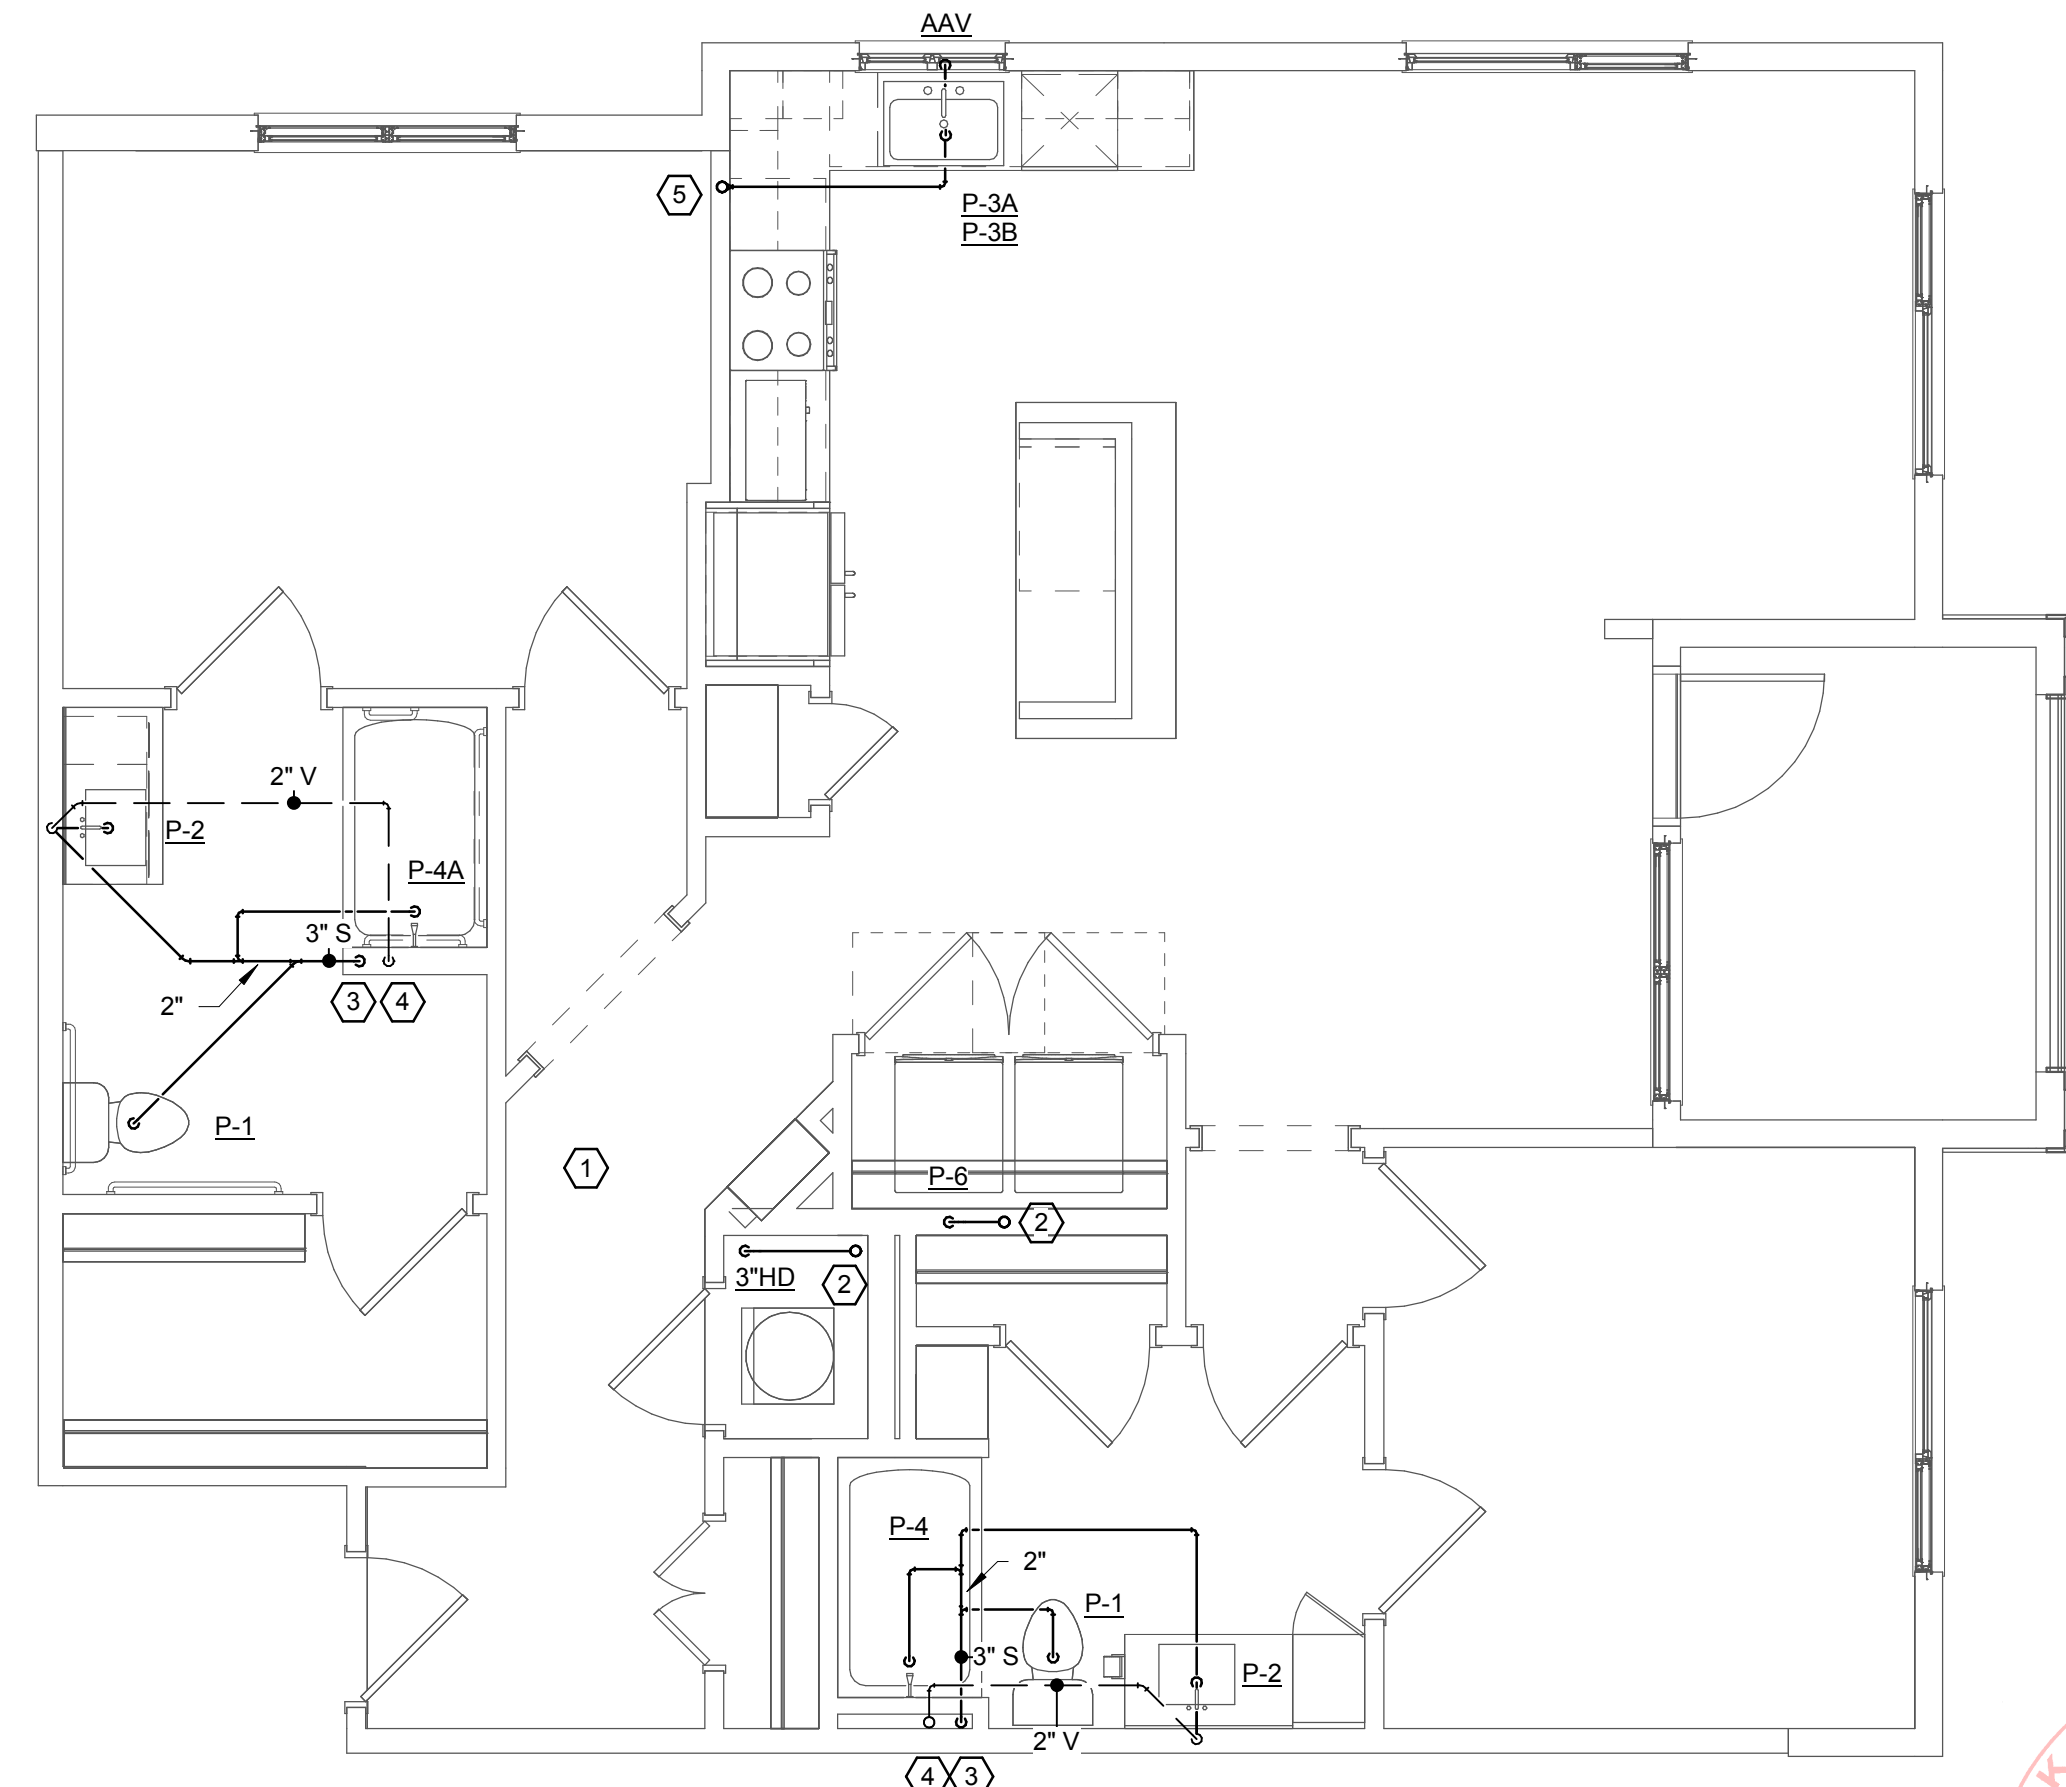

**2 UNIT B3-HC (TYPE 'A') - SANT/VENT**  
P4.05 SCALE: 1/4" = 1'-0"


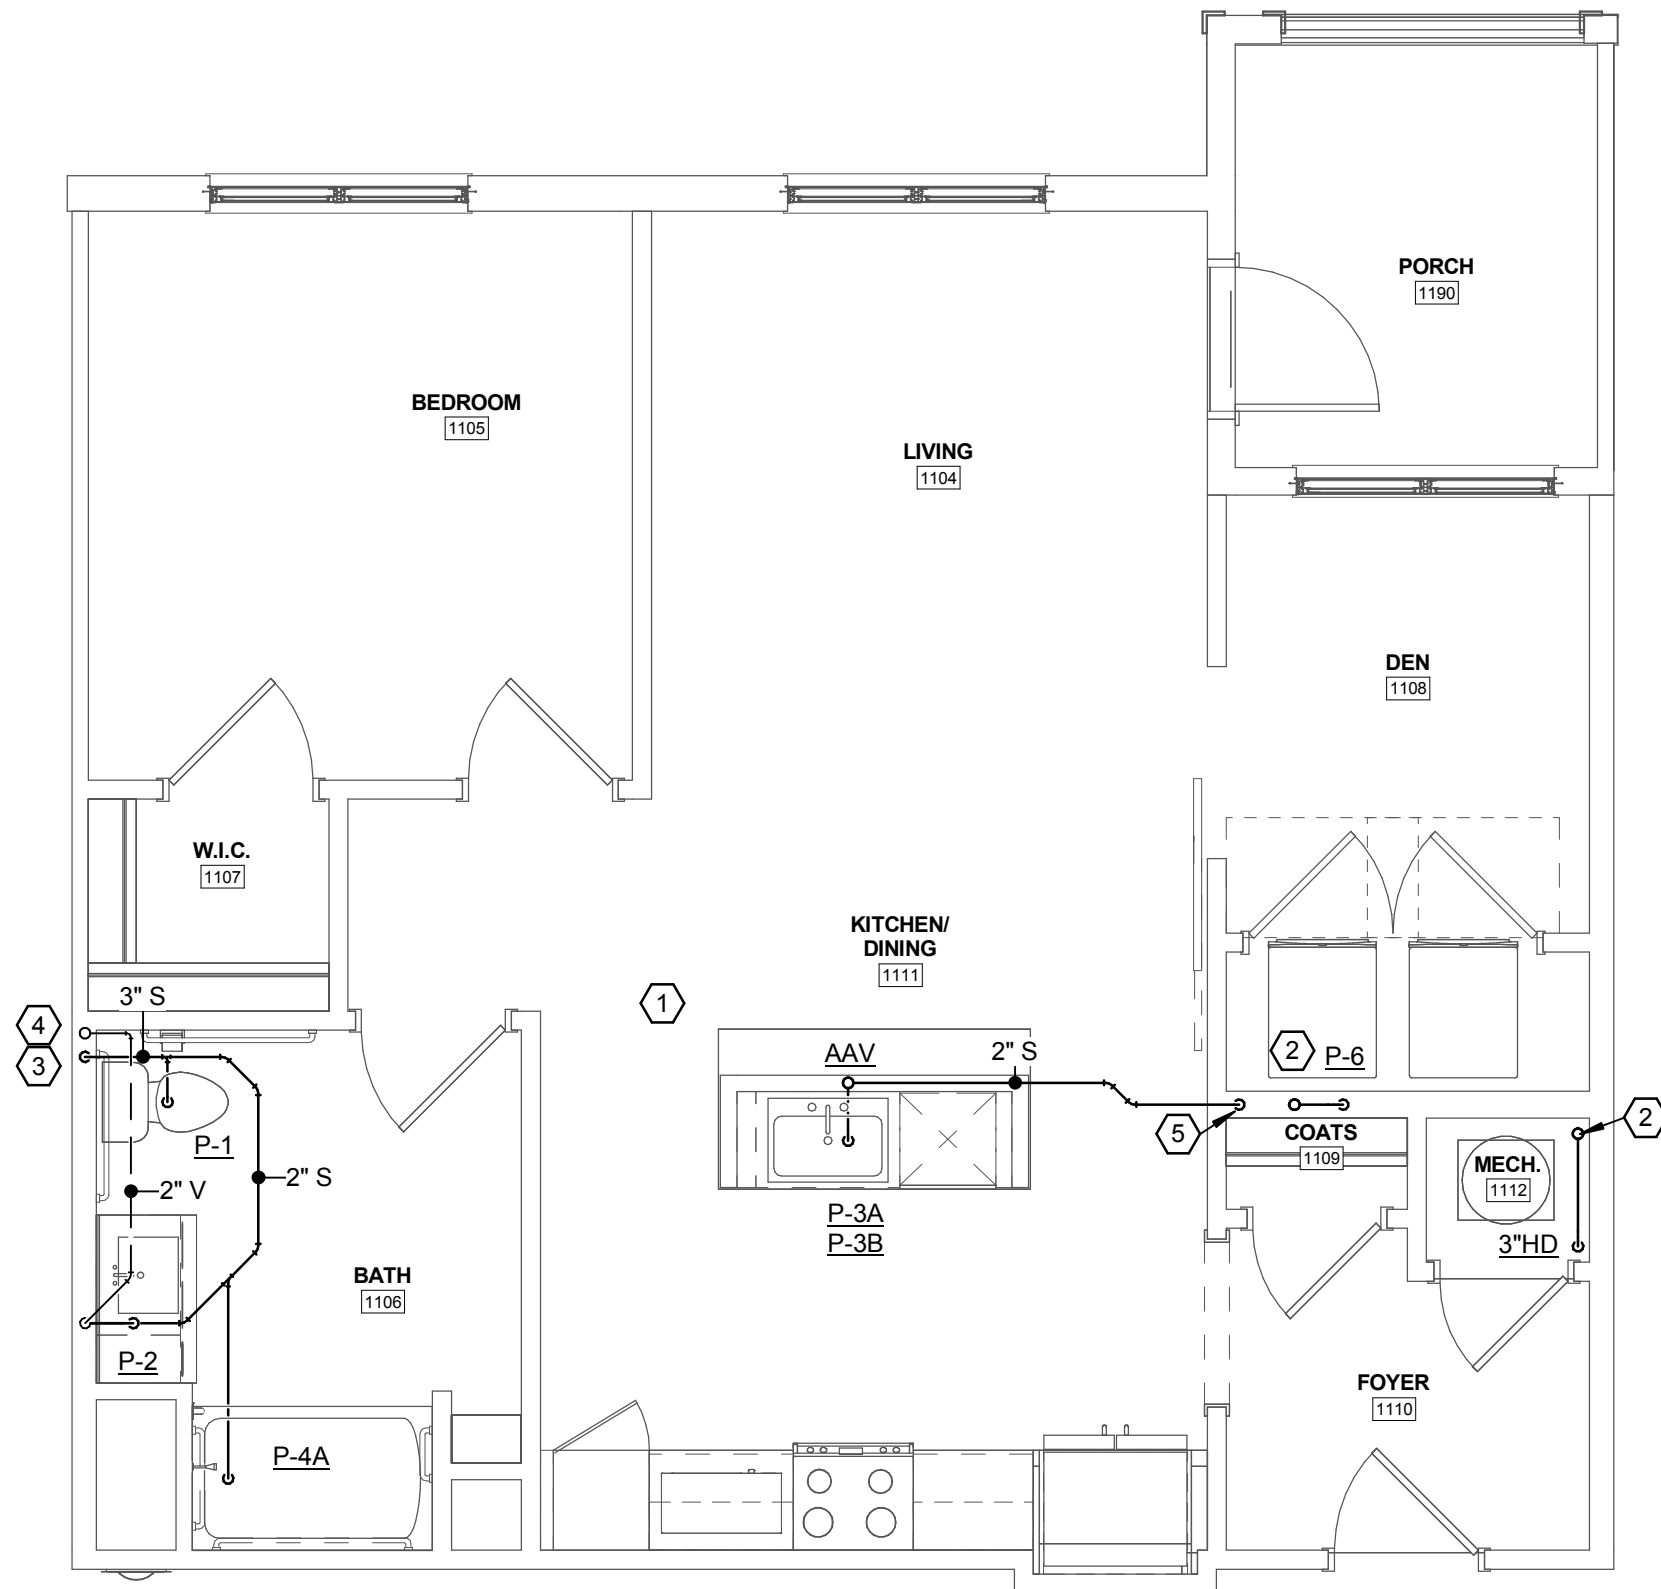


**1 UNIT A3-HC (TYPE 'A') - SANT/VENT**  
P4.05 SCALE: 1/4" = 1'-0"

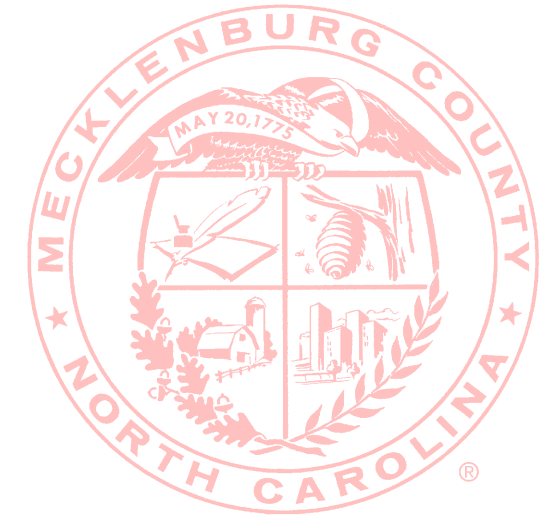

MECKLENBURG COUNTY  
CODE ENFORCEMENT

The Design In These Construction Documents Have Been Reviewed For Compliance With The State Building Code. It Is The Responsibility Of The Contractor To Construct This Project With Good Engineering Practice And In Accordance With The State Building Code.

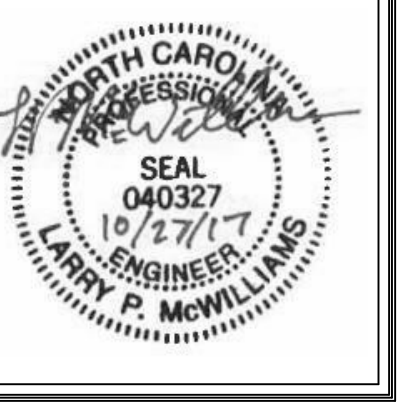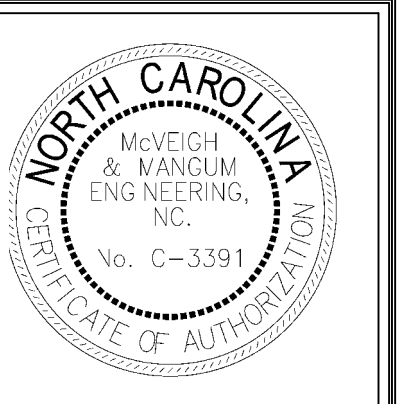

PROJECT:	217055
DATE:	10.27.2017
REVISIONS:	DATE

DRAWN BY:	Author
CHECKED BY:	Checker

**TYPE 'A' UNIT PLANS**