

**DAVIS
PARTNERSHIP
ARCHITECTS**

2901 Blake Street, Suite 100
Denver, CO 80205
303.861.8555

Consultant

MEP PROJECT #16126
DESIGNED BY: JLB CHECKED BY: MMS



MEP ENGINEERING INC.
6442 S. Troy Circle, Suite 100 (W) 303.938.2833
Centennial, CO 80111 (F) 303.934.3299
info@mep-eng.com www.mep-eng.com

**PROGRESS PRINTS
NOT FOR
CONSTRUCTION**
06/20/16 09:20:20 AM

Issuance Date

SCHEMATIC DESIGN 06/02/16

Revisions Date No.

Project Information

CRESCENT RIO

700 WEST 1ST STREET TEMPE, AZ 85281

Sheet Information


Sheet Title:

**LEVEL 1 OVERALL
PLUMBING**

Sheet Number:

P2.01

MEP Project: 16504.00

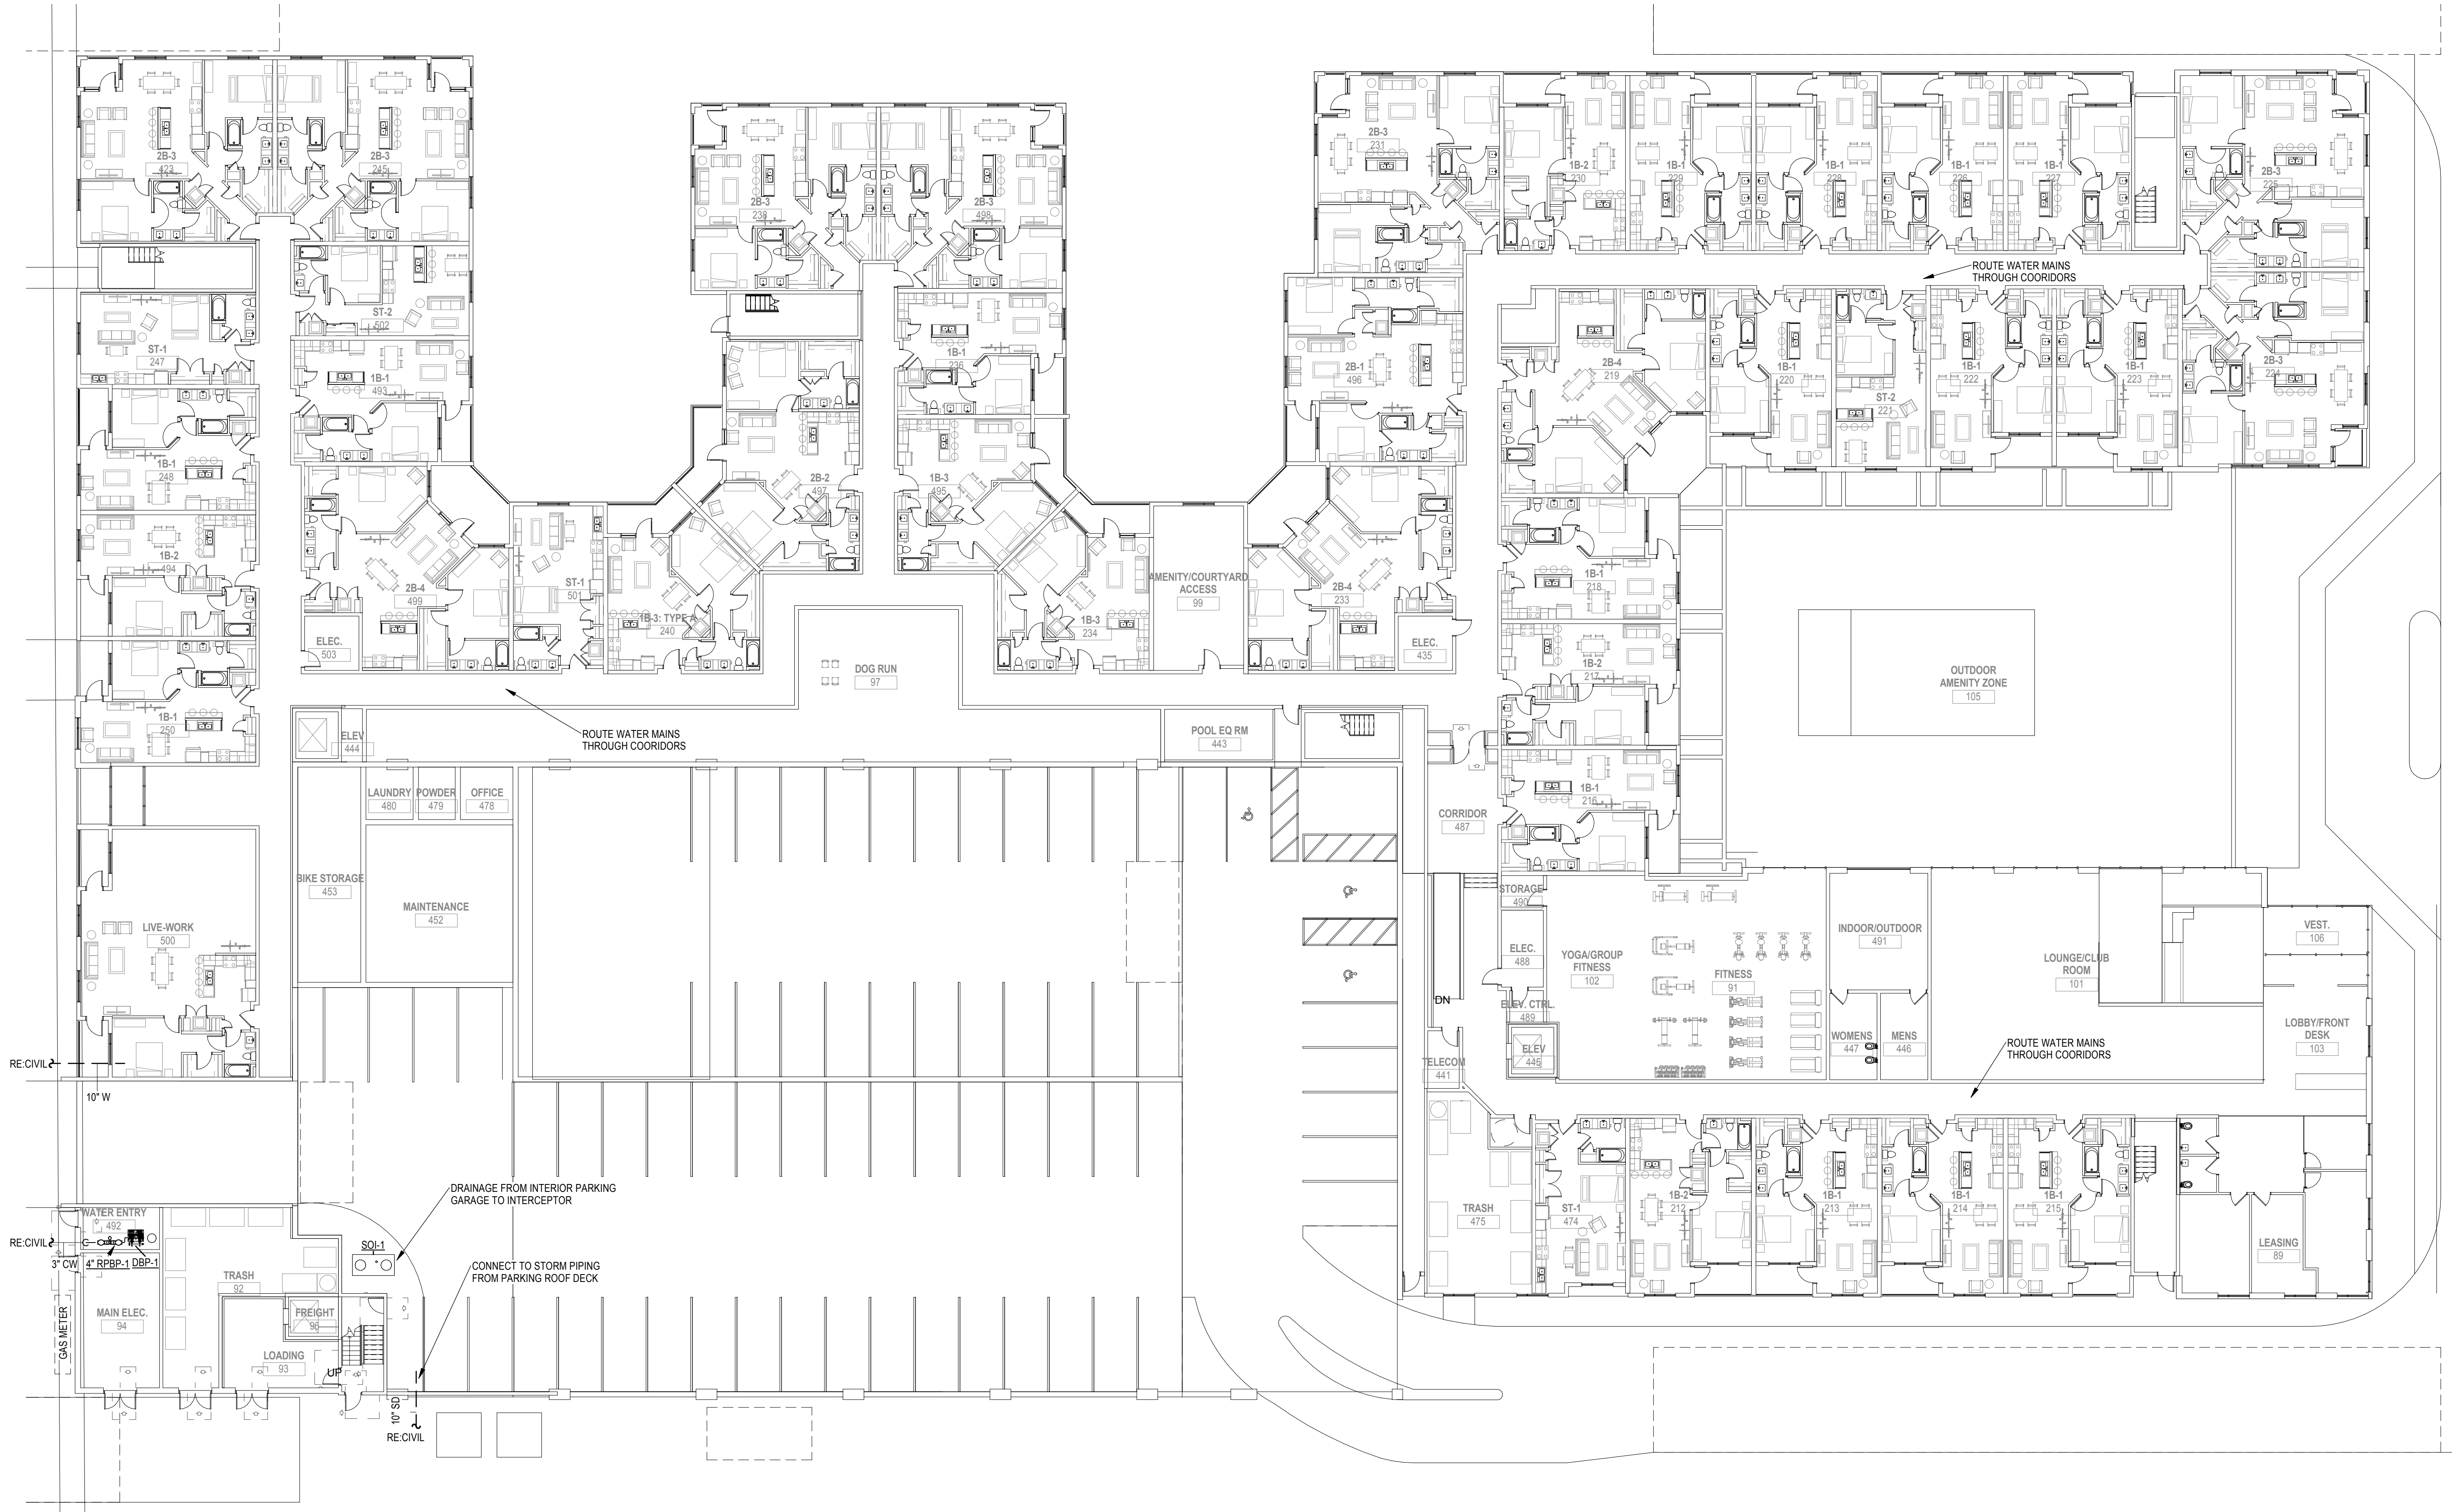

LEVEL 1 PLUMBING PLAN OVERALL
SCALE: 1/16" = 1'-0"

6/20/16 10:52 AM