

**FOR CONSTRUCTION**



**CRESCENT COMMUNITIES**


**LOCATION** / CHARLOTTE, NC  
**PROJECT #** / 19CRC150  
**DATE** / 04.22.2020  
**DRAWN** / Author

COPYRIGHT 2019 BB+M ARCHITECTURE PLLC.

Revisions		
No.	Description	Date

**LEVEL B FLOOR PLAN -  
PLUMBING**

**P1.0B**

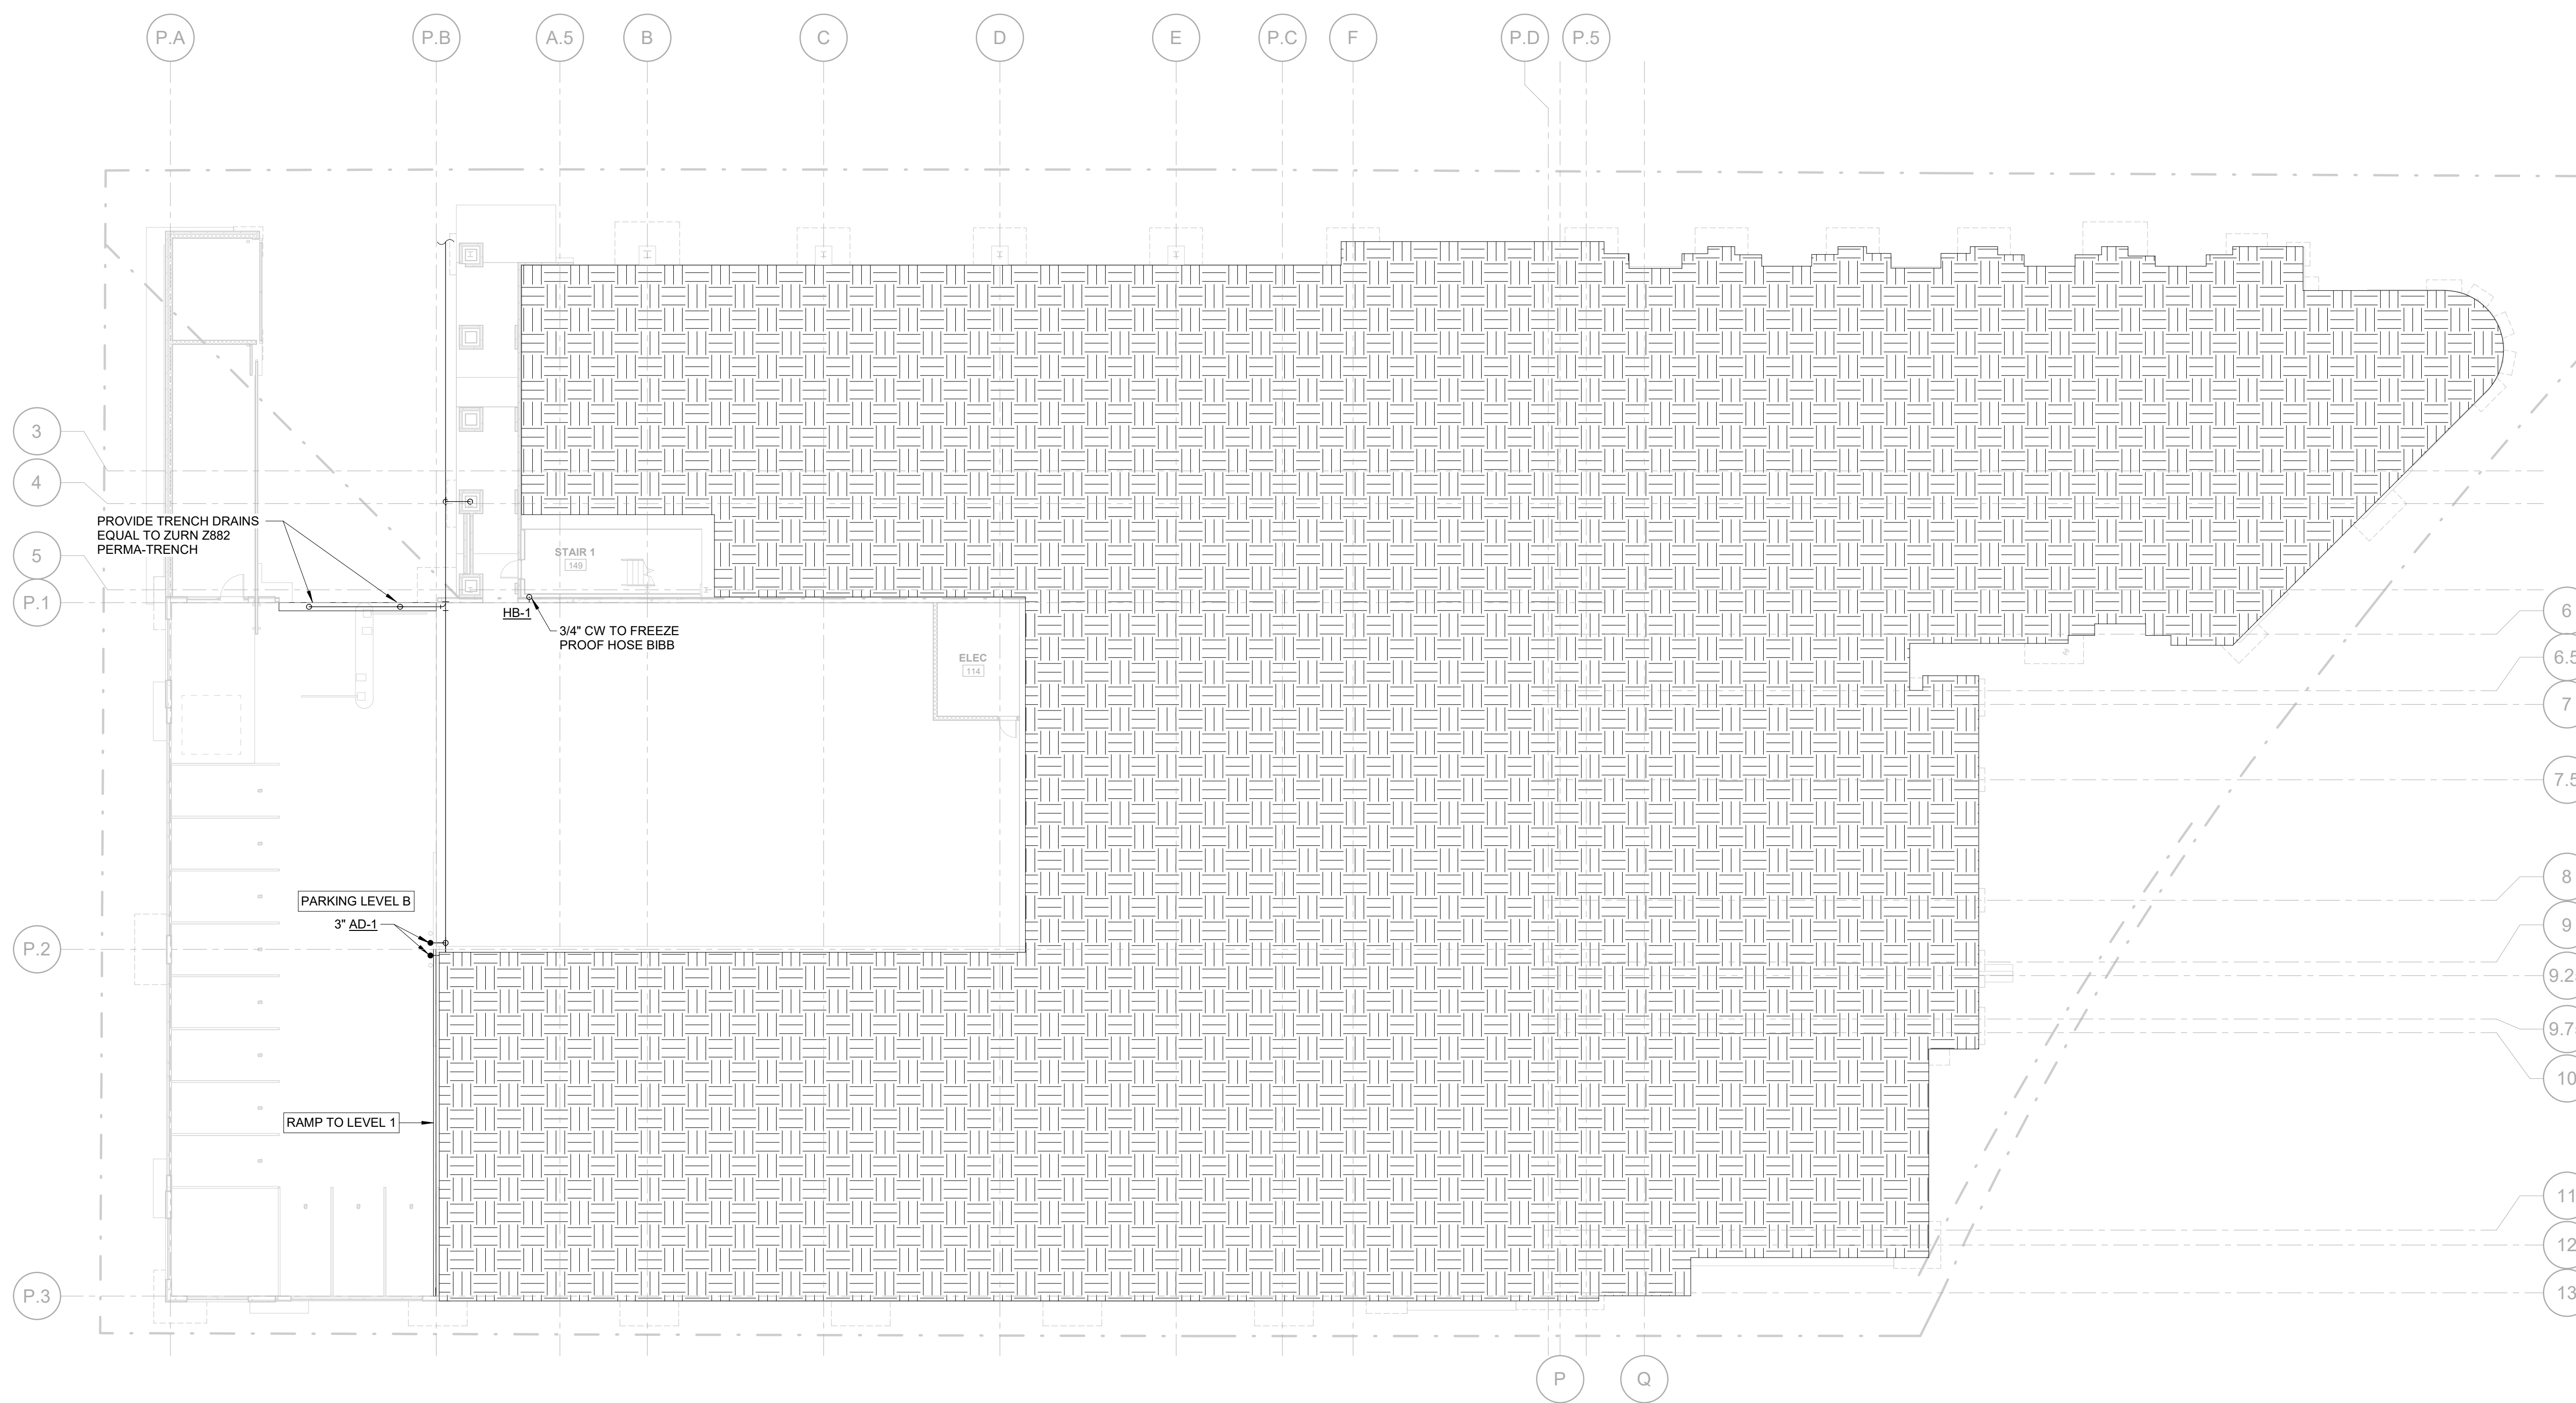

**LEVEL B - DOMESTIC WATER PLAN**  
SCALE: 1/16" = 1'-0"