

FOR CONSTRUCTION

**ELIZABETH**  
ON SEVENTH

CRESCENT COMMUNITIES


LOCATION / CHARLOTTE, NC  
PROJECT # / 19CRC150  
DATE / 04.22.2020  
DRAWN / DSW

COPYRIGHT 2019 BB+M ARCHITECTURE PLLC.

Revisions		
No.	Description	Date

LEVEL 3 FLOOR PLAN -  
PLUMBING

**P1.03**

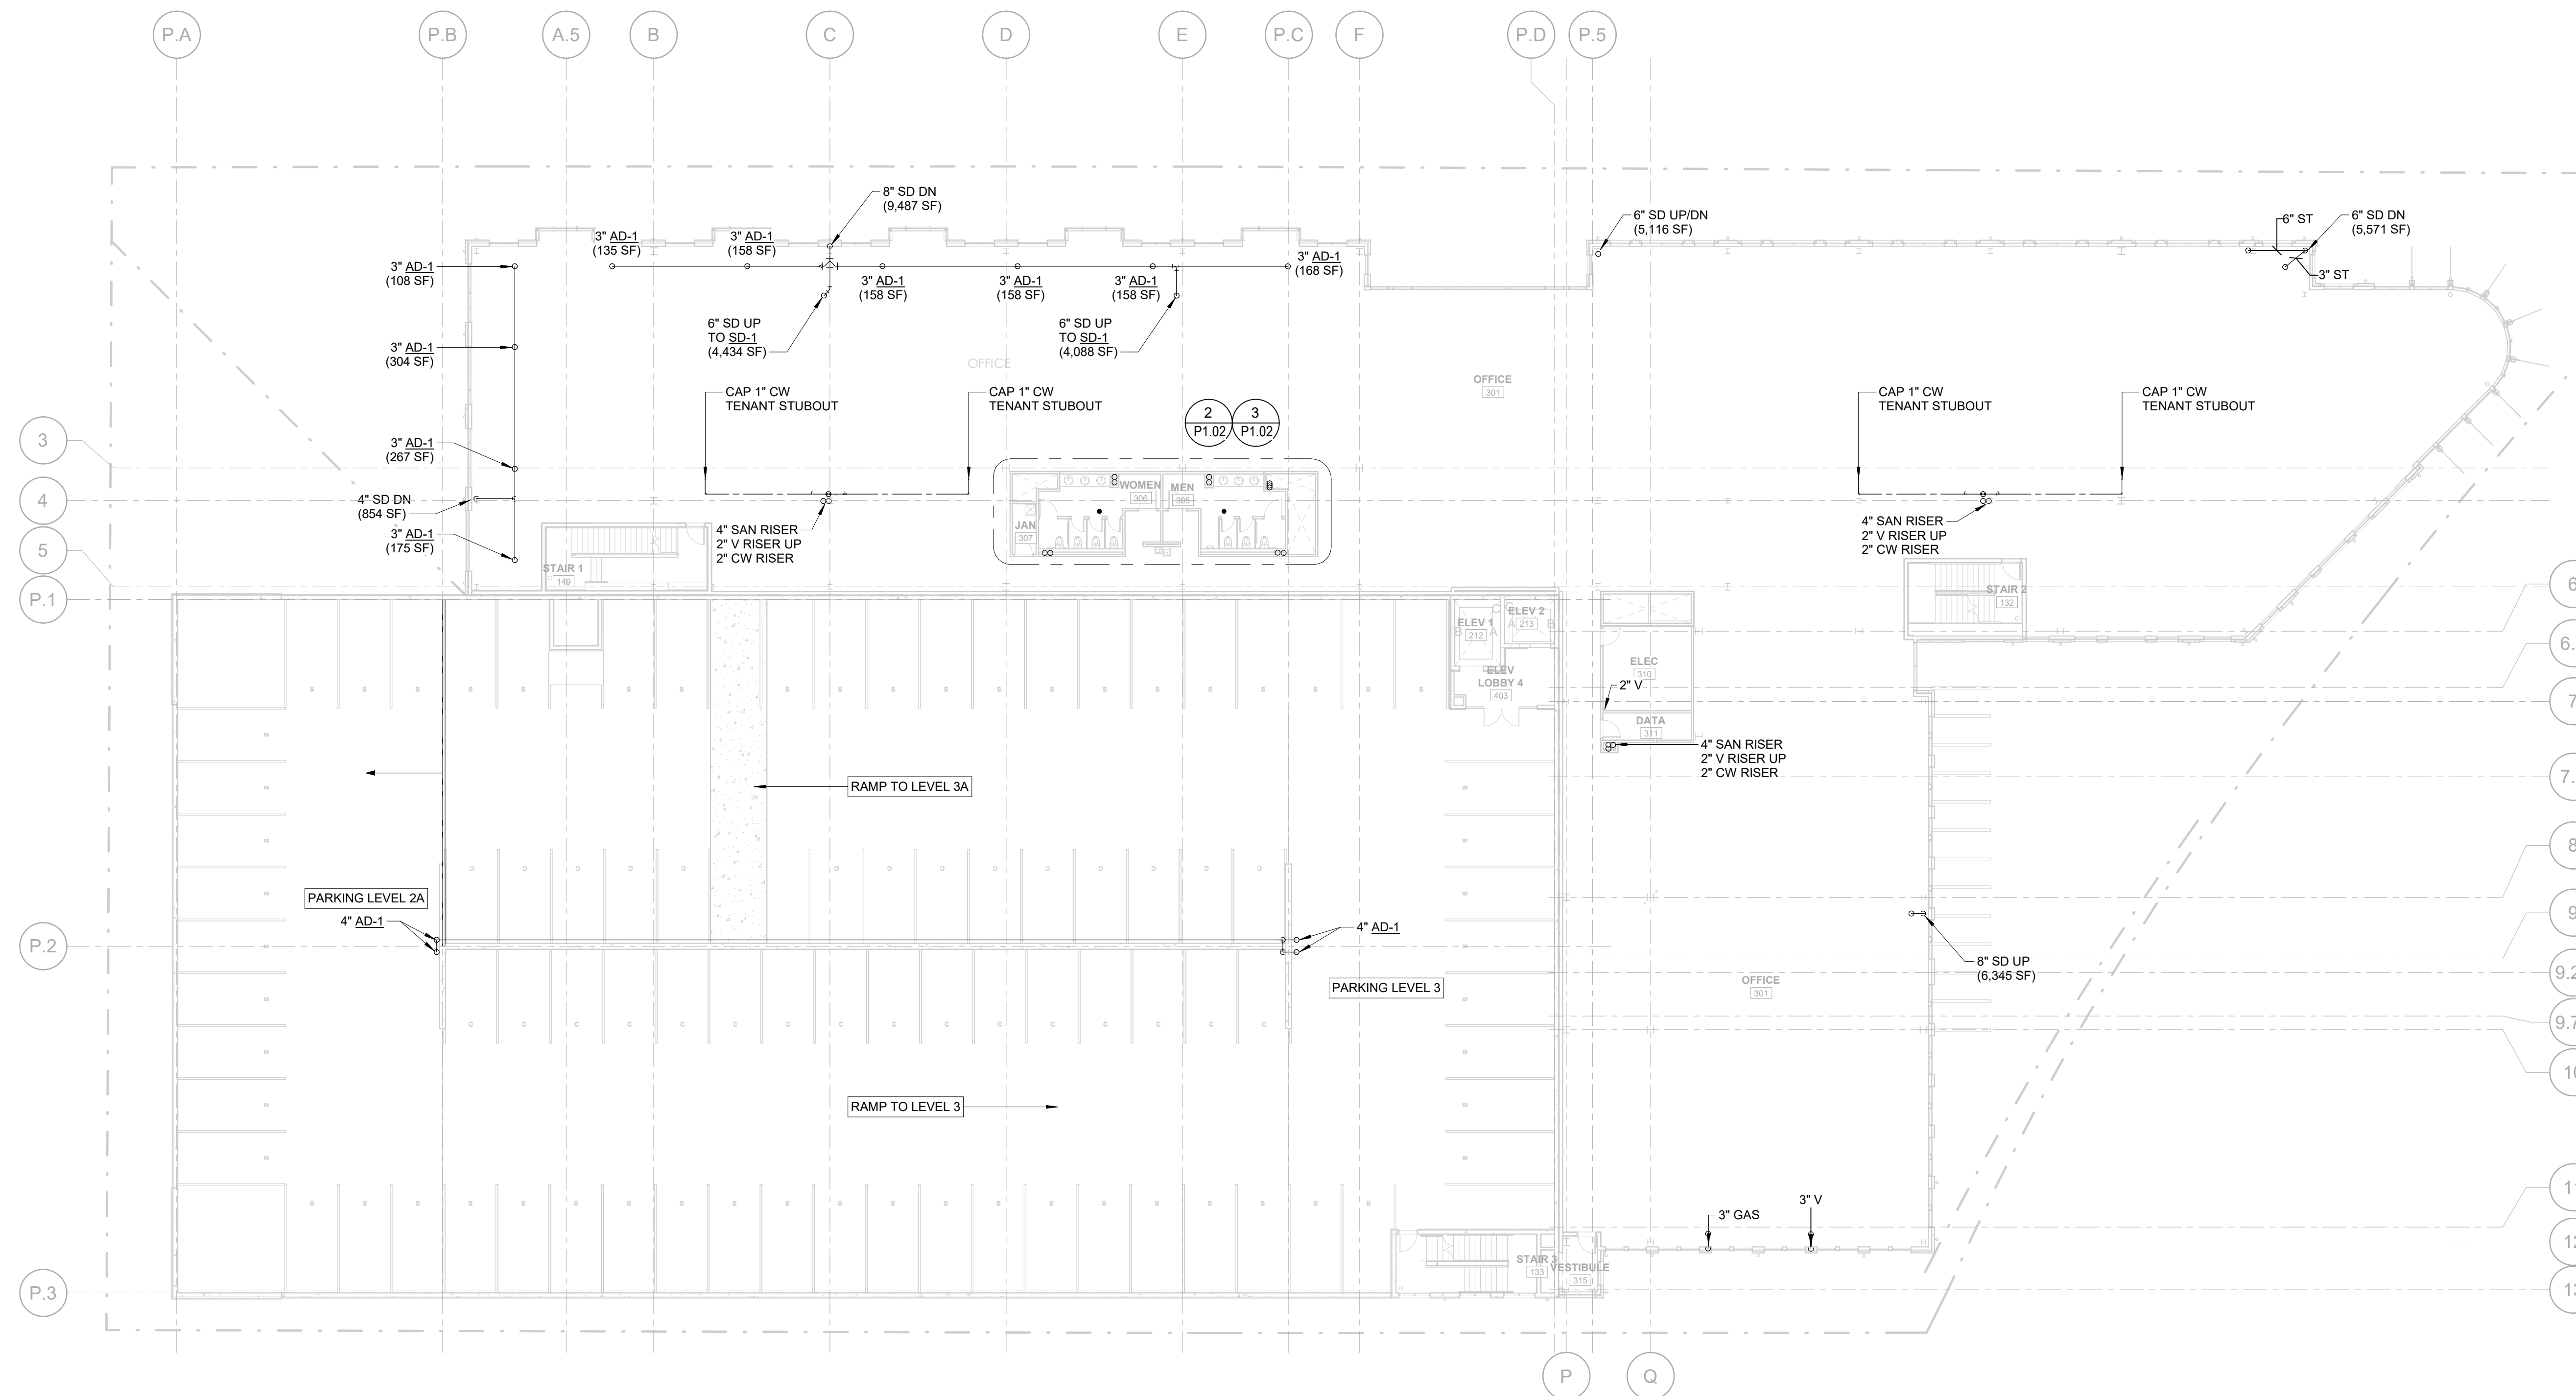

**1**  
P1.03 LEVEL 3 - DOMESTIC WATER PLAN  
SCALE: 1/16" = 1'-0"