

FOR CONSTRUCTION



CRESCENT COMMUNITIES


LOCATION / CHARLOTTE, NC
PROJECT # / 19CRC150
DATE / 04.22.2020
DRAWN / DSW

COPYRIGHT 2019 BB+M ARCHITECTURE PLLC.

Revisions		
No.	Description	Date

ROOF PLAN - PLUMBING

P1.05

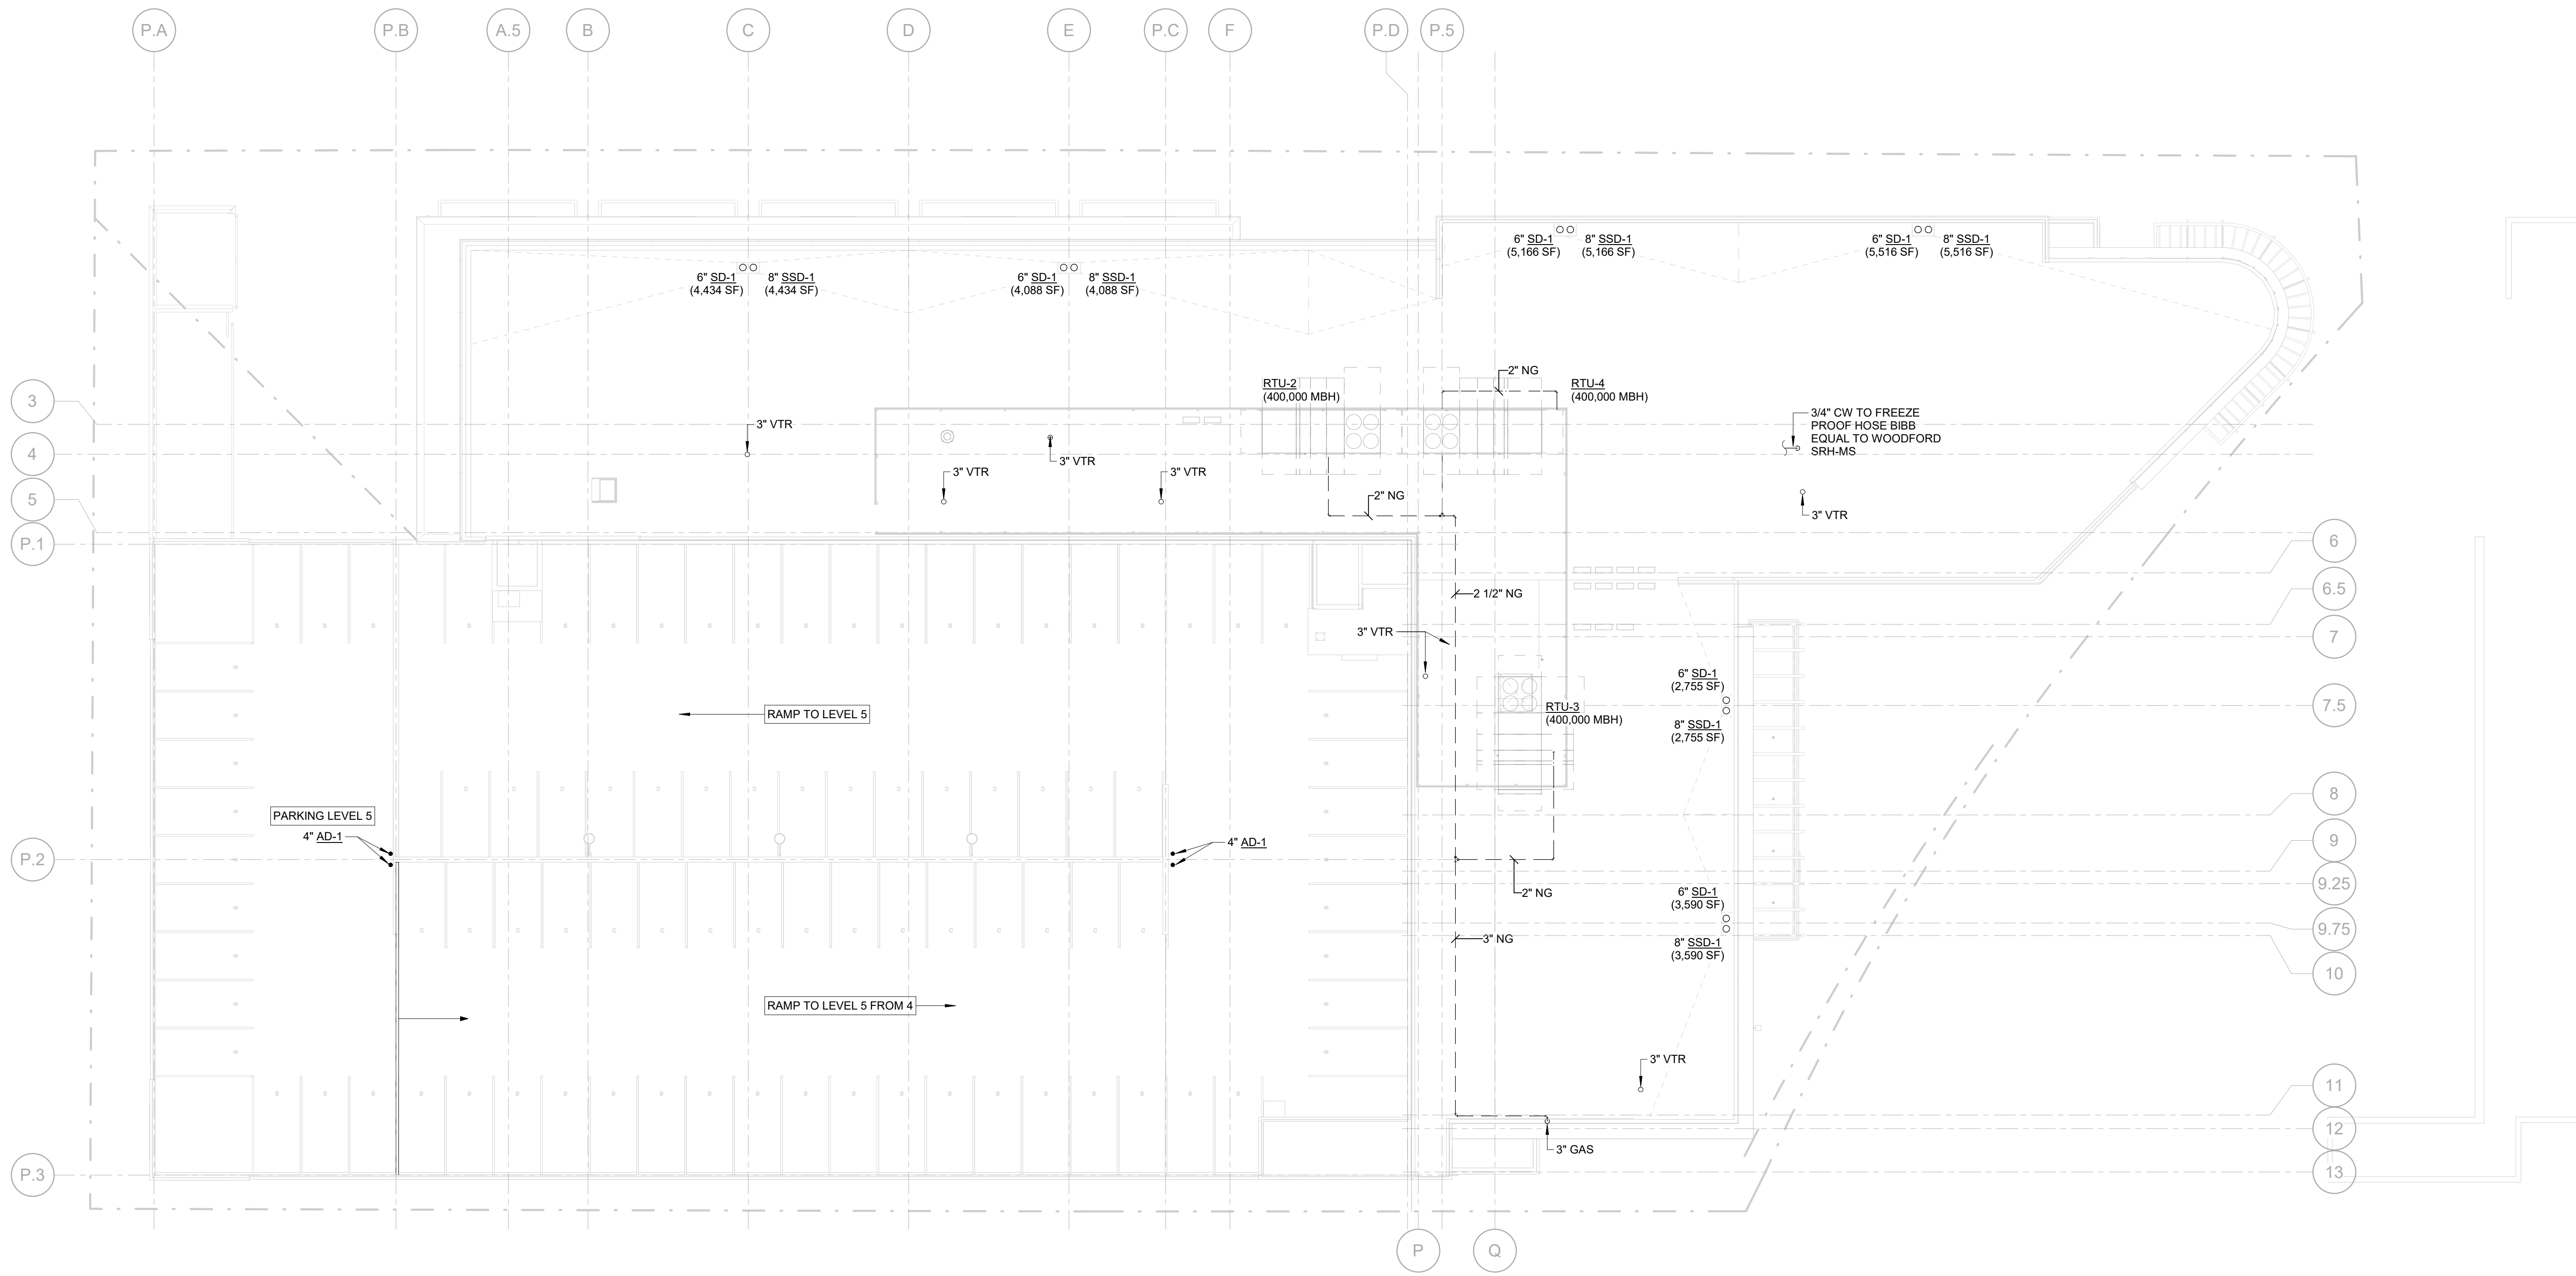

1 ROOF - DOMESTIC WATER PLAN
SCALE: 1/16" = 1'-0"