

FOR CONSTRUCTION




CRESCENT COMMUNITIES

LOCATION / CHARLOTTE, NC
PROJECT # / 19CRC150
DATE / 04.22.2020
DRAWN / DSW

COPYRIGHT 2019 BB+M ARCHITECTURE PLLC.

Revisions		
No.	Description	Date

PARKING LEVEL 2 - PLUMBING

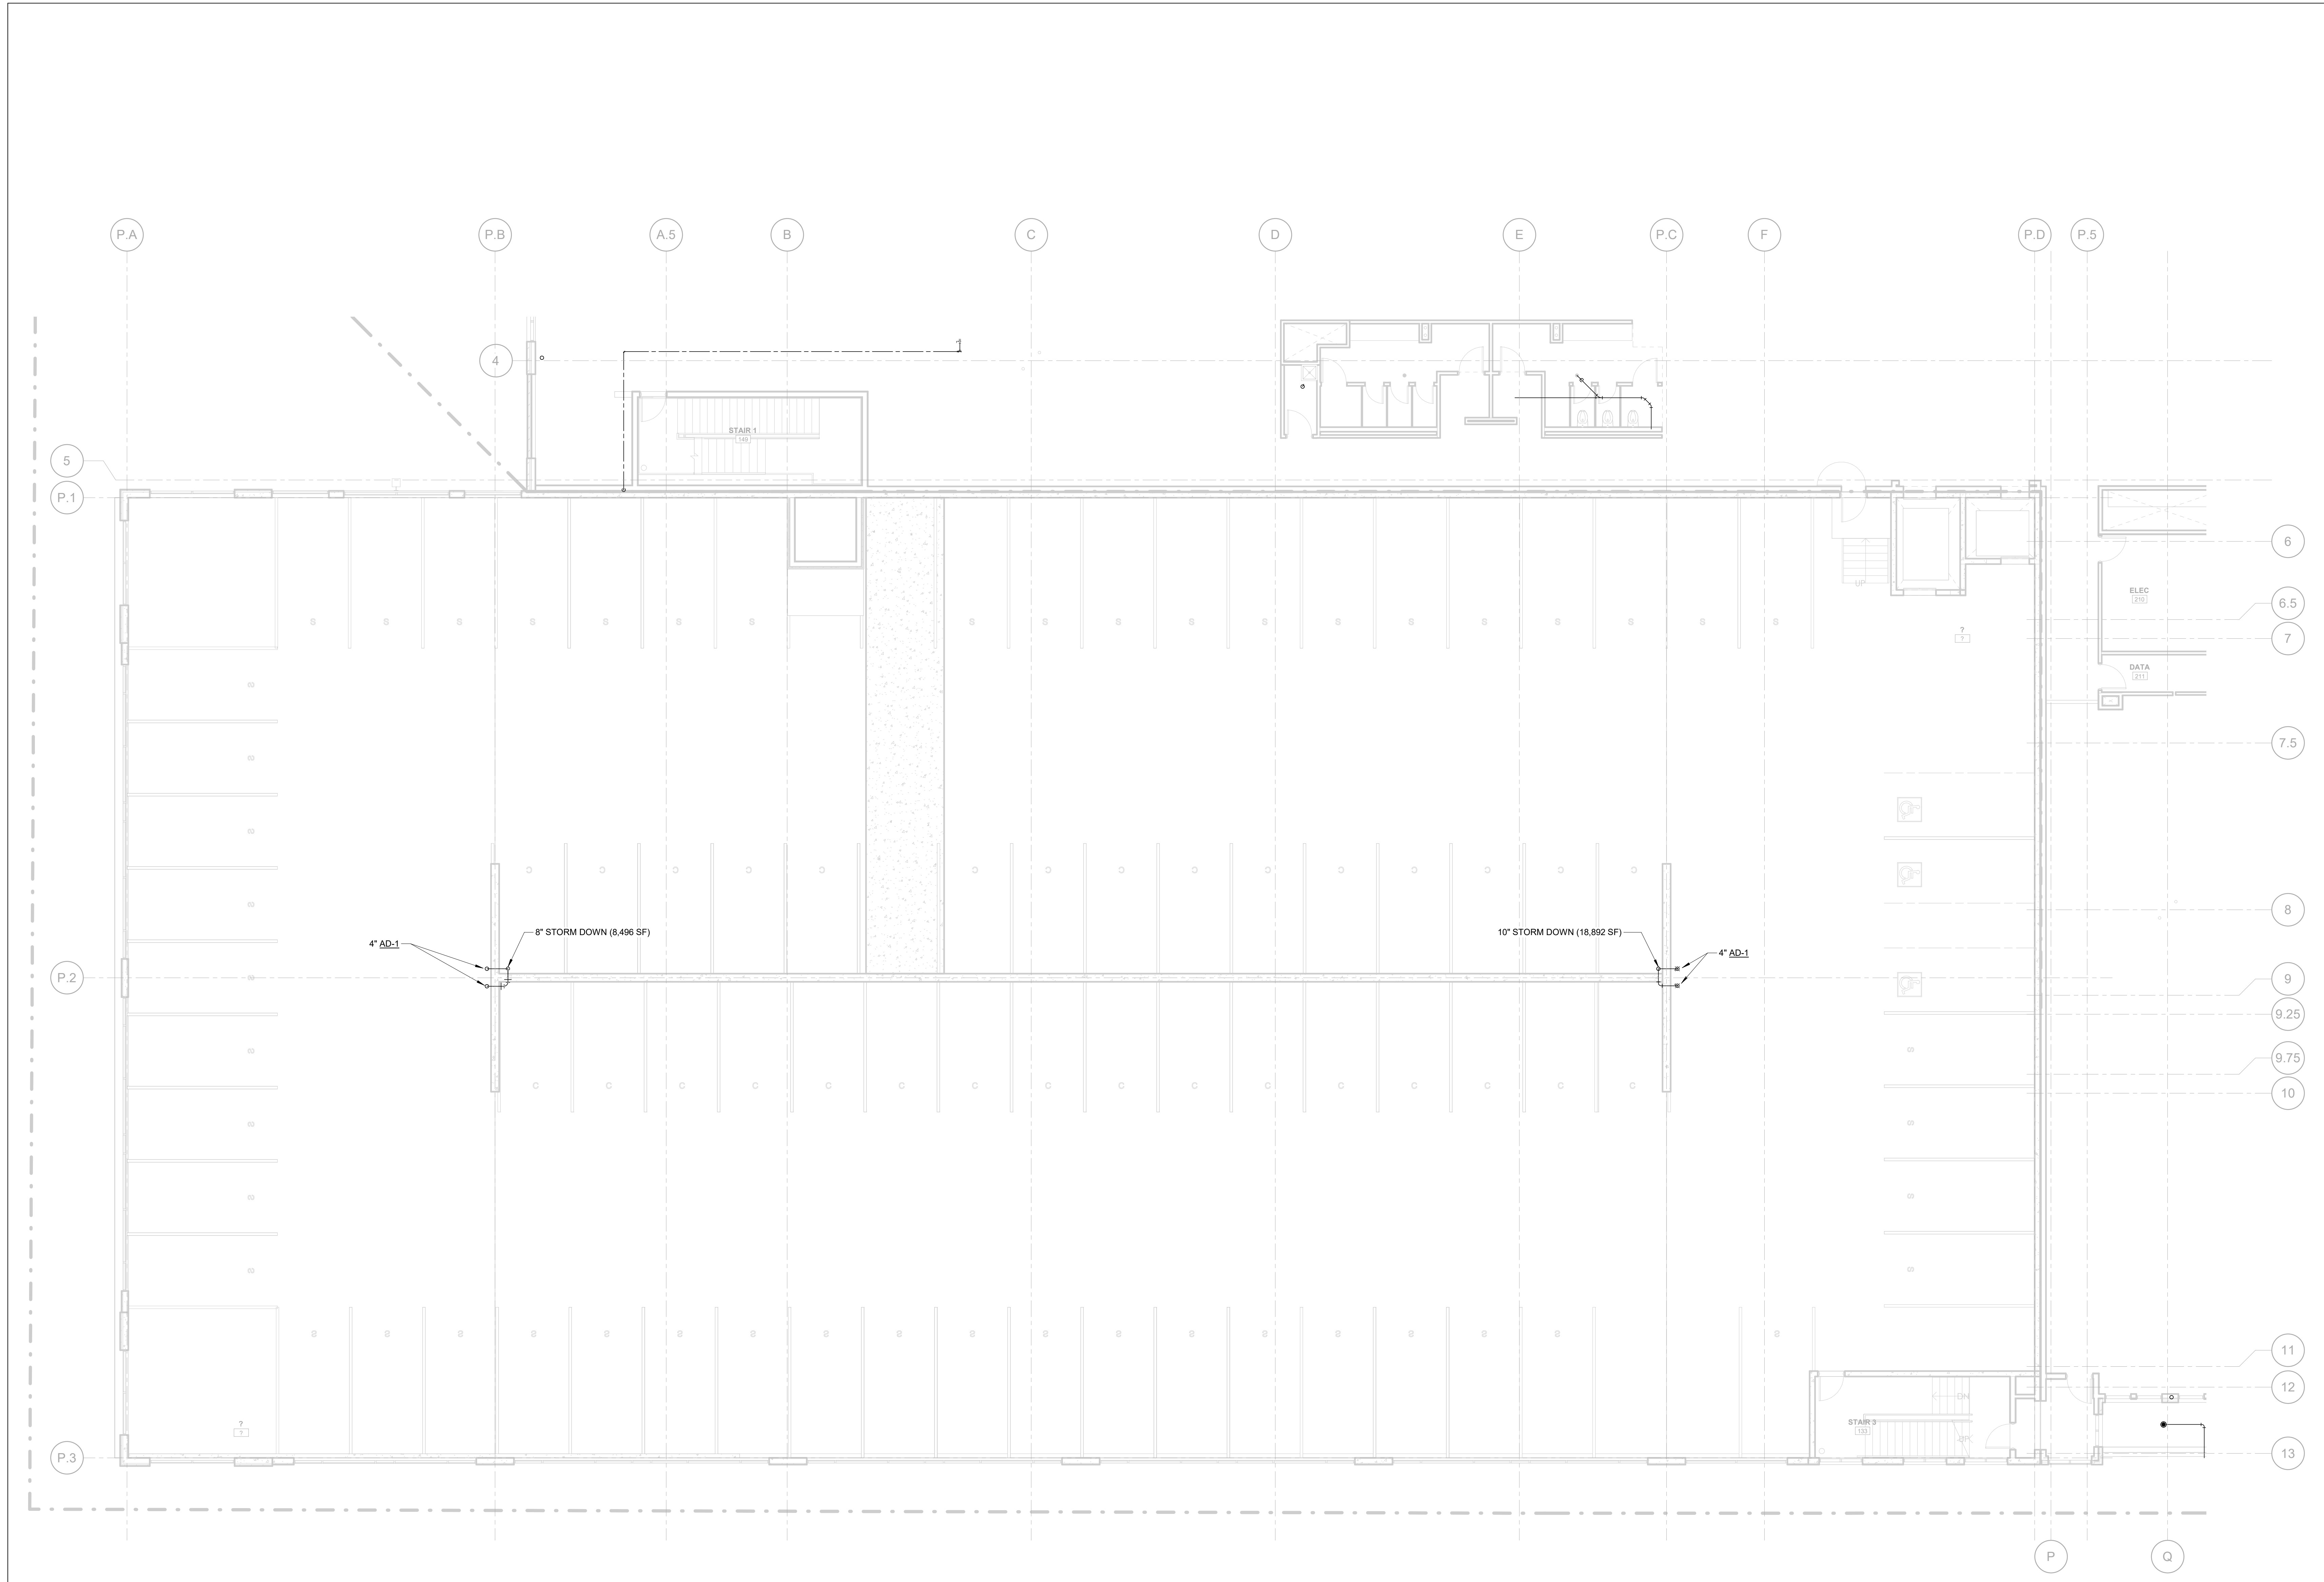

1 PARK LEVEL 2 - PLUMBING PLAN
PG1.02 SCALE: 1/8" = 1'-0"