


GENERAL NOTES


* REFER TO SHEET P1.1 FOR GENERAL NOTES

KEYED NOTES (XX)


- 01 PIPE INDIRECT WASTE FROM NEW/RELOCATED CASE TO EXISTING HUB DRAIN. VERIFY EXISTING HUB DRAIN LOCATION IN FIELD AND ADJUST AS NECESSARY TO ACCOMMODATE NEW CASE.
- 02 PROVIDE MAGIC WASTE AIR ADMITTANCE VALVE IN ACCESSIBLE LOCATION BENEATH CASE.
- 03 MINIMUM INVERT 3'-0" B.F.G.
- 04 REFER TO CIVIL DRAWINGS FOR CONTINUATION. PLUMBING CONTRACTOR SHALL MAKE ALL NECESSARY CONNECTIONS TO ON SITE UTILITIES AS NECESSARY TO PROVIDE A COMPLETE SYSTEM. (WITHIN 5' OF BUILDING EXTERIOR).
- 05 3" STORM PIPE UP TO ROOF DRAIN. REFER TO SHEET P4.1 FOR CONTINUATION.
- 06 6" OVERFLOW PIPE UP TO OVERFLOW DRAIN. REFER TO SHEET P4.1 FOR CONTINUATION.
- 07 DROP OVERFLOW PIPING DOWN WITH ZURN Z-199-DC-VP DOWNSPOUT COVER AND DISCHARGE IN VISIBLE LOCATION, MINIMUM 12" AFG.

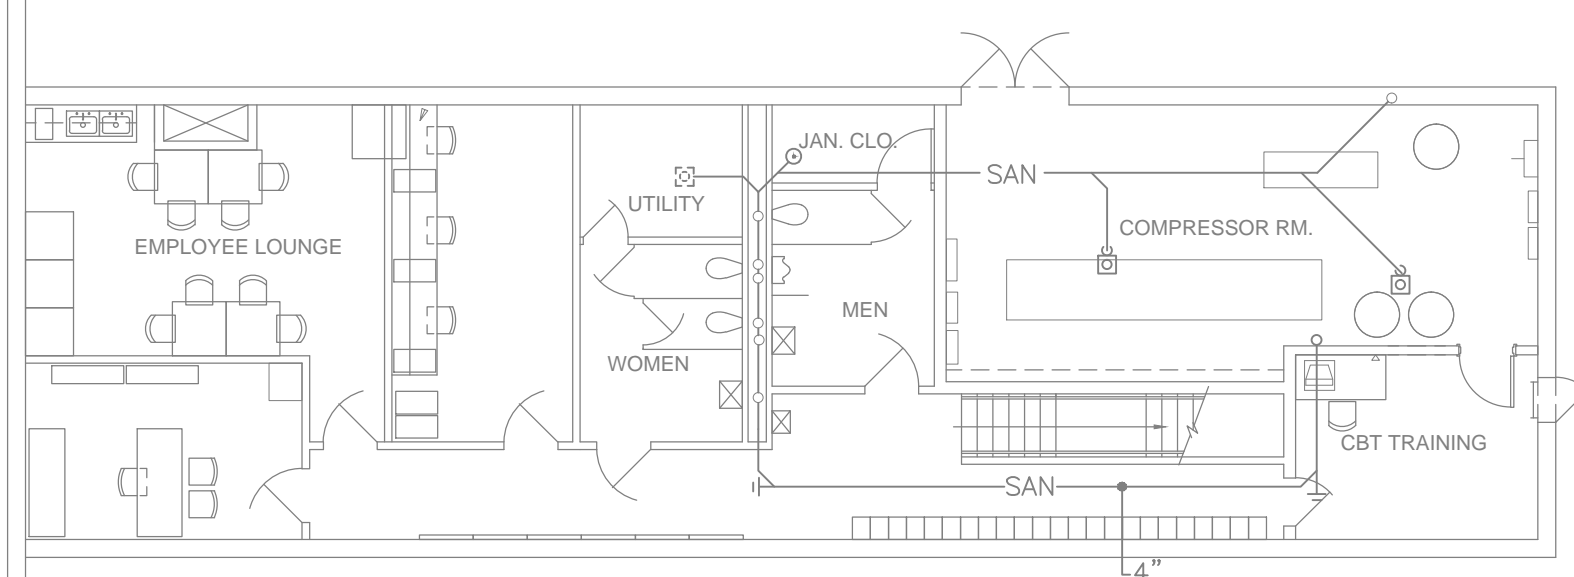


3 MEZZANINE PLAN
SCALE: 3/32" = 1'-0"

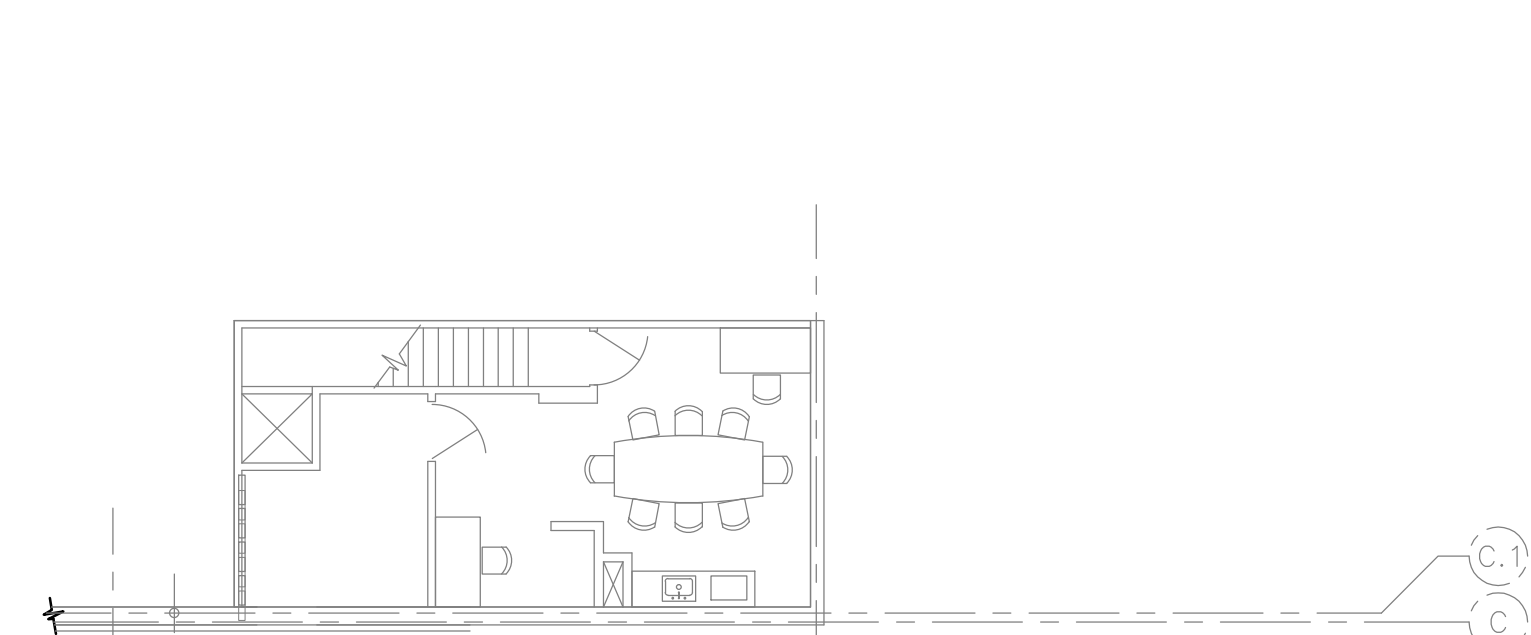

2 MEZZANINE PLAN
SCALE: 3/32" = 1'-0"

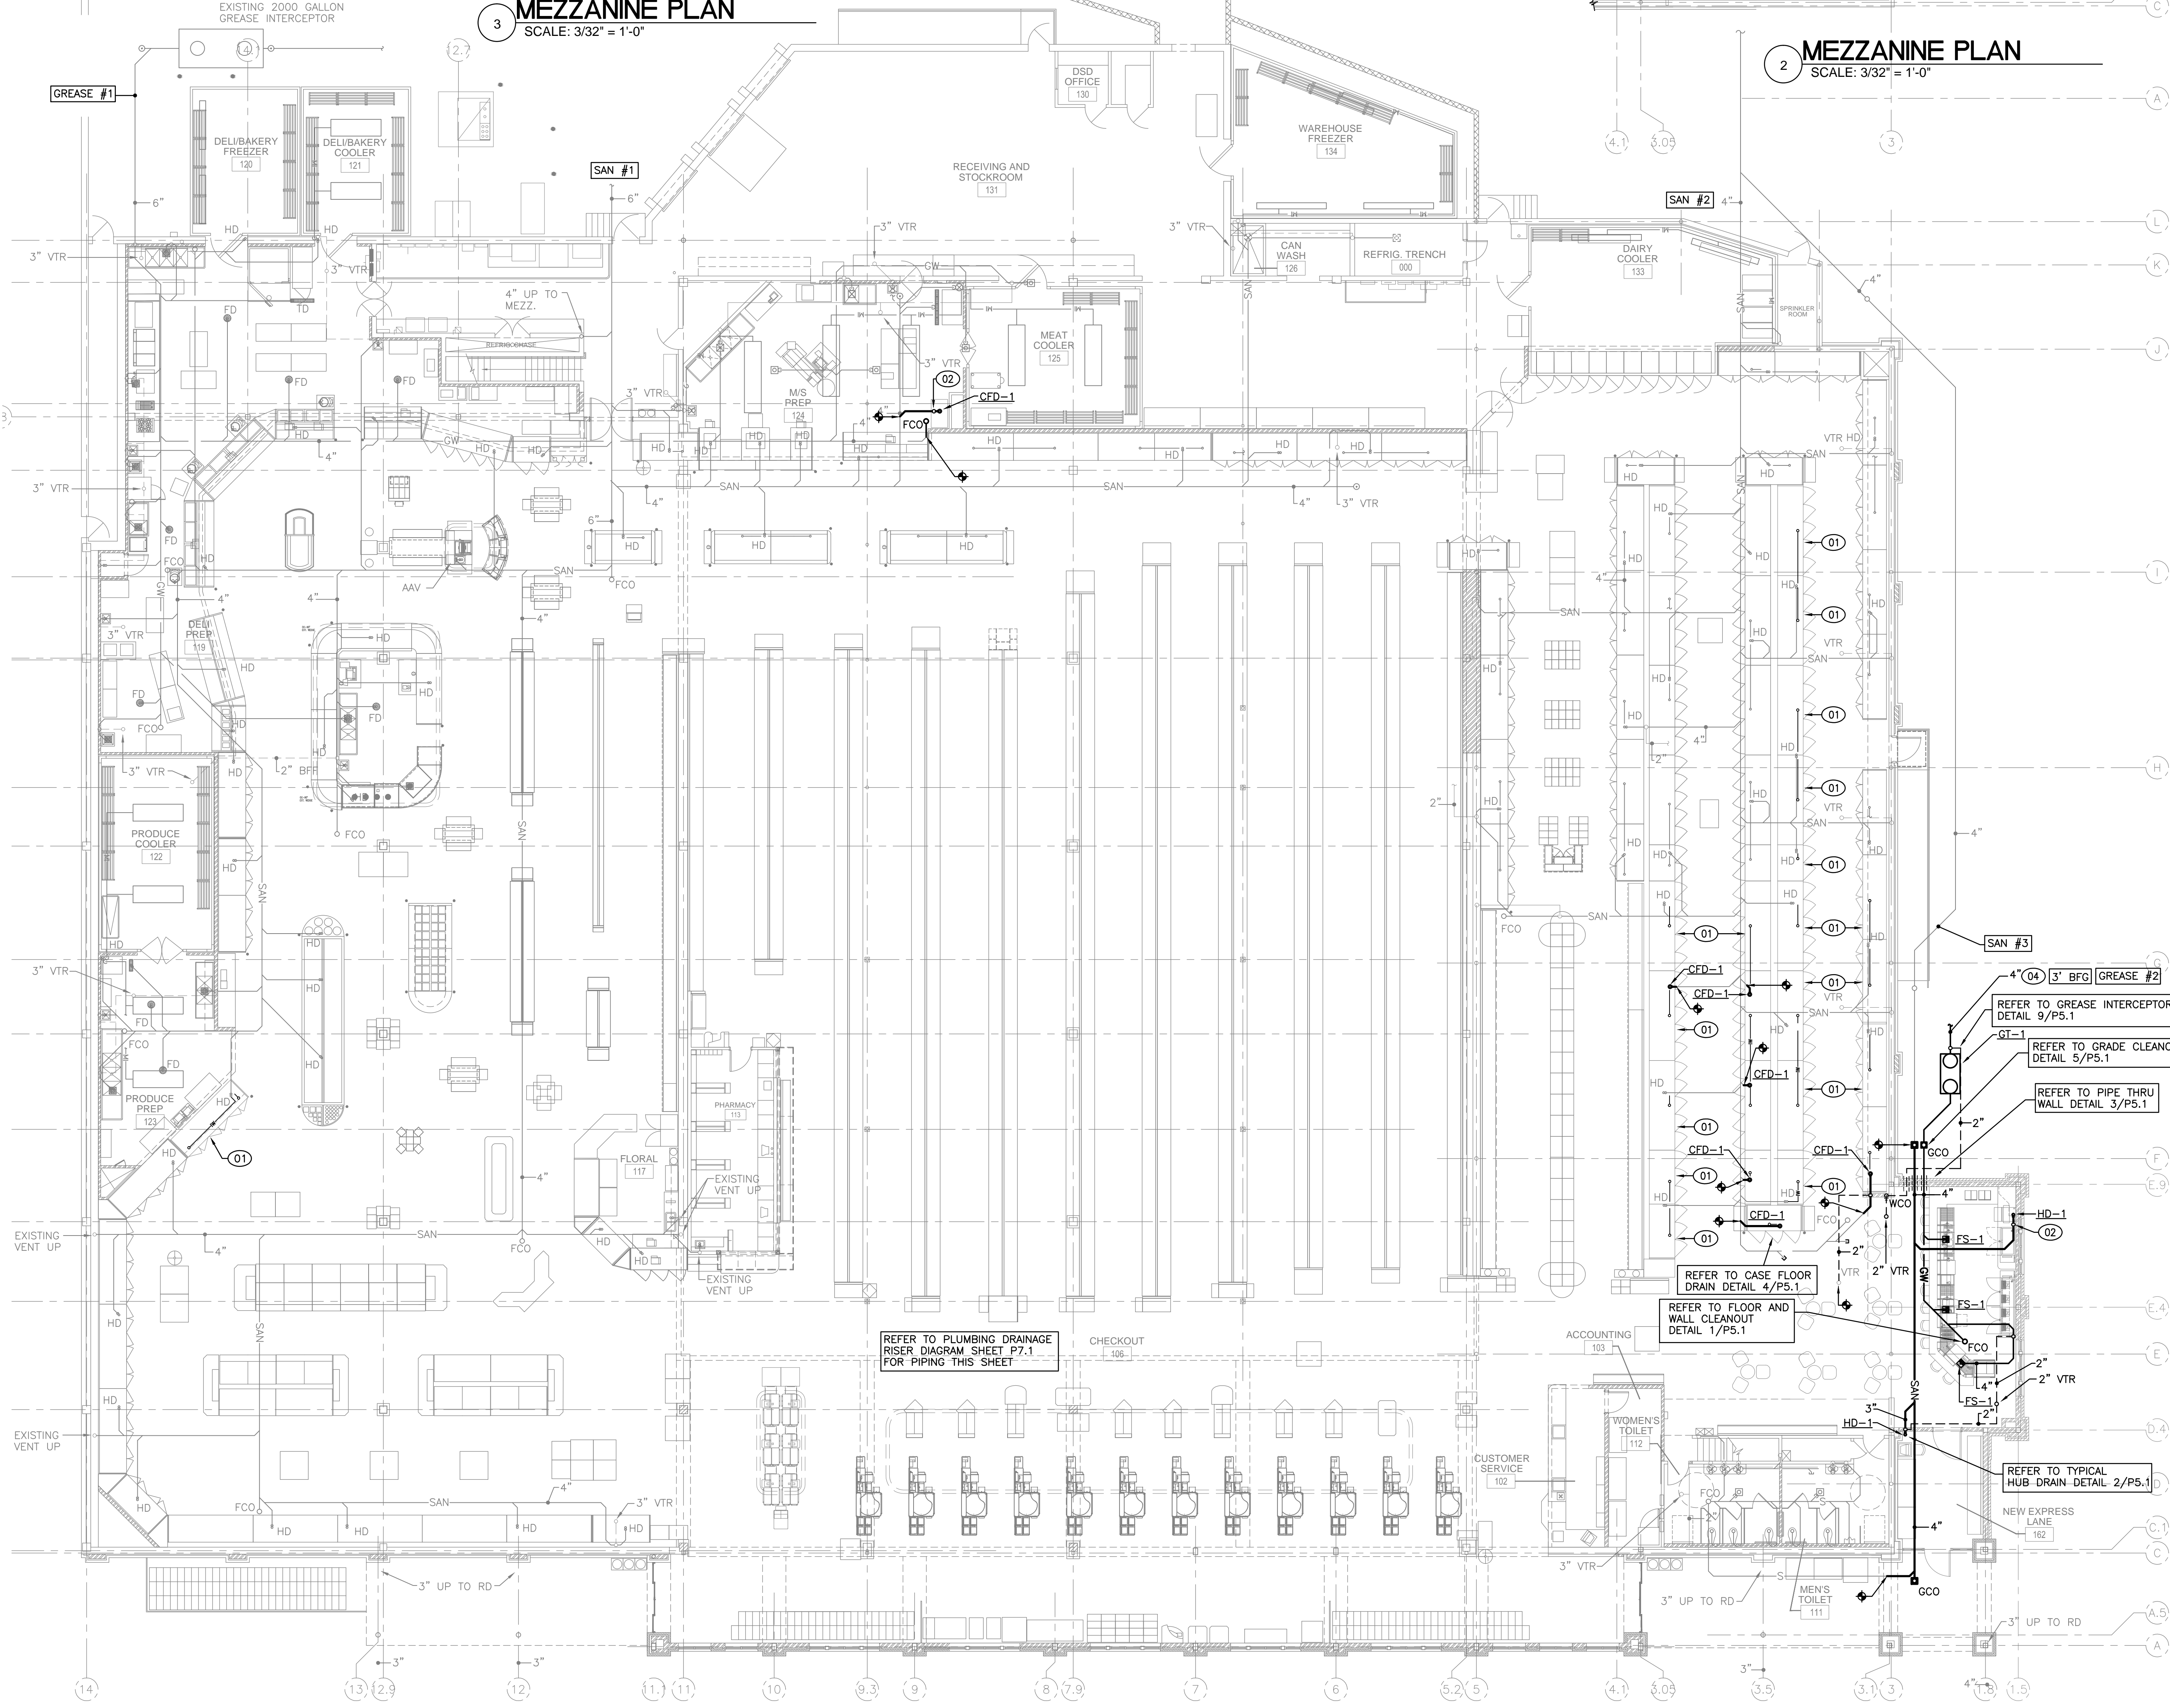

1 PLUMBING DRAINAGE PIPING PLAN
SCALE: 3/32" = 1'-0"

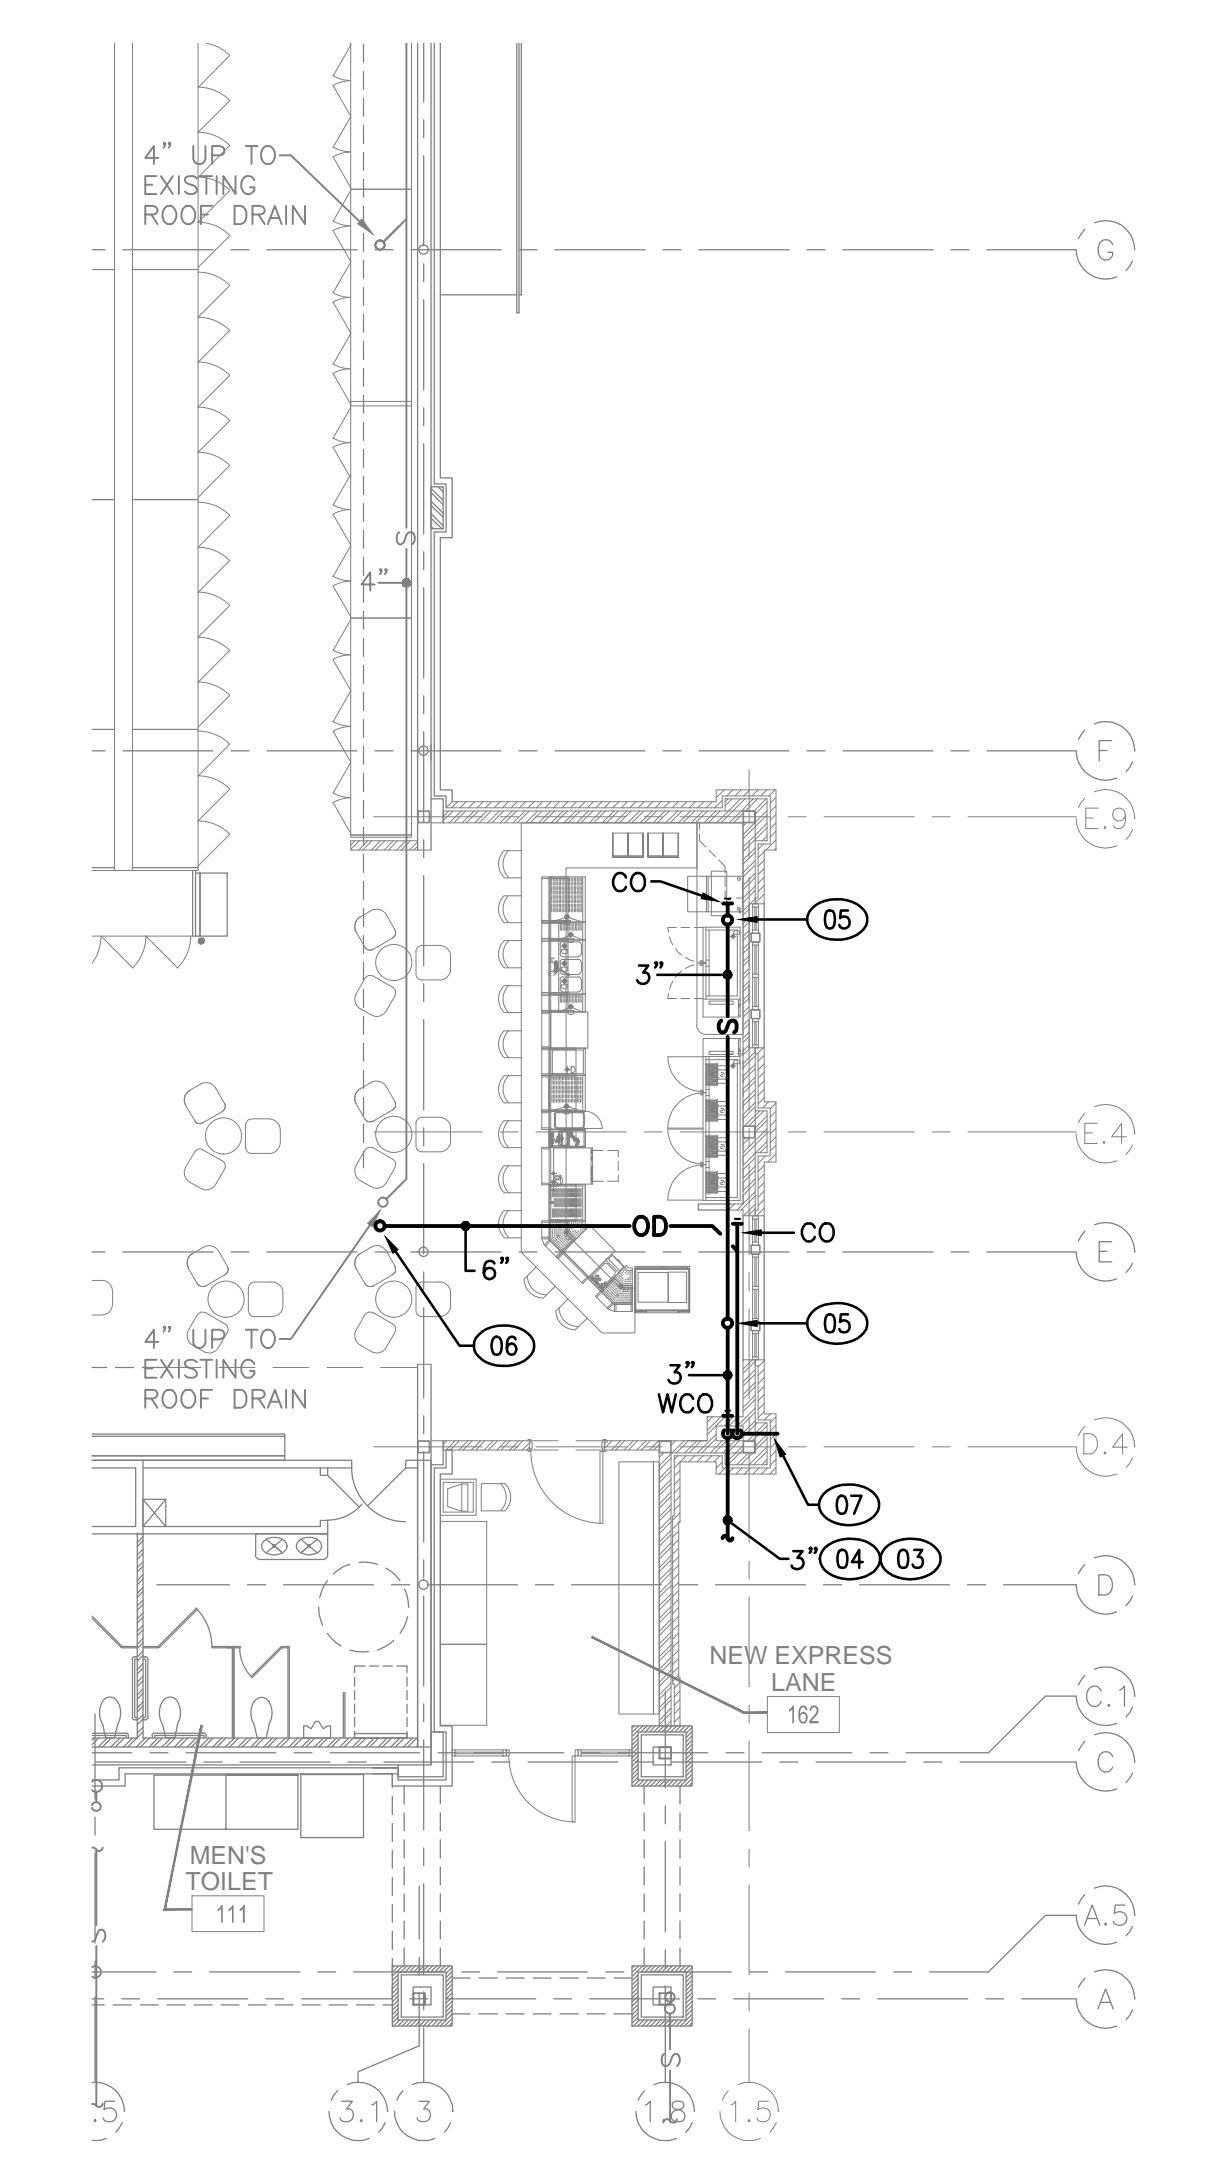

2 PARTIAL STORM PIPING PLAN
SCALE: 3/32" = 1'-0"

Harris Teeter
Your Neighborhood Food and Pharmacy

NOTE: THIS DOCUMENT MAY HAVE BEEN ELECTRONICALLY TRANSMITTED. IF UNSIGNED, IT CANNOT BE FILED FOR PUBLIC RECORD. PUBLIC RECORD FILINGS REQUIRE SIGNED AND SEALED DOCUMENTS.

John S. Parker
JOHN S. PARKER
PROFESSIONAL ENGINEER
SEAL 027092
Digitally Signed
Using IdentiTrust Certificate
2016.08.24 16:10:18-04'00'

HARRIS TEETER
STORE # 208
COTSWOLD SHOPPING CENTER
CHARLOTTE, NC

PROJECT MANAGER
RHOX STACY
JOB NO.
15-H1208-02
DR. BY
RLS

REVISIONS	Date
No.	Date
No.	Date
DRAWING NAME
PLUMBING DRAINAGE PIPING PLAN

SHEET NO.
P2.1

ISSUE DATE: 08.23.16