

NOTE: THIS DOCUMENT MAY HAVE BEEN ELECTRONICALLY TRANSMITTED. IF UNSIGNED, IT CANNOT BE FILED FOR PUBLIC RECORD. PUBLIC RECORD FILINGS REQUIRE SIGNED AND SEALED DOCUMENTS.


 Digitally Signed
 Using IdenTrust Certificate
 2016.08.24 16:10:16-04'00'

HARRIS TEETER
 STORE # 208
 COTSWOLD SHOPPING CENTER
 CHARLOTTE, NC

PROJECT MANAGER
 KIM STACY
 DR. NO.
 15-11208-02
 DR. BY
 KLG


REVISIONS	No.	Date

DRAWING NAME


PLUMBING DIMENSION PLAN

SHEET NO.
P8.1
 ISSUE DATE: 08.23.16


- GENERAL NOTES**
- ALL DIMENSIONS SHOWN ARE BASED ON ARCHITECTURAL FIXTURE PLAN.
 - DUE TO FIELD CONDITIONS, FLOOR PLAN REVISIONS AND FIXTURE CHANGES, THIS PLAN IS FOR COORDINATION ONLY AND NOT AN ACTUAL CONSTRUCTION DOCUMENT.
 - ALL FINAL LOCATIONS OF DRAINS AND STUB UPS SHALL BE COORDINATED WITH FINAL FIXTURE LAYOUT AND REVIEWED BY OWNER'S FIELD REPRESENTATIVE, REFRIGERATION CONTRACTOR, AND ARCHITECT PRIOR TO THE INSTALLATION.
 - PLUMBING CONTRACTOR SHALL INCLUDE IN HIS BID, AN ALTERNATE PRICE FOR THE RELOCATION OF ANY DRAINS OR STUB UPS DUE TO CHANGES WHILE UNDER CONSTRUCTION. THIS ALTERNATE SHALL BE FOR ALL WORK INCLUDING CUTTING SLAB, RELOCATING THE DRAIN OR STUB UPS, MODIFYING PIPING, BACKFILL AND PATCHING AND ALL OTHER WORK TO COMPLETE RELOCATION. ALTERNATE PRICE SHALL BE GIVEN AS A PRICE PER LINEAR FOOT. NO ADDITIONAL COSTS WILL BE CONSIDERED.
 - SET DRAIN ELEVATION DEPRESSED BELOW FINISHED SLAB ELEVATIONS PER ARCHITECTURAL PLANS.
 - ALL HUB DRAINS, CONDENSATE FLOOR DRAINS, AND FLOOR SINKS TO BE ACCESSIBLE FOR MAINTENANCE.

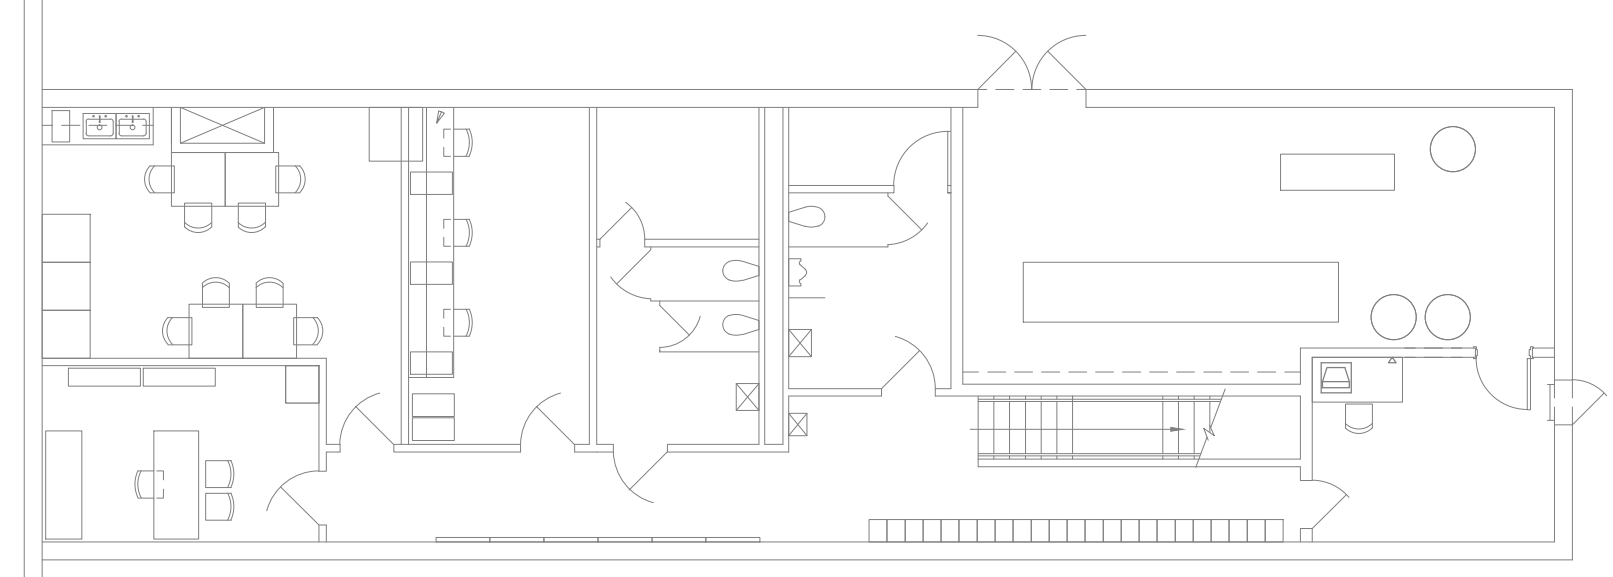

3 MEZZANINE PLAN
NO SCALE

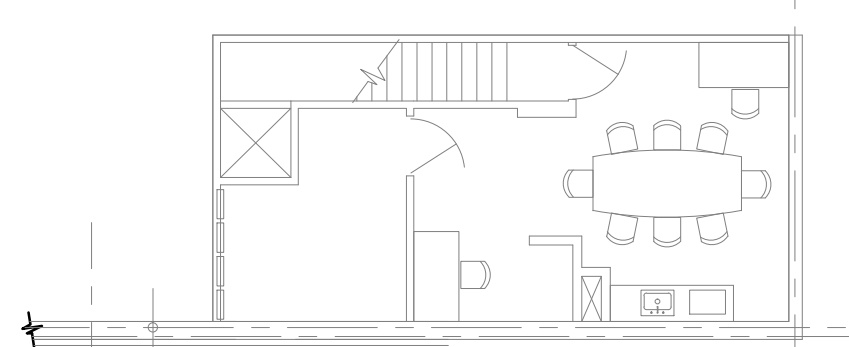

2 MEZZANINE PLAN
NO SCALE

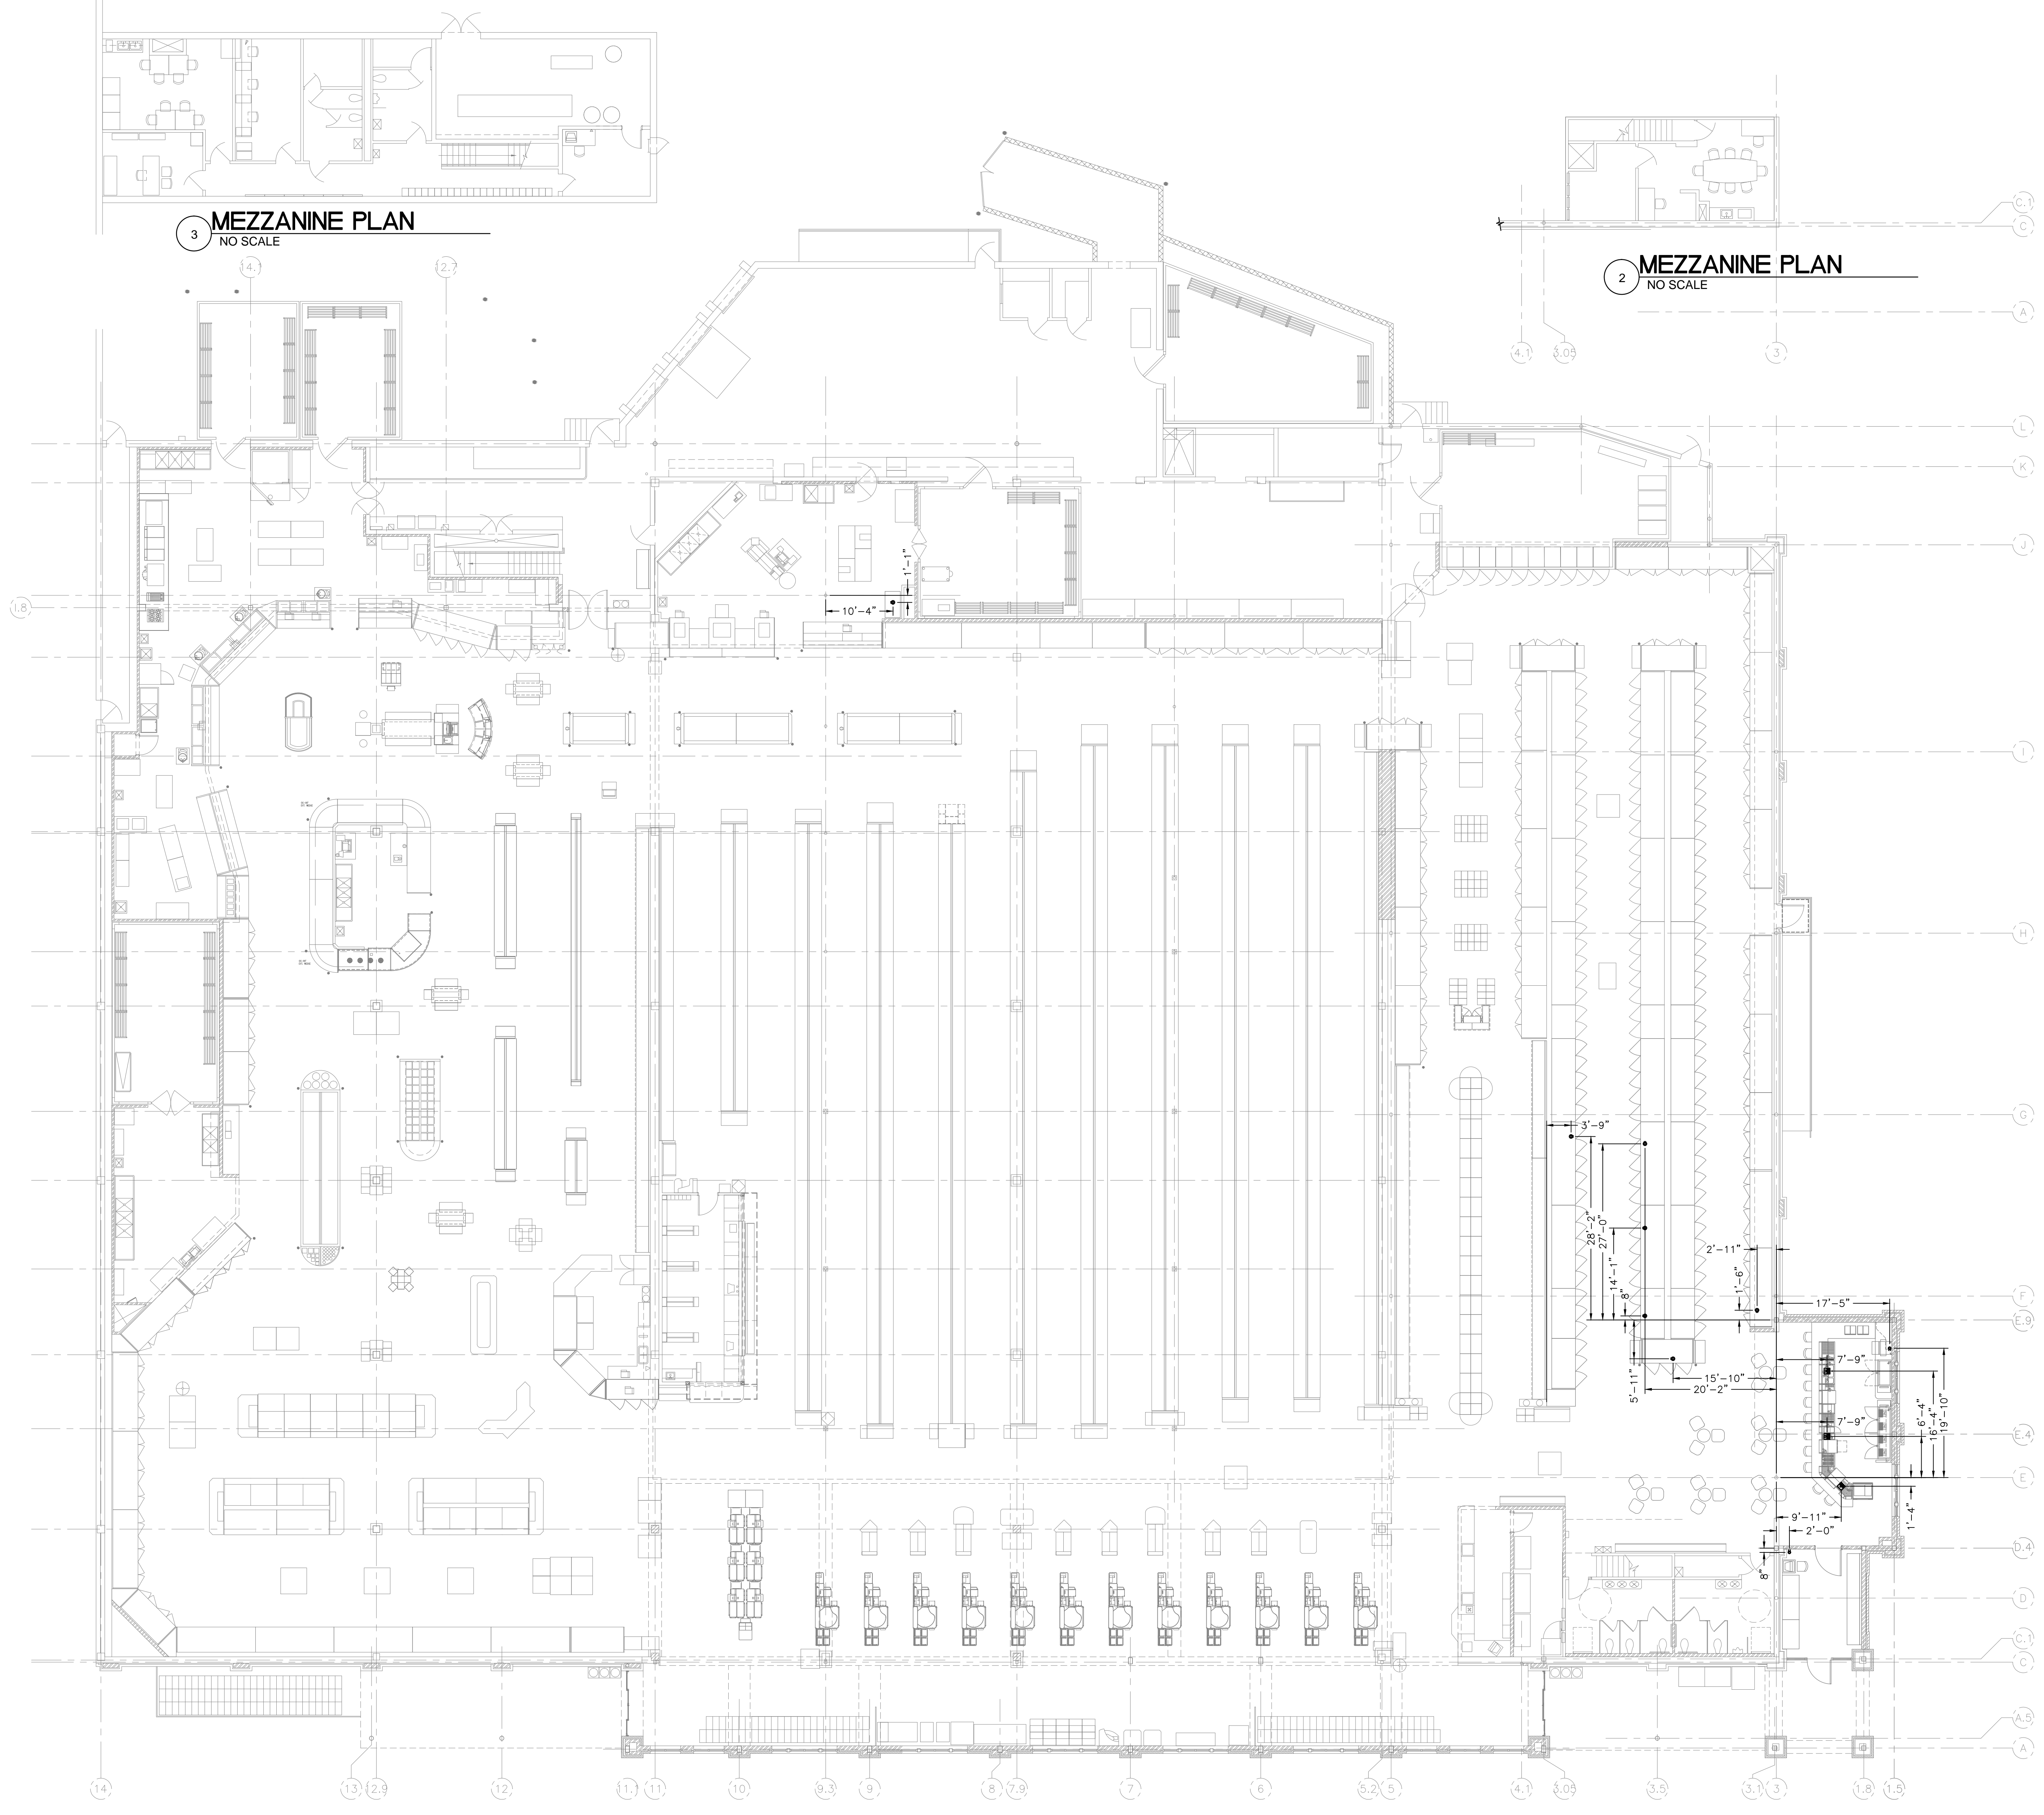

1 PLUMBING DIMENSION PLAN
NO SCALE