

NOTE: THIS DOCUMENT MAY HAVE BEEN ELECTRONICALLY TRANSMITTED. IF UNSIGNED, IT CANNOT BE FILED FOR PUBLIC RECORD. PUBLIC RECORD FILINGS REQUIRE SIGNED AND SEALED DOCUMENTS.

Harris Teeter
 Your Neighborhood Food Market

HARRIS TEETER #441
 SOUTH COLLEGE RD. & SHIPYARD
 WILMINGTON, NC



Electronically Signed by:
 John S Parker
 Created via Bluebeam PDF Revu
 WildenTrust Certificate
 2014.05.05 15:14:22-04'00"

PROJECT MANAGER
 KIM STADY
 DR. BY
 KES

REVISIONS	Date

DRAWING NAME

PLUMBING RISER DIAGRAMS


SHEET NO.

P3.1


ISSUE DATE: 5/9/14

KEYED NOTES


REFER TO SHEET P2.1 FOR KEYED NOTES.

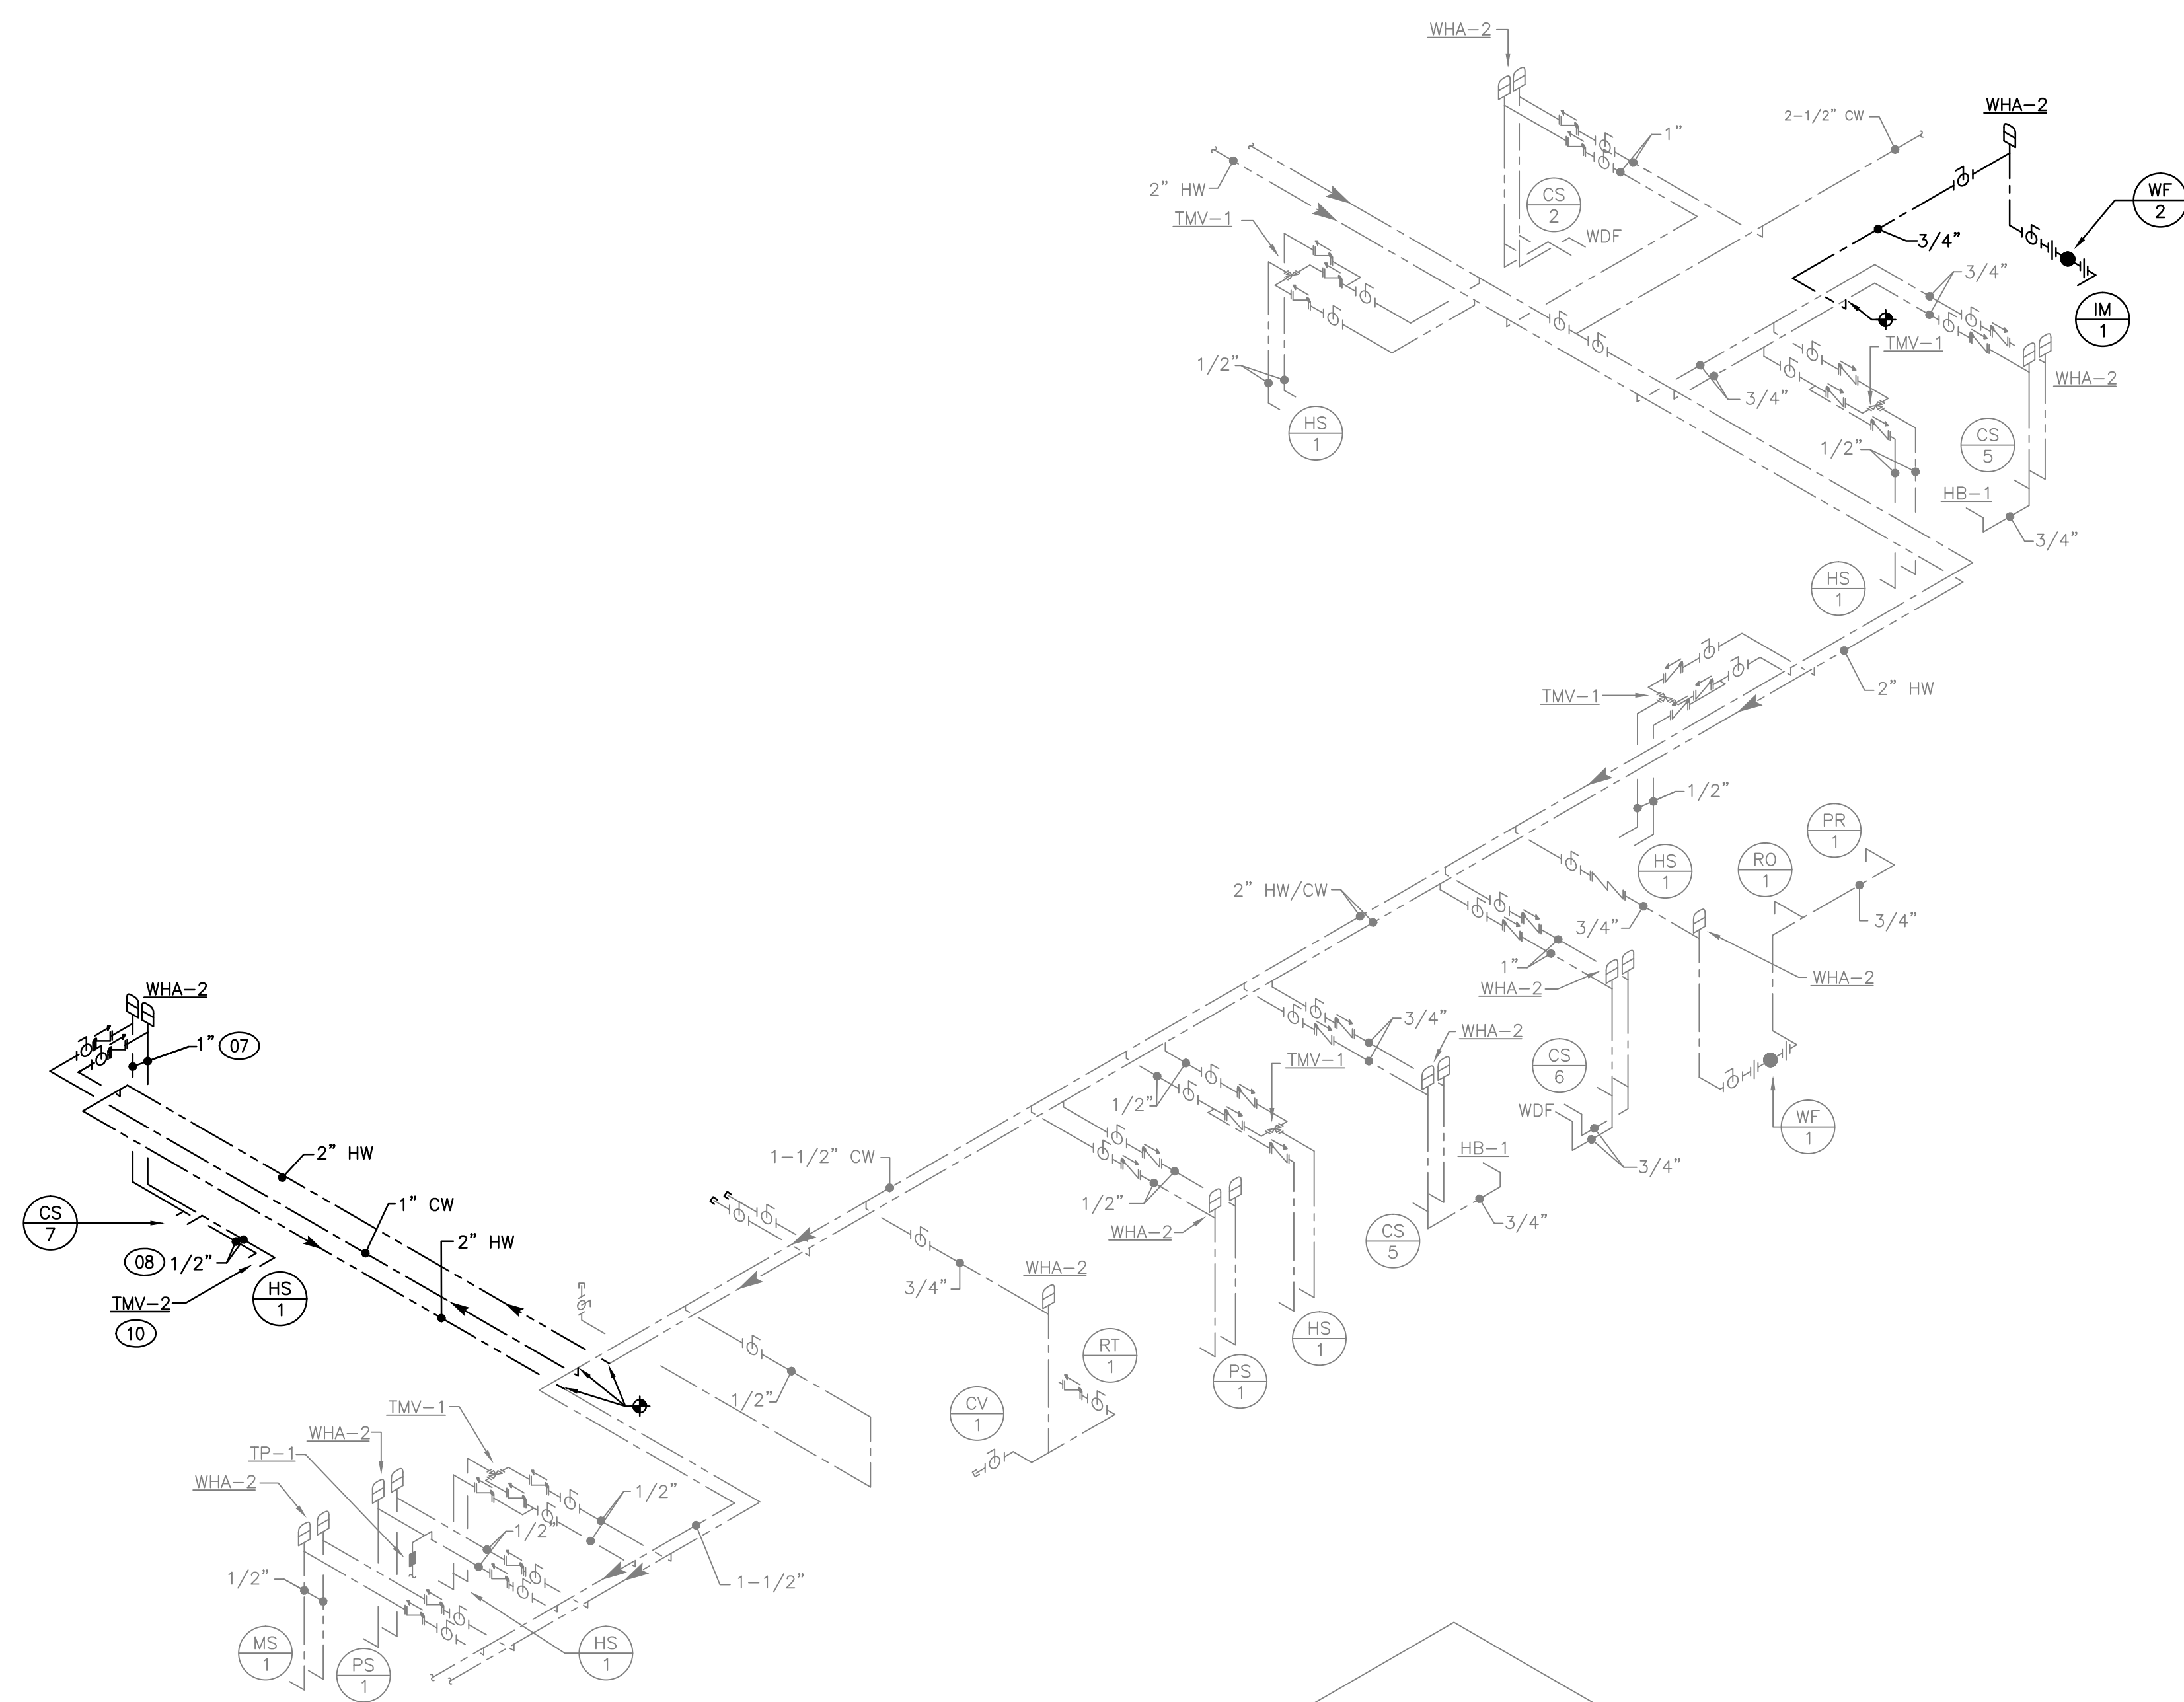

1 PARTIAL WATER RISER DIAGRAM
 NO SCALE

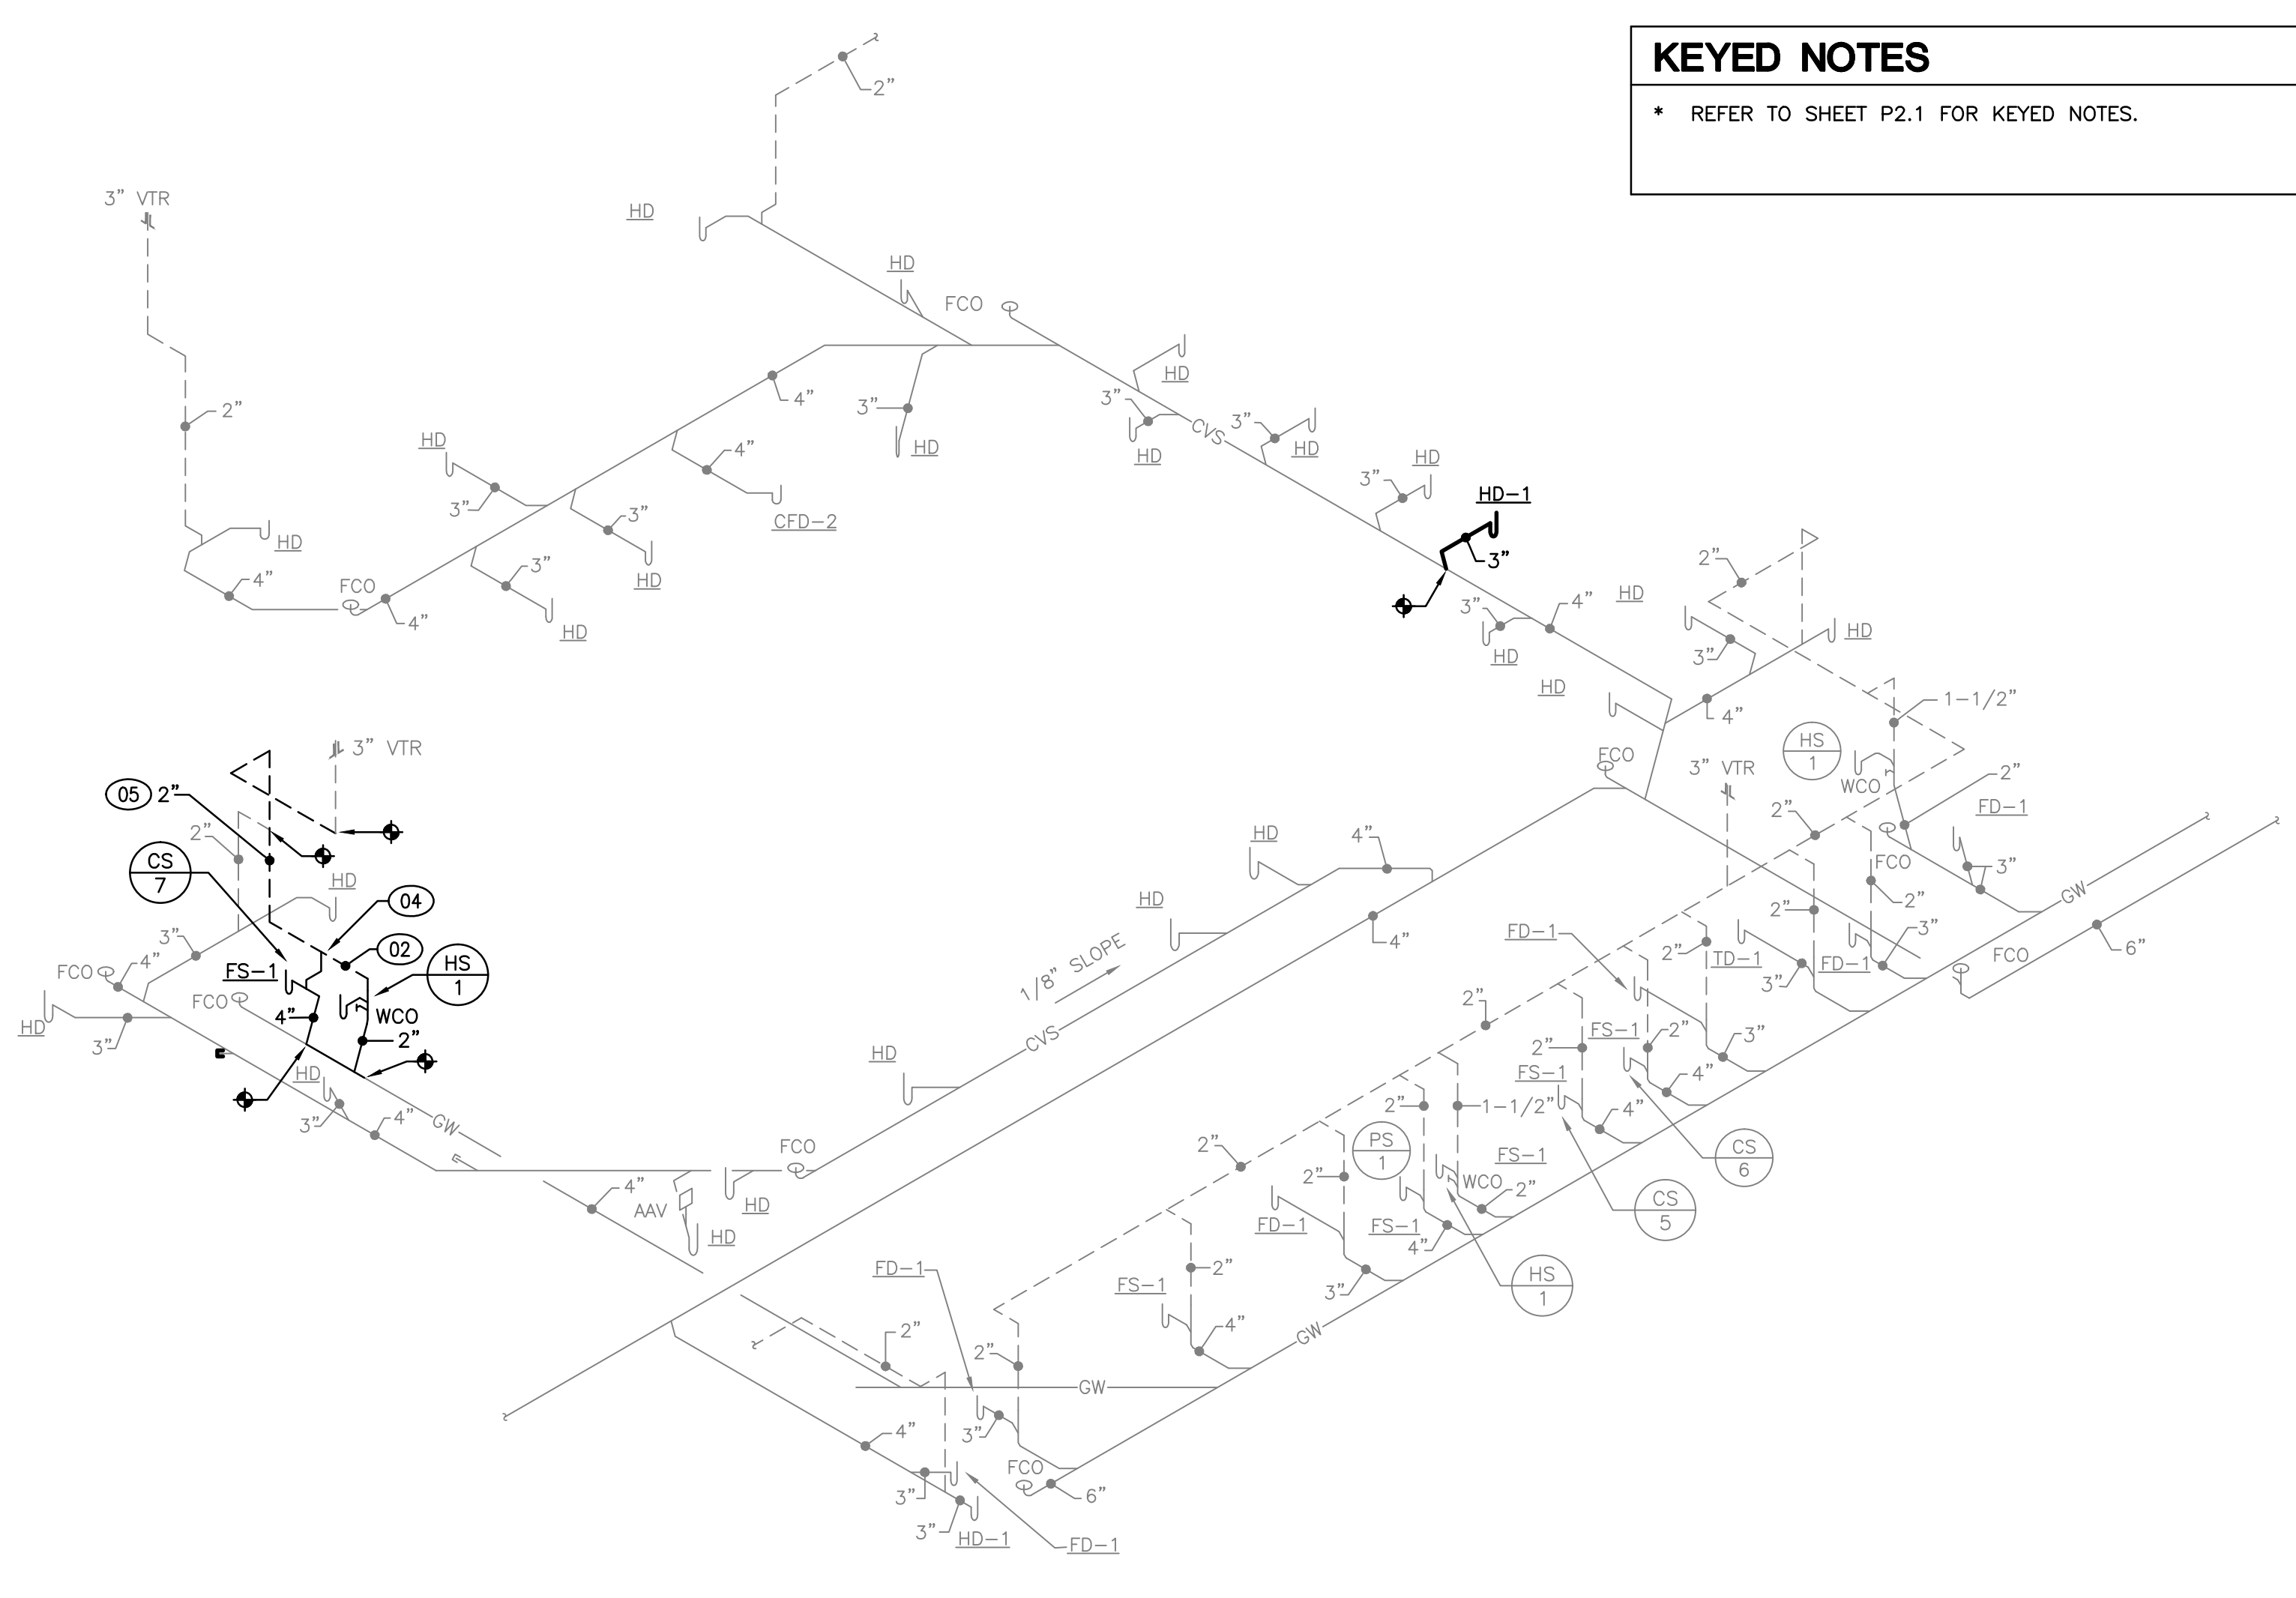

2 PARTIAL DRAINAGE RISER DIAGRAM
 NO SCALE

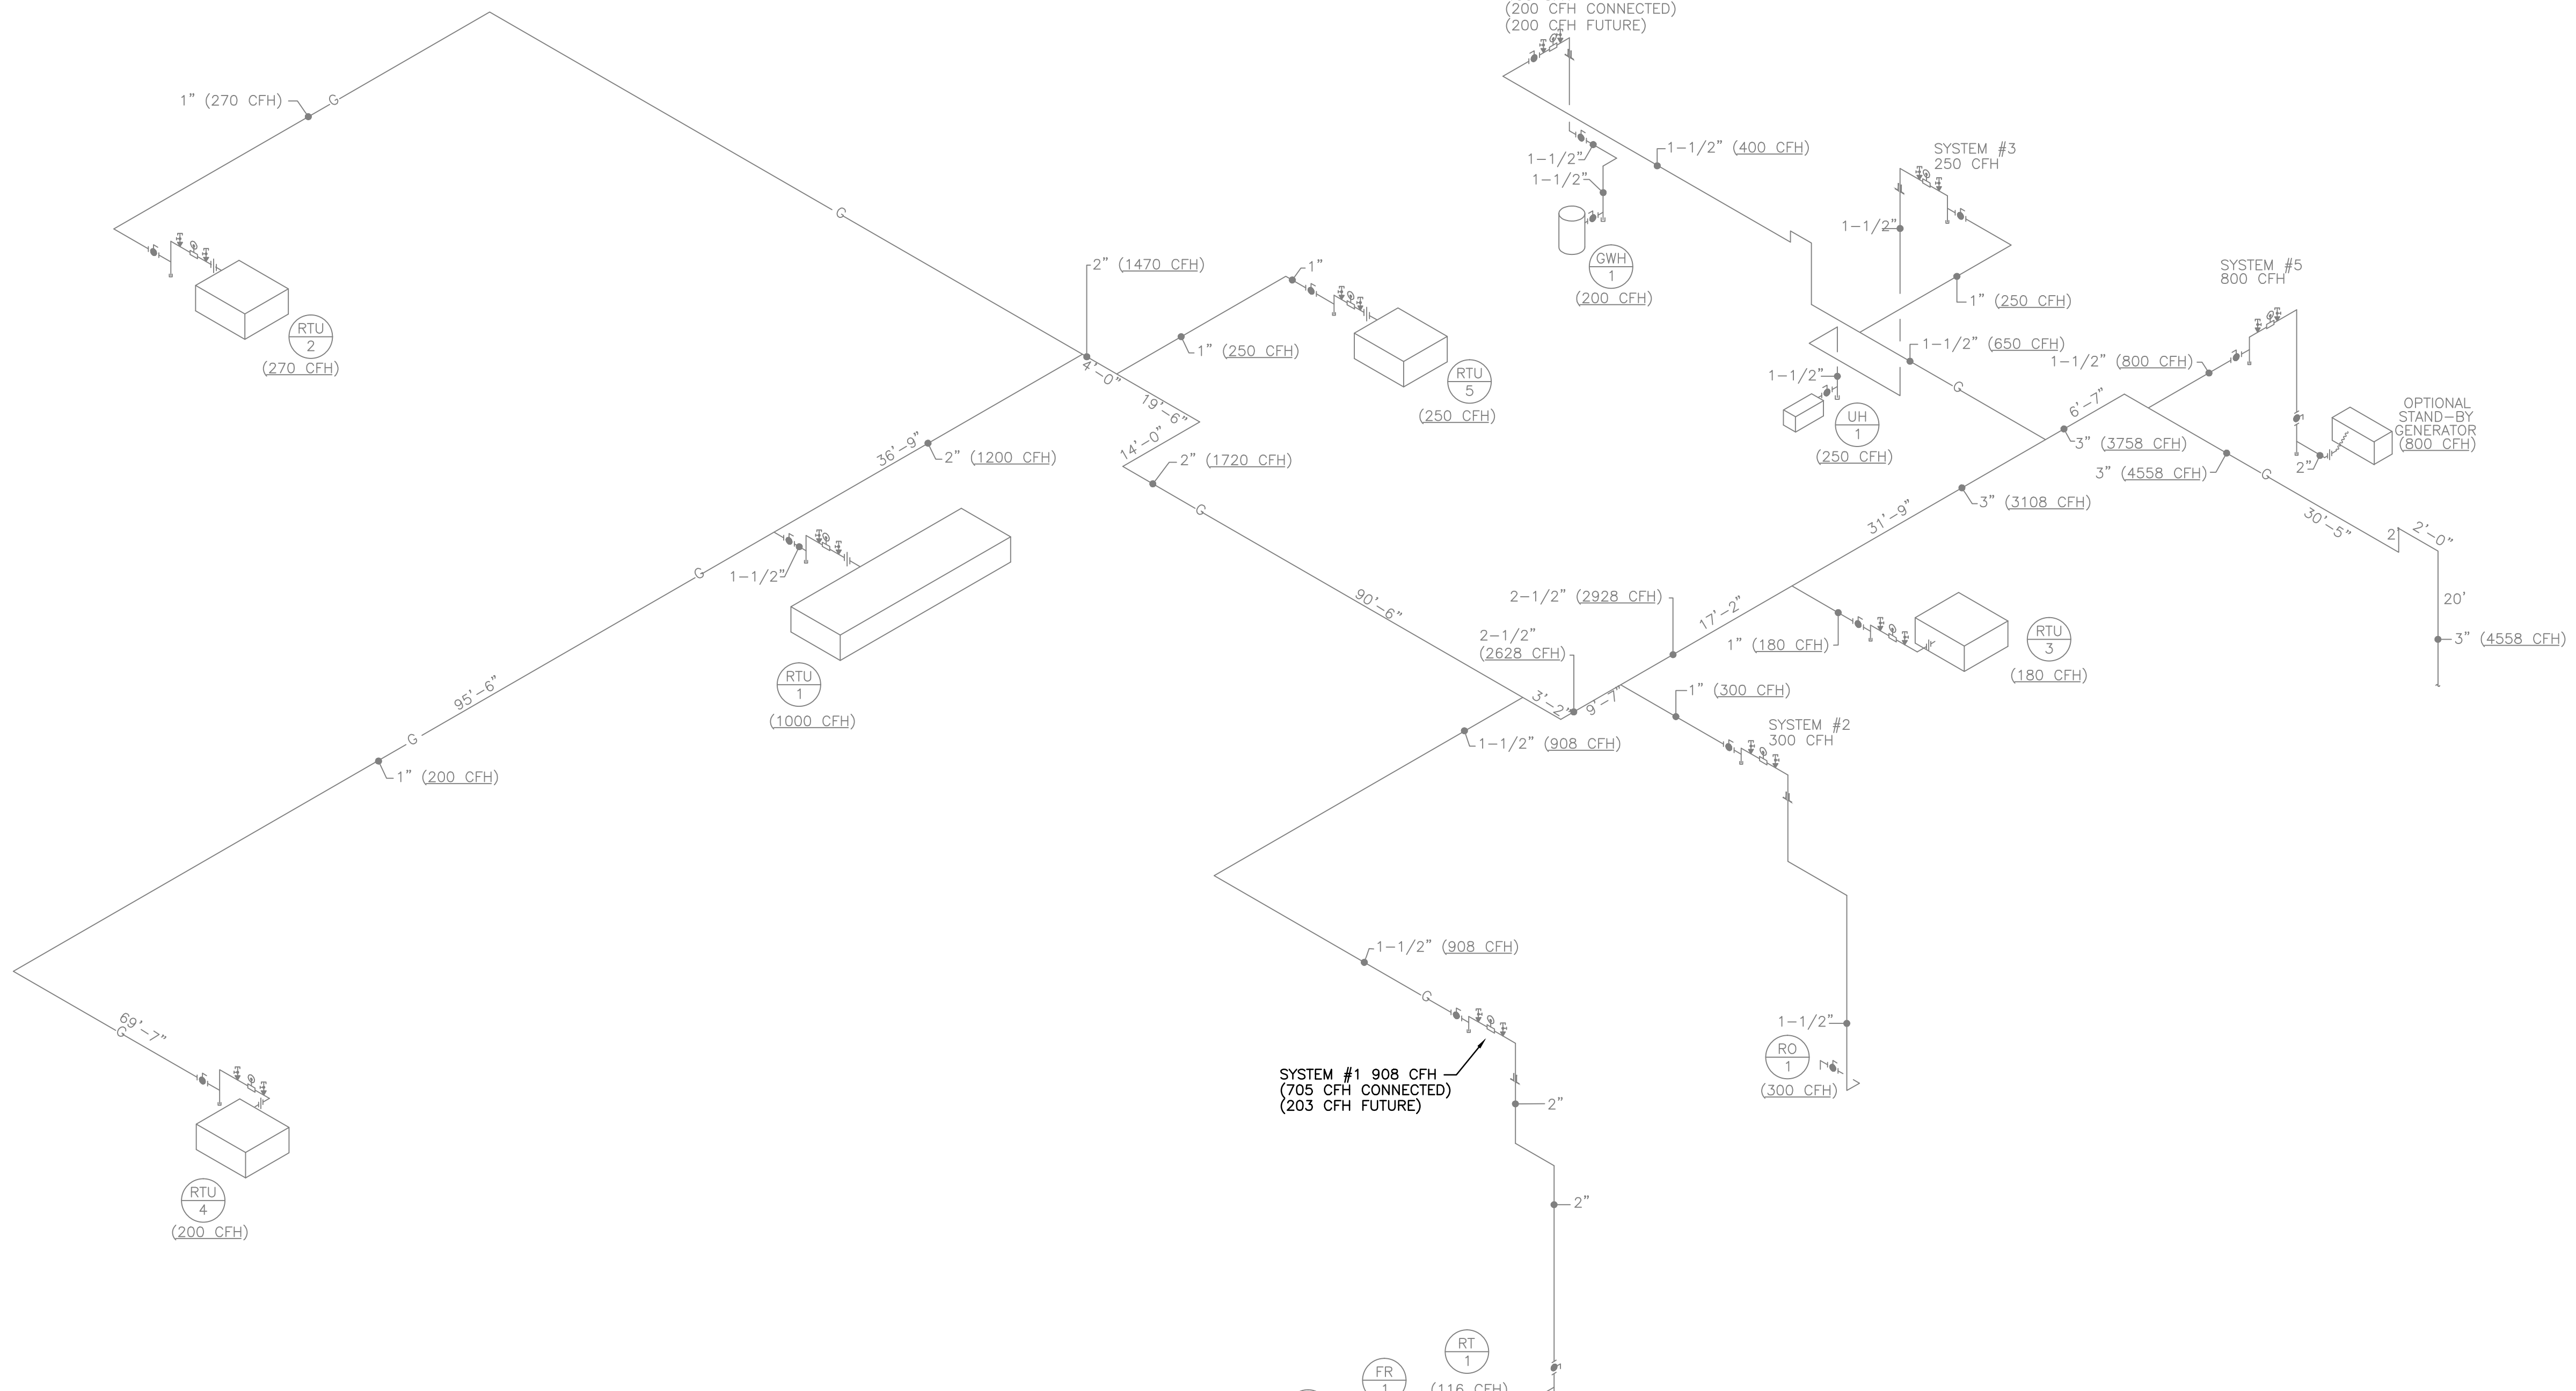

3 GAS RISER DIAGRAM
 NO SCALE