


PROJECT MANAGER: KIM STACY	
JOB NO.: 18-HR-02	
DR. BY: KLB	
REVISIONS	
No. 1	Date: 10/24/18
No. 2	Date:
No. 3	Date:
No. 4	Date:
No. 5	Date:
No. 6	Date:
No. 7	Date:
No. 8	Date:
No. 9	Date:
No. 10	Date:

SHEET NAME:  
**PLUMBING DIMENSION PLAN**

SHEET NO.  
 18  
 ISSUE DATE:  
 10/22/18

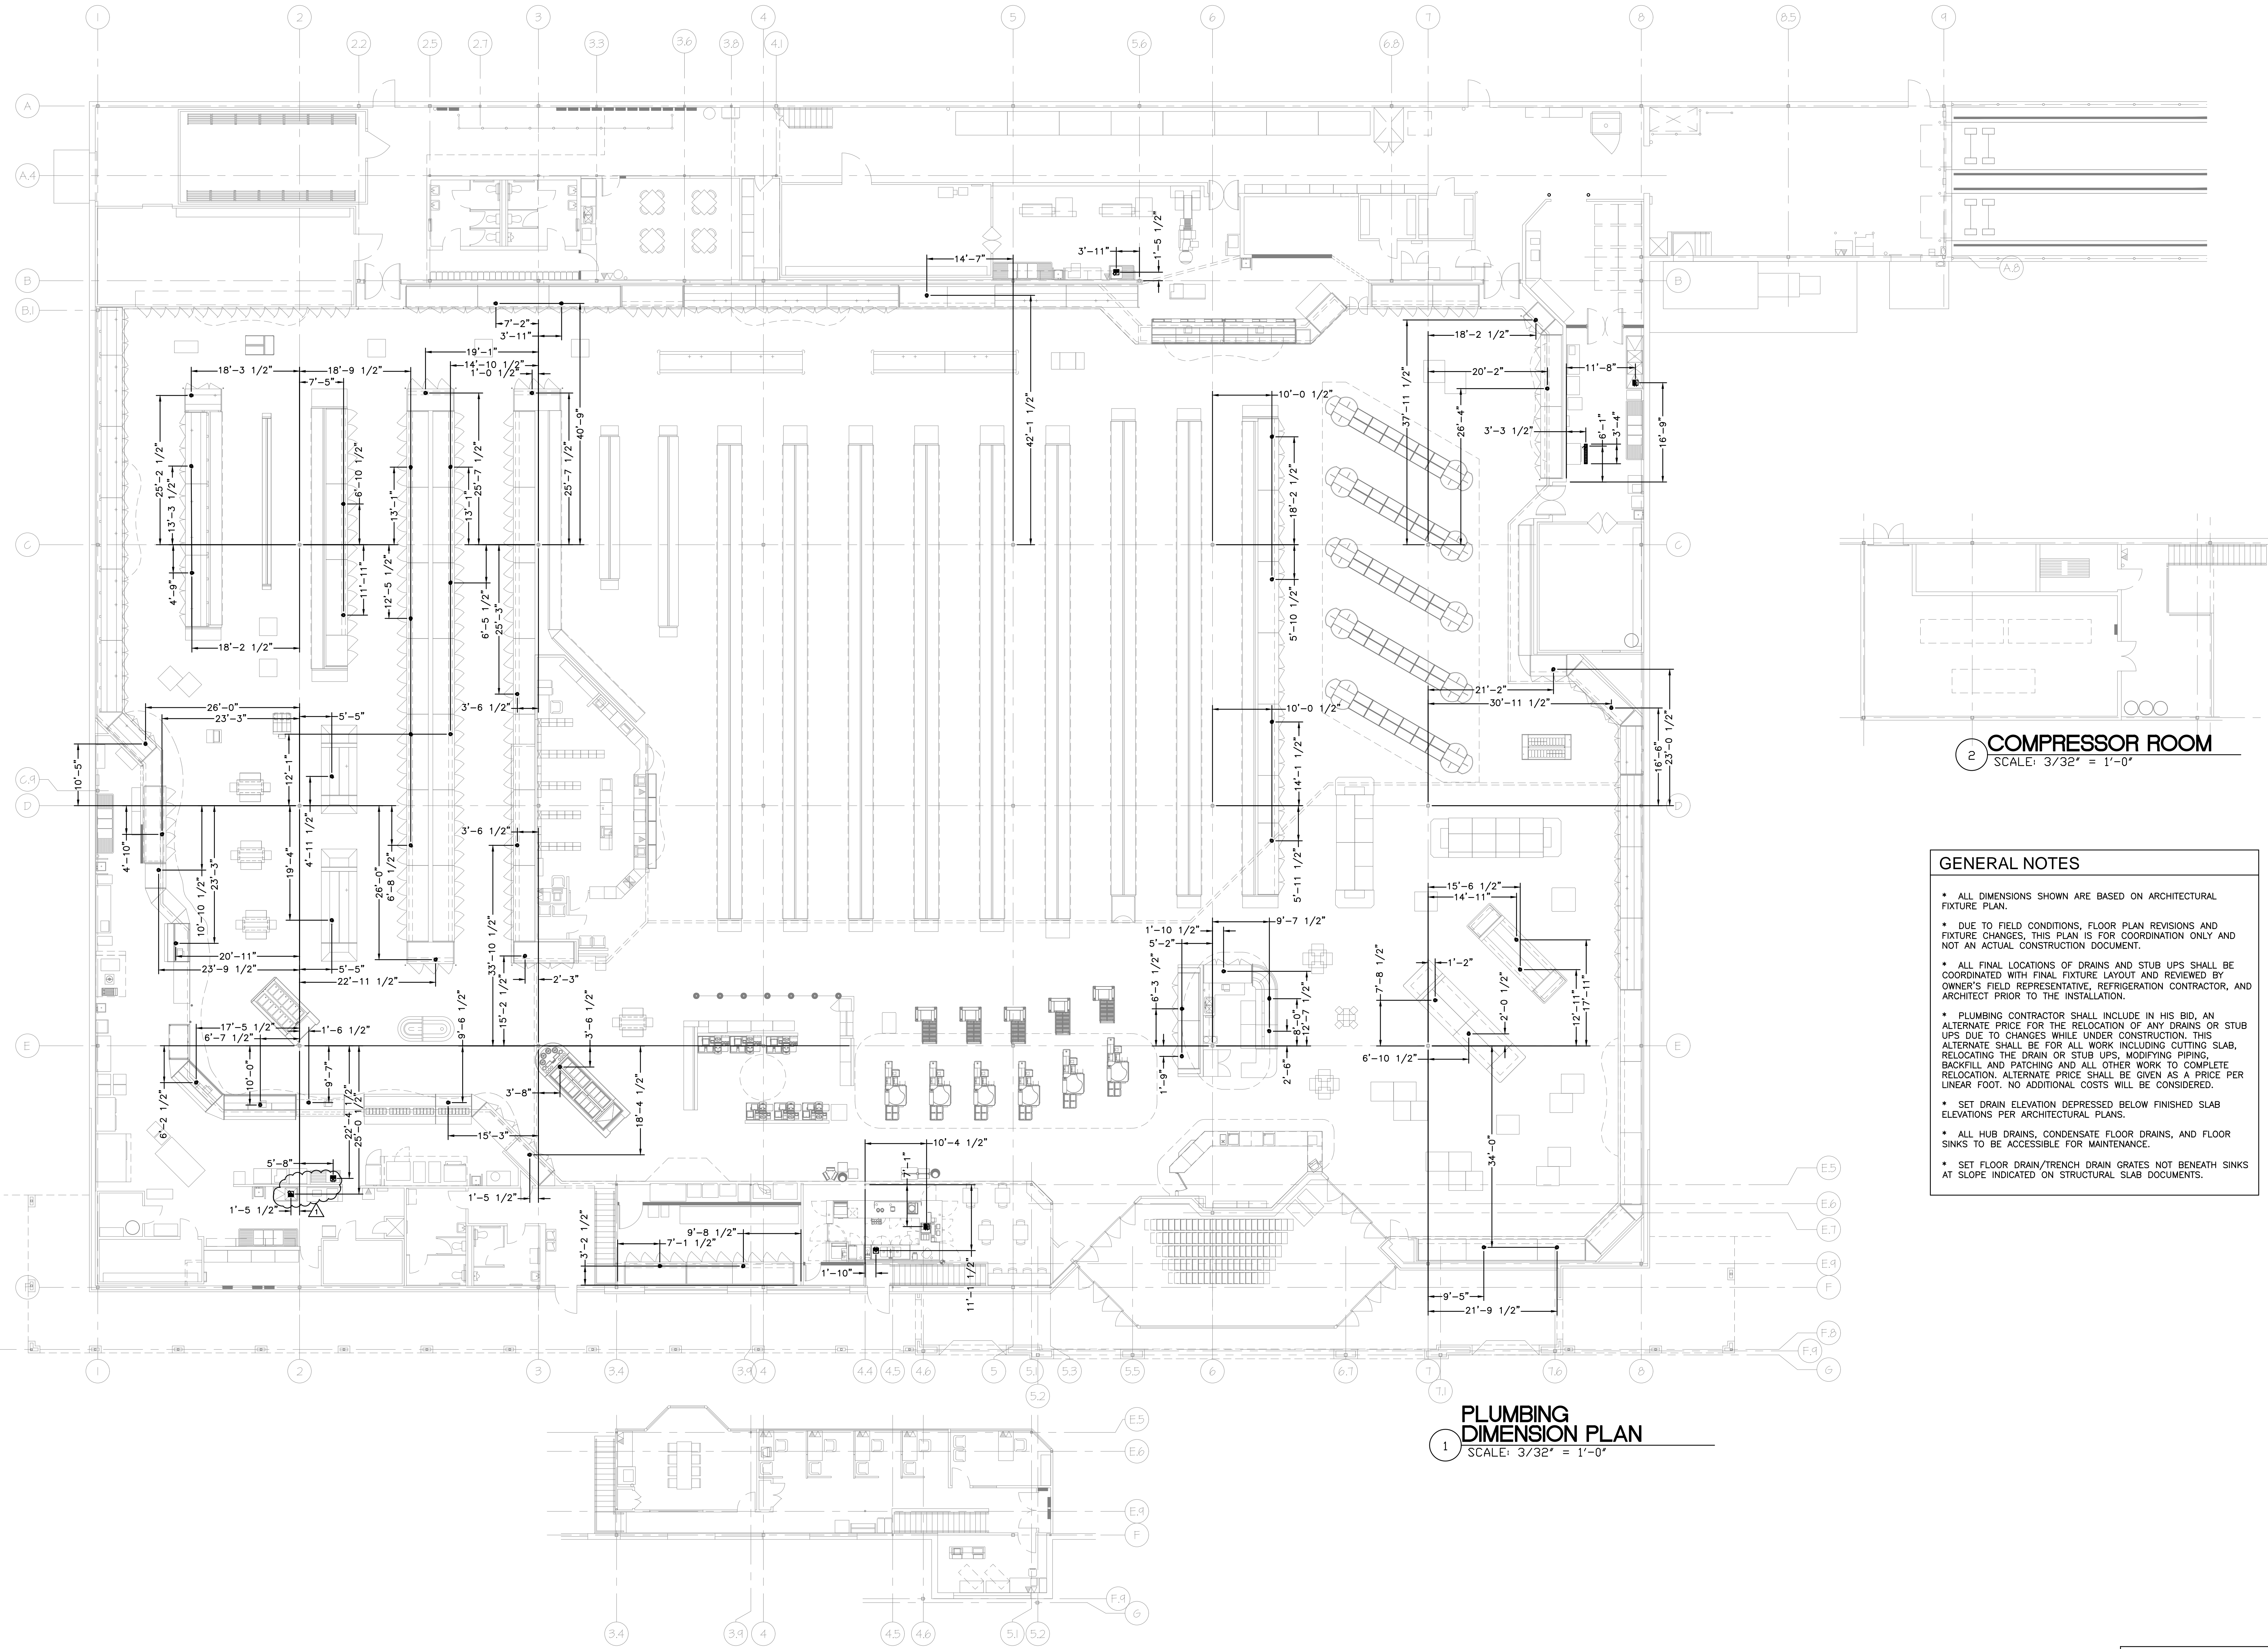

2 COMPRESSOR ROOM  
 SCALE: 3/32" = 1'-0"

**GENERAL NOTES**

- ALL DIMENSIONS SHOWN ARE BASED ON ARCHITECTURAL FIXTURE PLAN.
- DUE TO FIELD CONDITIONS, FLOOR PLAN REVISIONS AND FIXTURE CHANGES, THIS PLAN IS FOR COORDINATION ONLY AND NOT AN ACTUAL CONSTRUCTION DOCUMENT.
- ALL FINAL LOCATIONS OF DRAINS AND STUB UPS SHALL BE COORDINATED WITH FINAL FIXTURE LAYOUT AND REVIEWED BY OWNER'S FIELD REPRESENTATIVE, REFRIGERATION CONTRACTOR, AND ARCHITECT PRIOR TO THE INSTALLATION.
- PLUMBING CONTRACTOR SHALL INCLUDE IN HIS BID, AN ALTERNATE PRICE FOR THE RELOCATION OF ANY DRAINS OR STUB UPS DUE TO CHANGES WHILE UNDER CONSTRUCTION. THIS ALTERNATE SHALL BE FOR ALL WORK INCLUDING CUTTING SLAB, RELOCATING THE DRAIN OR STUB UPS, MODIFYING PIPING, BACKFILL AND PATCHING AND ALL OTHER WORK TO COMPLETE RELOCATION. ALTERNATE PRICE SHALL BE GIVEN AS A PRICE PER LINEAR FOOT. NO ADDITIONAL COSTS WILL BE CONSIDERED.
- SET DRAIN ELEVATION DEPRESSED BELOW FINISHED SLAB ELEVATIONS PER ARCHITECTURAL PLANS.
- ALL HUB DRAINS, CONDENSATE FLOOR DRAINS, AND FLOOR SINKS TO BE ACCESSIBLE FOR MAINTENANCE.
- SET FLOOR DRAIN/TRENCH DRAIN GRATES NOT BENEATH SINKS AT SLOPE INDICATED ON STRUCTURAL SLAB DOCUMENTS.

1 PLUMBING DIMENSION PLAN  
 SCALE: 3/32" = 1'-0"

3 MEZZANINE PLAN  
 SCALE: 3/32" = 1'-0"

NOTE: THIS DOCUMENT MAY HAVE BEEN ELECTRONICALLY TRANSMITTED. IF UNSIGNED, IT CANNOT BE FILED FOR PUBLIC RECORD. PUBLIC RECORD FILINGS REQUIRE SIGNED AND SEALED DOCUMENTS.